


7/1/2025 8:18:47 PM

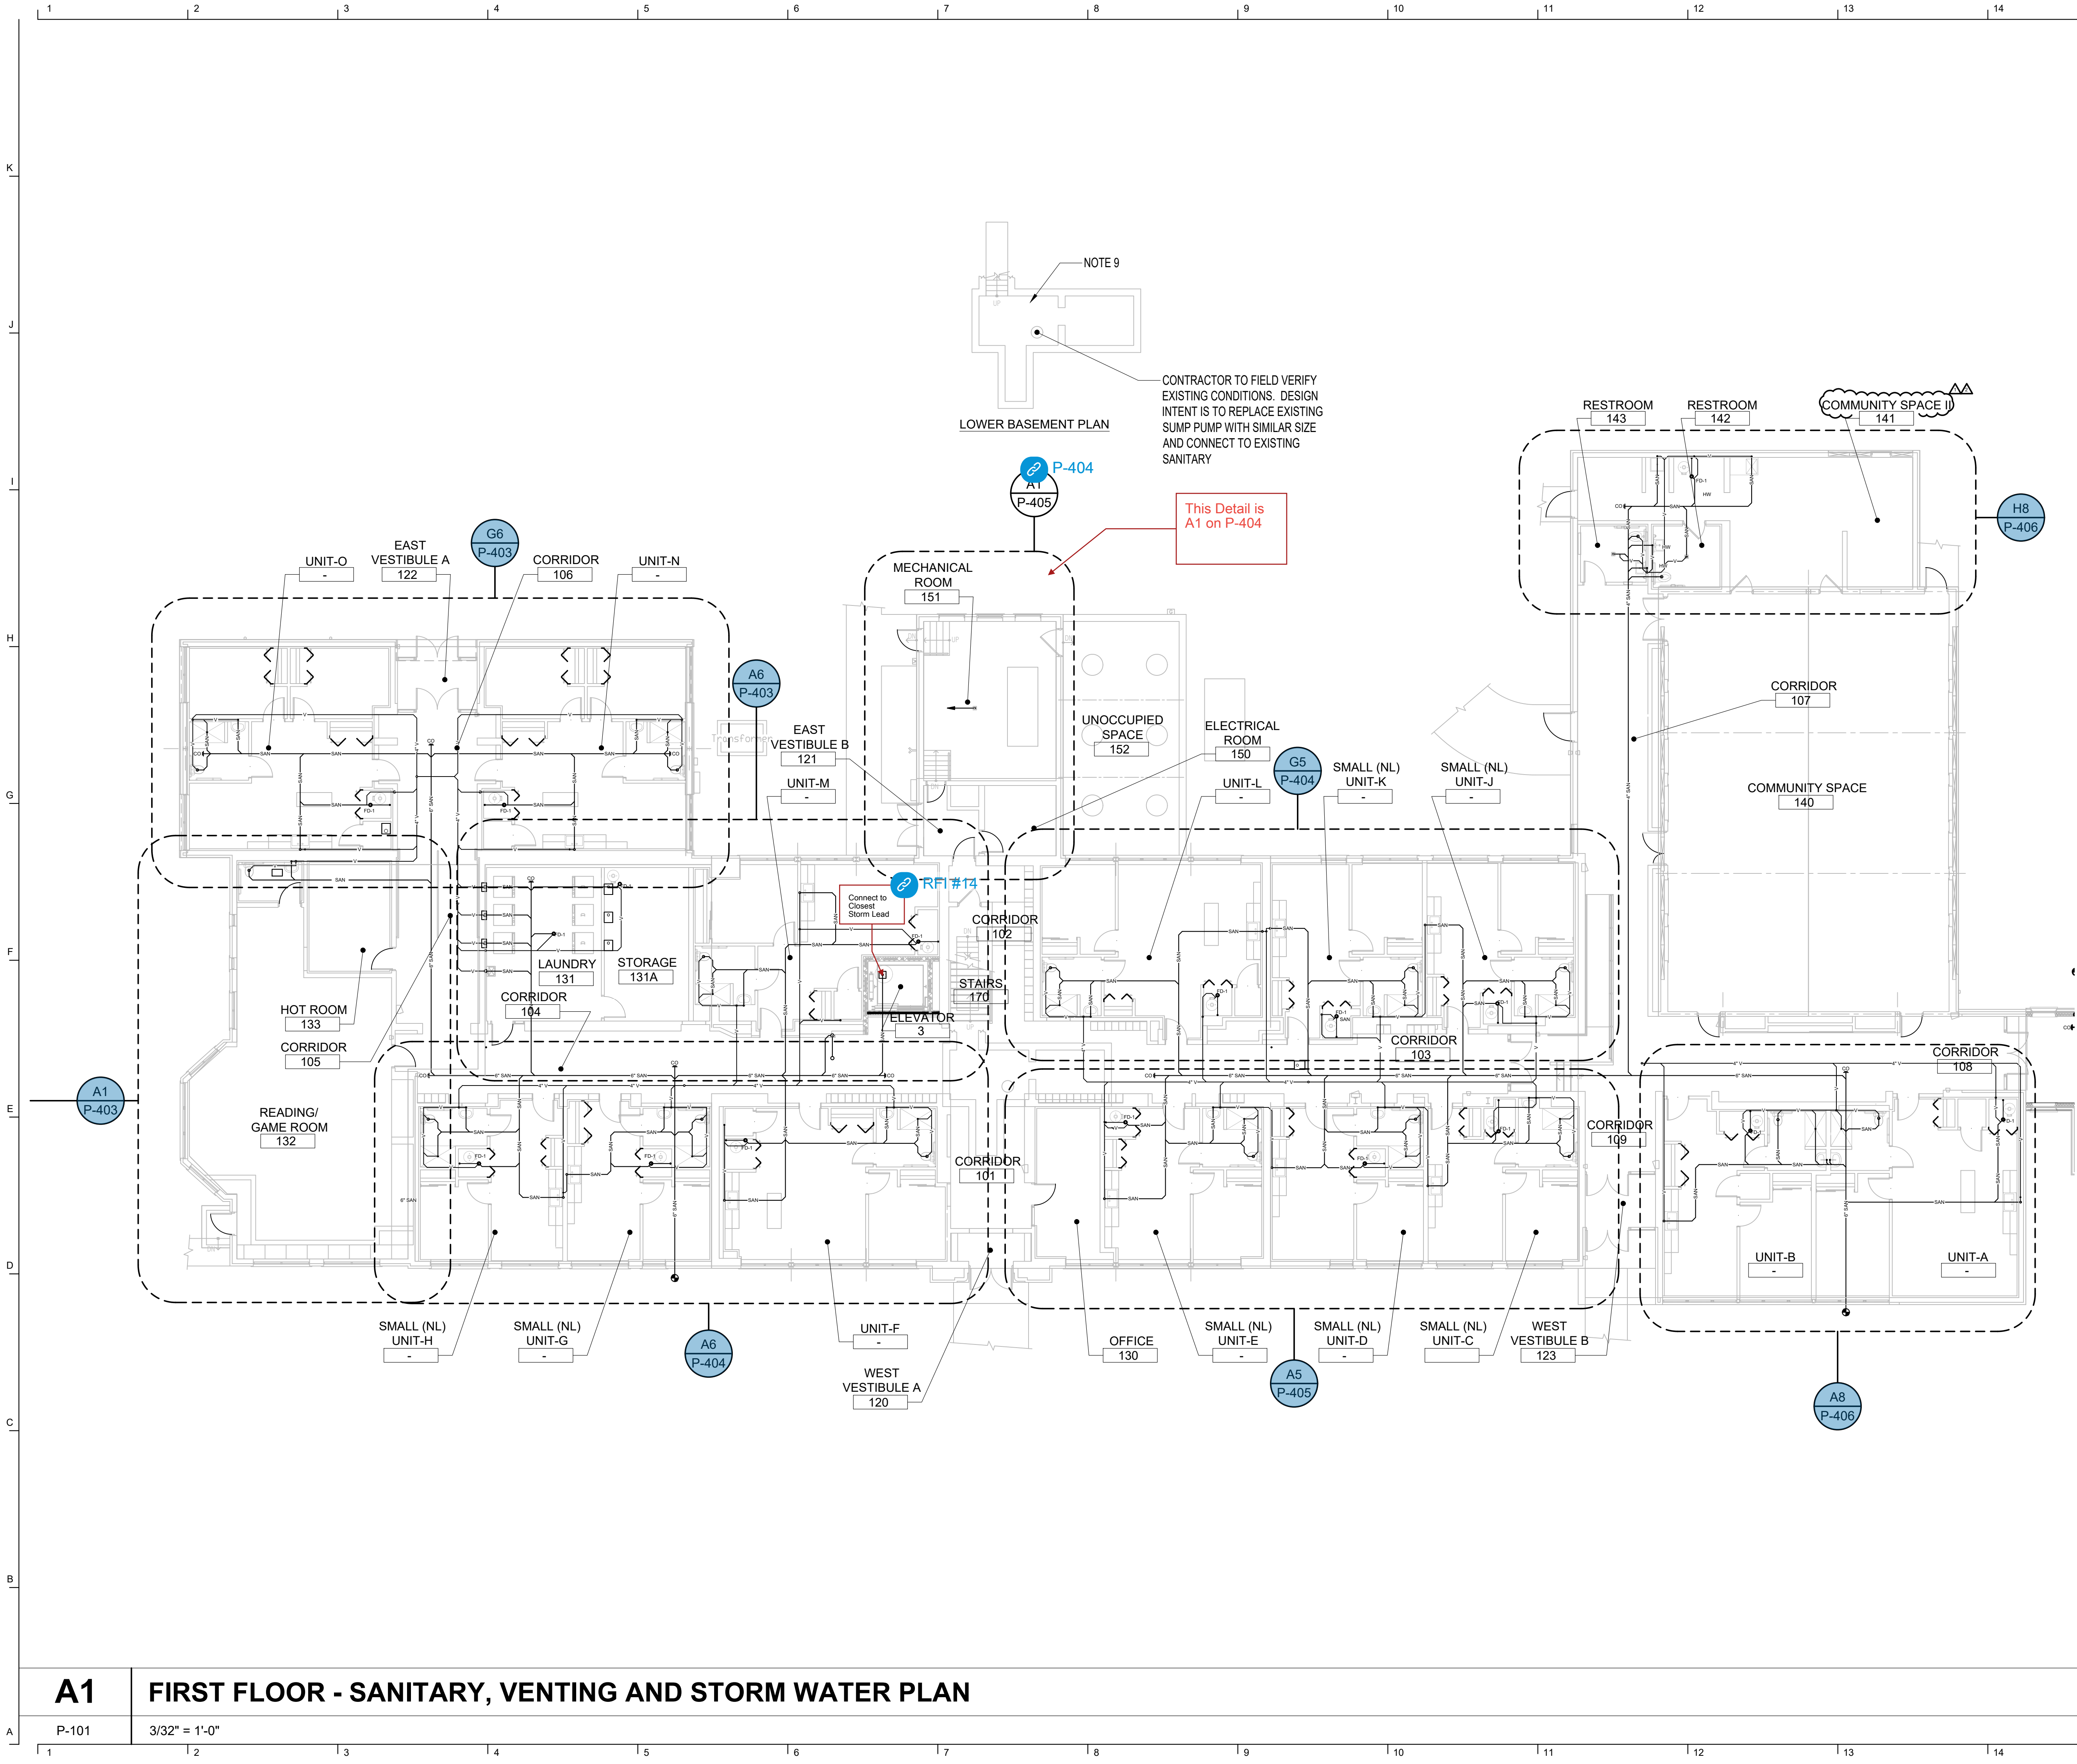

GENERAL

1. SEE SHEET **P-001** FOR PLUMBING NOTES

PLUMBING SHEET KEYED NOTES:

1. EXTEND CONDENSATE DRAIN TO NEAREST FLOOR DRAIN IN WATER HEATER ROOM.
2. EXISTING NATURAL GAS METER AND REGULATOR BY UTILITY COMPANY. VERIFY EXISTING REGULATOR PRESSURE AND COORDINATE TO ENSURE PROPER PRESSURE IS PROVIDE FOR SERVICE TO NATURAL GAS GENERATOR.
3. VENT UP AND DOWN
4. SANITARY UP AND DOWN AND PROVIDE VERTICAL CLEANOUT.
5. REFER TO TYPICAL APARTMENT WATER RISER DIAGRAM FOR PIPING ARRANGEMENT AND SIZES.
6. CONTRACTOR TO CONTACT MISS DIG PRIOR TO START OF ANY UNDERGROUND WORK, COORDINATE WORK WITH CIVIL PLANS.
7. HEAT PUMP HOT WATER, REFER TO MANUFACTURER DRAWINGS FOR PROPER VENTILATION REQUIREMENTS FOR DOOR CLEARANCES AND SPACE REQUIREMENTS. REFER TO PLUMBING DETAILS FOR HEAT PUMP WATER HEATER PIPING AND EQUIPMENT REQUIRED.
8. GARBAGE DISPOSAL, SEE PLUMBING SCHEDULE FOR SPECIFICATIONS AND INSTALL FOR MANUFACTURER REQUIREMENTS. TO BE CONTROLLED BY SWITCH LOCATED ABOVE COUNTER SEE ELECTRICAL.
9. ALL SANITARY LINES ARE BELOW FLOOR ELEVATION TO ALLOW FOR PROPER PITCH AND NEEDED FLOW. EXACT LOCATION OF TUNNEL AND BASEMENT ARE UNKNOWN AND SANITARY COULD BE IN BASEMENT OR TUNNEL. ROUTE IN A WAY TO MINIMIZE CORING. ALL VENTING AND WATER DISTRIBUTION ABOVE FINISH CEILING AS HIGH AS POSSIBLE WITHOUT INTERFERING WITH OTHER TRADES.
10. IF UNIT IS CONSIDERED ADA SUBSTITUTE FIXTURES TO ADA TYPE. COORDINATE WITH ARCH DRAWINGS.
11. DISHWASHER - PROVIDE HOT WATER

John Grace Arms
21030 Indian St, Southfield MI 48033
Developed by
John Grace Arms LDHA LLC

SDG
Architects + Planners
607 Shelby Street
Suite 704
Detroit, MI 48226
Tel: 313-961-0000
Fax: 313-964-3233

A & A Engineering & Consulting
28862 Vista Way, South Lyon, MI 48178

REGISTRATION SEAL



KEY PLANS

SHEET TITLE
**FIRST FLOOR -
SANITARY, VENTING
AND STORM WATER
PLAN**

SCALE: AS NOTED

ISSUED FOR	DATE
PERMIT	10.20.24
△ BULLETIN 3	05.19.25
△ BULLETIN 4	07.01.25

DRAWN BY

CHECKED

APPROVED

FILE NO.

SHEET NO.


A1 FIRST FLOOR - SANITARY, VENTING AND STORM WATER PLAN

P-101 3/32" = 1'-0"

21026.00

P-101

12/19/2024 6:28:32 PM

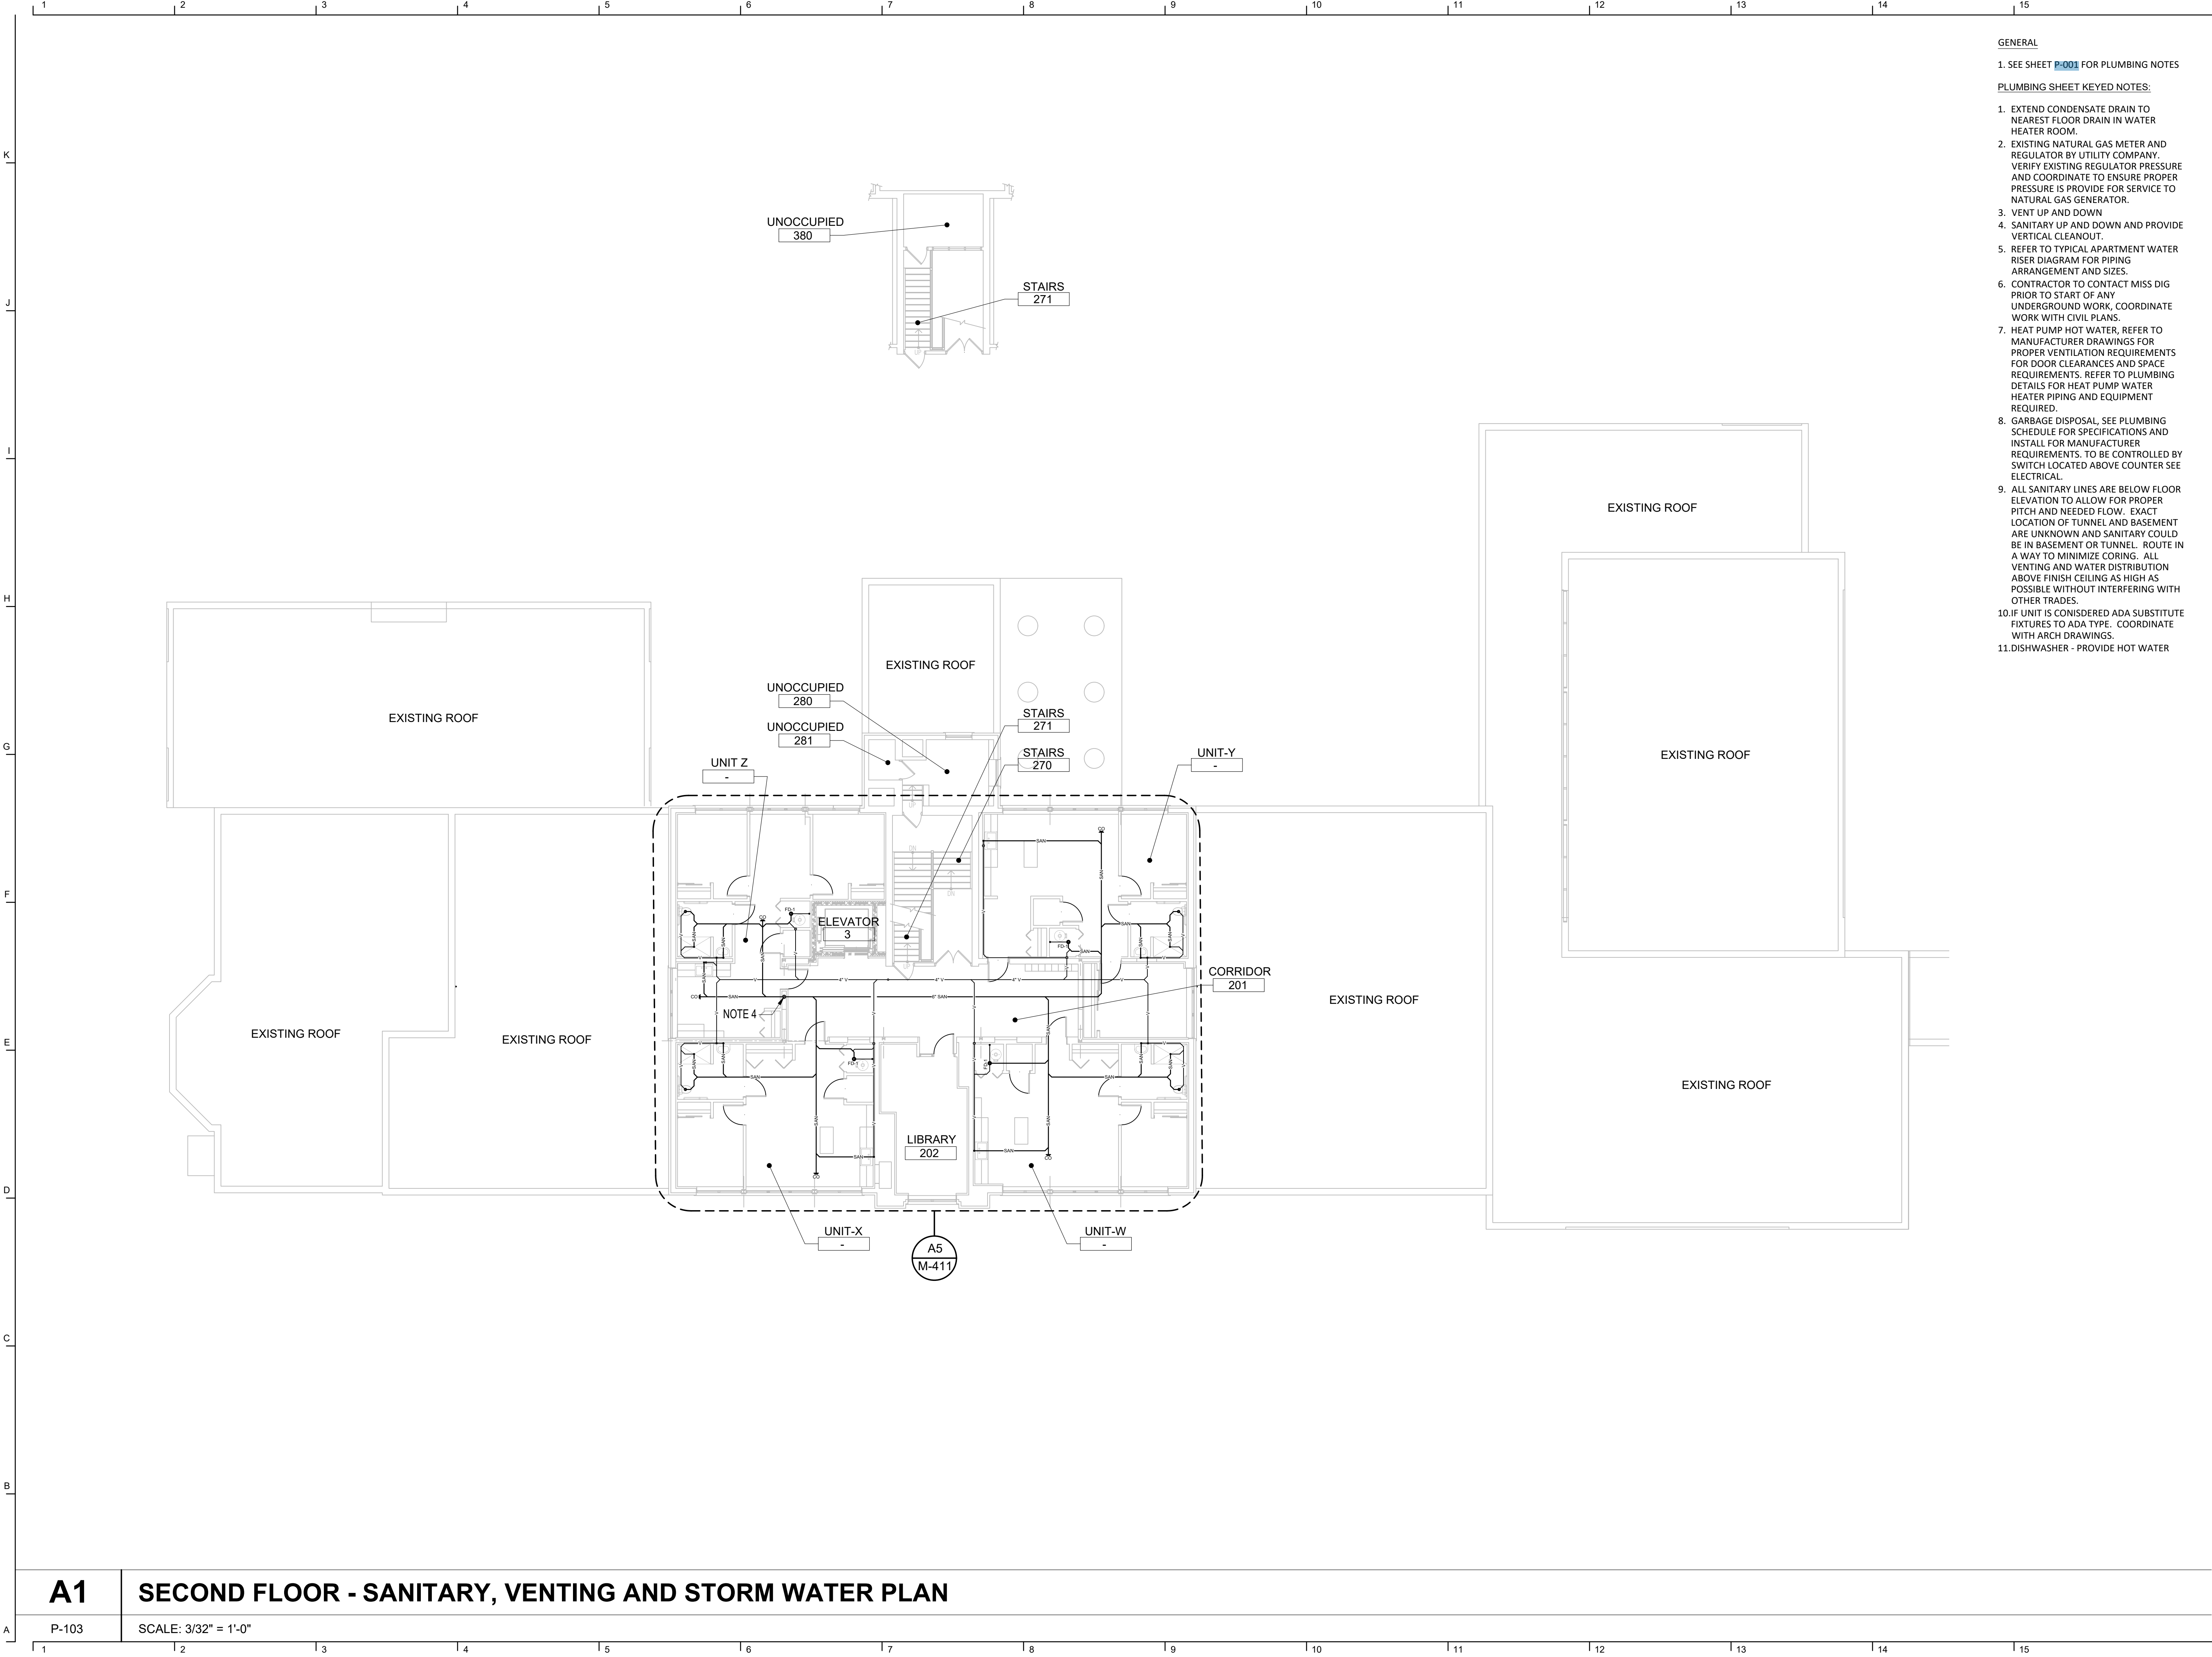

GENERAL

1. SEE SHEET [P-001](#) FOR PLUMBING NOTES

PLUMBING SHEET KEYED NOTES:

1. EXTEND CONDENSATE DRAIN TO NEAREST FLOOR DRAIN IN WATER HEATER ROOM.
2. EXISTING NATURAL GAS METER AND REGULATOR BY UTILITY COMPANY. VERIFY EXISTING REGULATOR PRESSURE AND COORDINATE TO ENSURE PROPER PRESSURE IS PROVIDE FOR SERVICE TO NATURAL GAS GENERATOR.
3. VENT UP AND DOWN
4. SANITARY UP AND DOWN AND PROVIDE VERTICAL CLEANOUT.
5. REFER TO TYPICAL APARTMENT WATER RISER DIAGRAM FOR PIPING ARRANGEMENT AND SIZES.
6. CONTRACTOR TO CONTACT MISS DIG PRIOR TO START OF ANY UNDERGROUND WORK, COORDINATE WORK WITH CIVIL PLANS.
7. HEAT PUMP HOT WATER, REFER TO MANUFACTURER DRAWINGS FOR PROPER VENTILATION REQUIREMENTS FOR DOOR CLEARANCES AND SPACE REQUIREMENTS. REFER TO PLUMBING DETAILS FOR HEAT PUMP WATER HEATER PIPING AND EQUIPMENT REQUIRED.
8. GARBAGE DISPOSAL, SEE PLUMBING SCHEDULE FOR SPECIFICATIONS AND INSTALL FOR MANUFACTURER REQUIREMENTS. TO BE CONTROLLED BY SWITCH LOCATED ABOVE COUNTER SEE ELECTRICAL.
9. ALL SANITARY LINES ARE BELOW FLOOR ELEVATION TO ALLOW FOR PROPER PITCH AND NEEDED FLOW. EXACT LOCATION OF TUNNEL AND BASEMENT ARE UNKNOWN AND SANITARY COULD BE IN BASEMENT OR TUNNEL. ROUTE IN A WAY TO MINIMIZE CORING. ALL VENTING AND WATER DISTRIBUTION ABOVE FINISH CEILING AS HIGH AS POSSIBLE WITHOUT INTERFERING WITH OTHER TRADES.
10. IF UNIT IS CONSIDERED ADA SUBSTITUTE FIXTURES TO ADA TYPE. COORDINATE WITH ARCH DRAWINGS.
11. DISHWASHER - PROVIDE HOT WATER

John Grace Arms
21030 Indian St, Southfield MI 48033
Developed by
John Grace Arms LDHA LLC

SDG
Architects + Planners
607 Shelby Street
Suite 704
Detroit, MI 48226
Tel: 313-961-0000
Fax: 313-964-3233


A & A Engineering & Consulting
28862 Vista Way, South Lyon, MI 48178

REGISTRATION SEAL



KEY PLANS

SHEET TITLE

**SECOND FLOOR
SANITARY, VENTING
AND STORM WATER
PLAN**

SCALE: AS NOTED

ISSUED FOR
PERMIT

DATE
10.20.24

DRAWN BY

CHECKED

APPROVED

21026.00

FILE NO.

P-103

SHEET NO.


A1

SECOND FLOOR - SANITARY, VENTING AND STORM WATER PLAN

P-103

SCALE: 3/32" = 1'-0"

12/19/2024 6:27:52 PM

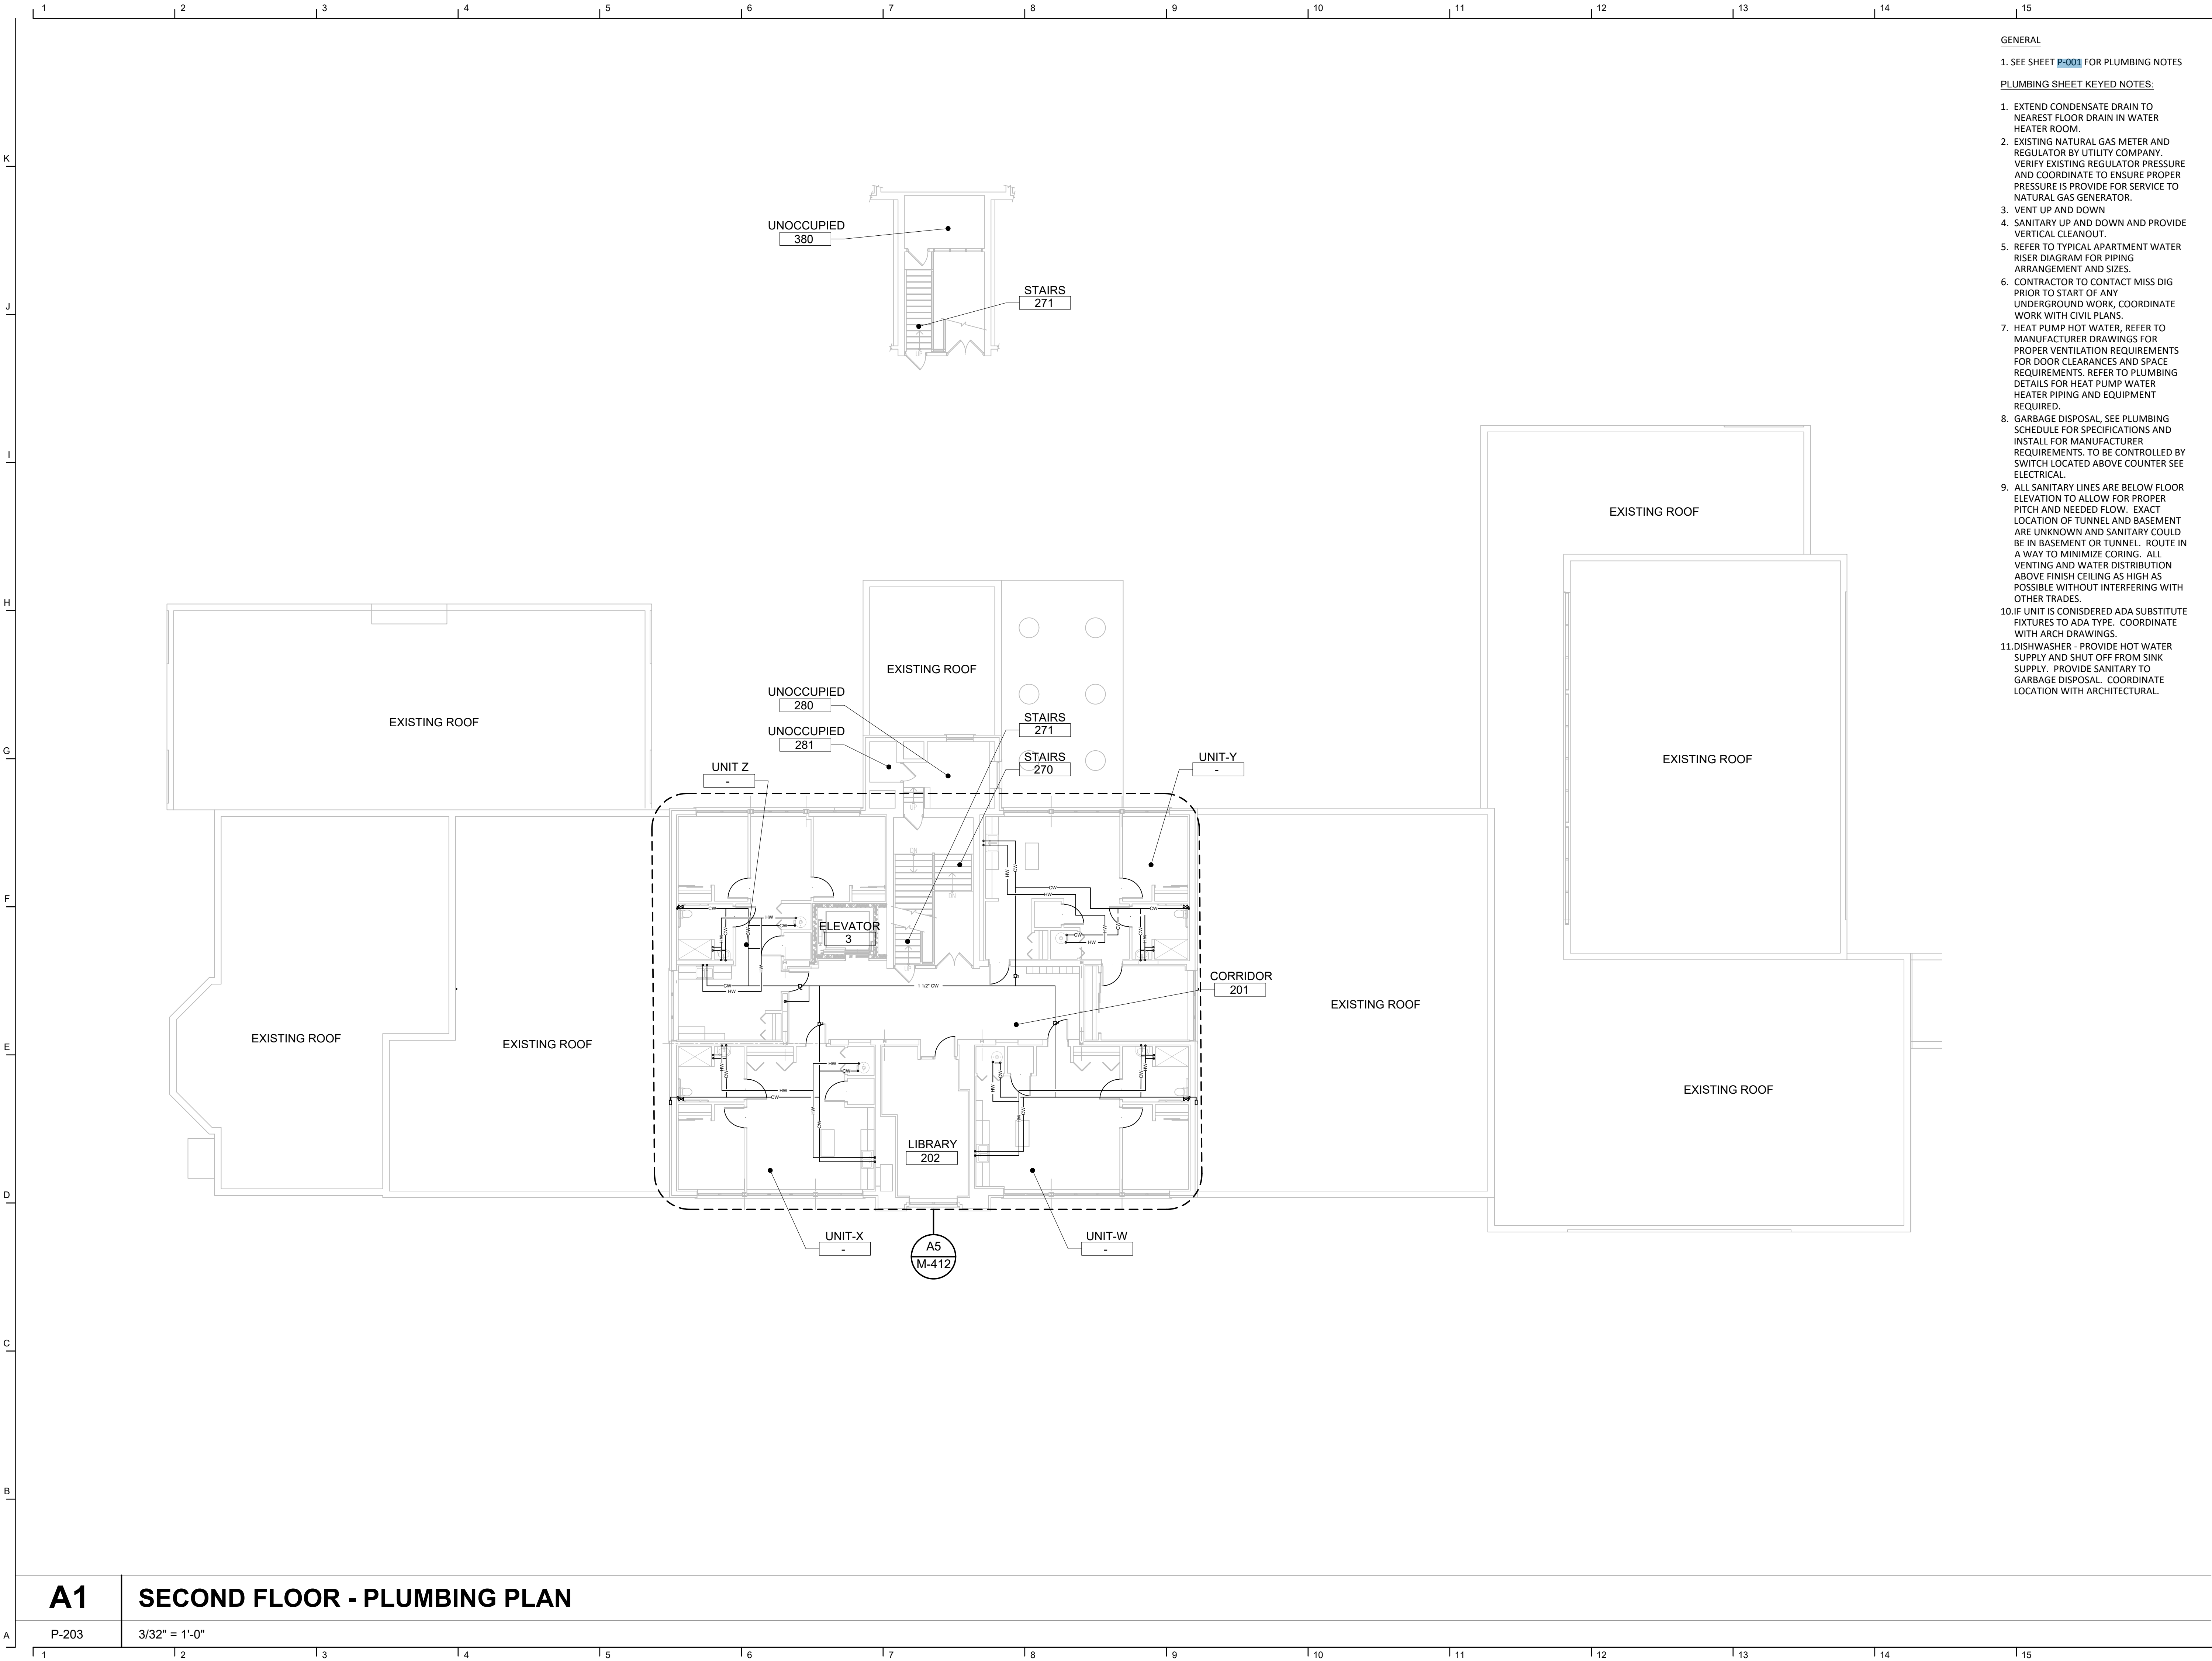

GENERAL

1. SEE SHEET [P-001](#) FOR PLUMBING NOTES

PLUMBING SHEET KEYED NOTES:

1. EXTEND CONDENSATE DRAIN TO NEAREST FLOOR DRAIN IN WATER HEATER ROOM.
2. EXISTING NATURAL GAS METER AND REGULATOR BY UTILITY COMPANY. VERIFY EXISTING REGULATOR PRESSURE AND COORDINATE TO ENSURE PROPER PRESSURE IS PROVIDE FOR SERVICE TO NATURAL GAS GENERATOR.
3. VENT UP AND DOWN
4. SANITARY UP AND DOWN AND PROVIDE VERTICAL CLEANOUT.
5. REFER TO TYPICAL APARTMENT WATER RISER DIAGRAM FOR PIPING ARRANGEMENT AND SIZES.
6. CONTRACTOR TO CONTACT MISS DIG PRIOR TO START OF ANY UNDERGROUND WORK, COORDINATE WORK WITH CIVIL PLANS.
7. HEAT PUMP HOT WATER. REFER TO MANUFACTURER DRAWINGS FOR PROPER VENTILATION REQUIREMENTS FOR DOOR CLEARANCES AND SPACE REQUIREMENTS. REFER TO PLUMBING DETAILS FOR HEAT PUMP WATER HEATER PIPING AND EQUIPMENT REQUIRED.
8. GARBAGE DISPOSAL, SEE PLUMBING SCHEDULE FOR SPECIFICATIONS AND INSTALL FOR MANUFACTURER REQUIREMENTS. TO BE CONTROLLED BY SWITCH LOCATED ABOVE COUNTER SEE ELECTRICAL.
9. ALL SANITARY LINES ARE BELOW FLOOR ELEVATION TO ALLOW FOR PROPER PITCH AND NEEDED FLOW. EXACT LOCATION OF TUNNEL AND BASEMENT ARE UNKNOWN AND SANITARY COULD BE IN BASEMENT OR TUNNEL. ROUTE IN A WAY TO MINIMIZE CORING. ALL VENTING AND WATER DISTRIBUTION ABOVE FINISH CEILING AS HIGH AS POSSIBLE WITHOUT INTERFERING WITH OTHER TRADES.
10. IF UNIT IS CONSIDERED ADA SUBSTITUTE FIXTURES TO ADA TYPE. COORDINATE WITH ARCH DRAWINGS.
11. DISHWASHER - PROVIDE HOT WATER SUPPLY AND SHUT OFF FROM SINK SUPPLY. PROVIDE SANITARY TO GARBAGE DISPOSAL. COORDINATE LOCATION WITH ARCHITECTURAL.

John Grace Arms
21030 Indian St, Southfield MI 48033
Developed by
John Grace Arms LDHA LLC

SDG
Architects + Planners
607 Shelby Street
Suite 704
Detroit, MI 48226
Tel: 313-961-0000
Fax: 313-964-3233


A & A Engineering & Consulting
28862 Vista Way, South Lyon, MI 48178

REGISTRATION SEAL



KEY PLANS

SHEET TITLE
**SECOND FLOOR -
PLUMBING PLAN**

SCALE: AS NOTED

ISSUED FOR
PERMIT

DATE
10.20.24

DRAWN BY

CHECKED

APPROVED

21026.00

FILE NO.
P-203


SHEET NO.

A1 **SECOND FLOOR - PLUMBING PLAN**

P-203 3/32" = 1'-0"


PASSIVE/ACTIVE RADON LOCATION MAP

TUNNEL DIMENSIONS			
LOCATION	LENGTH	WIDTH	HEIGHT
A1	31' - 8"	5'-0"	VARIES (2'-5" TO 3'-1")
A2	31' - 8"	5'-1"	VARIES (1'-11" TO 3'-1")
A3	31' - 8"	4' - 11"	VARIES (1'-11" TO 3'-1")
A4	31' - 8"	4'-9"	VARIES (1'-11" TO 2'-11")
A5	42'-3"	5'-5"	VARIES (1'-11" TO 3'-2")
A6	42'-3"	5' - 6"	VARIES (1'-11" TO 3'-2")
A7	42'-3"	4' - 8"	VARIES (2'-0" TO 3'-1")
A8	42'-3"	6' - 1"	VARIES (1'-11" TO 3'-1")
A9	42'-3"	5' - 3"	VARIES (1'-11" TO 3'-5")
A10	65' - 11"	4' - 10"	VARIES (1'-11" TO 3'-8")
A11	9' - 3"	2' - 0"	3' - 9"
A12	3' - 8"	2' - 0"	3' - 9"
B1	22' - 8"	11' - 6"	VARIES
B2	11' - 3"	7' - 8"	8' - 8"
B3	10' - 0"	7' - 8"	8' - 8"
C1	68' - 5"	4' - 2"	3' - 7"
C2	116' - 5"	4' - 2"	3' - 7"
C3	31' - 8"	3' - 7"	3' - 7"
C4	19' - 9"	4' - 0"	3' - 9"
C5	4' - 4"	3' - 7"	3' - 6"
C6	60' - 5"	3' - 5"	3' - 11"
C7	8' - 8"	3' - 7"	3' - 8"
C8	11' - 6"	4' - 2"	3' - 9"
C9	2' - 6"	4' - 1"	3' - 8"
C10	24' - 9"	4' - 0"	3' - 6"
C11	47' - 3"	4' - 1"	3' - 2"
D	~ 70'	VARIES 2' - 3" TO 5' - 0"	3' - 7"

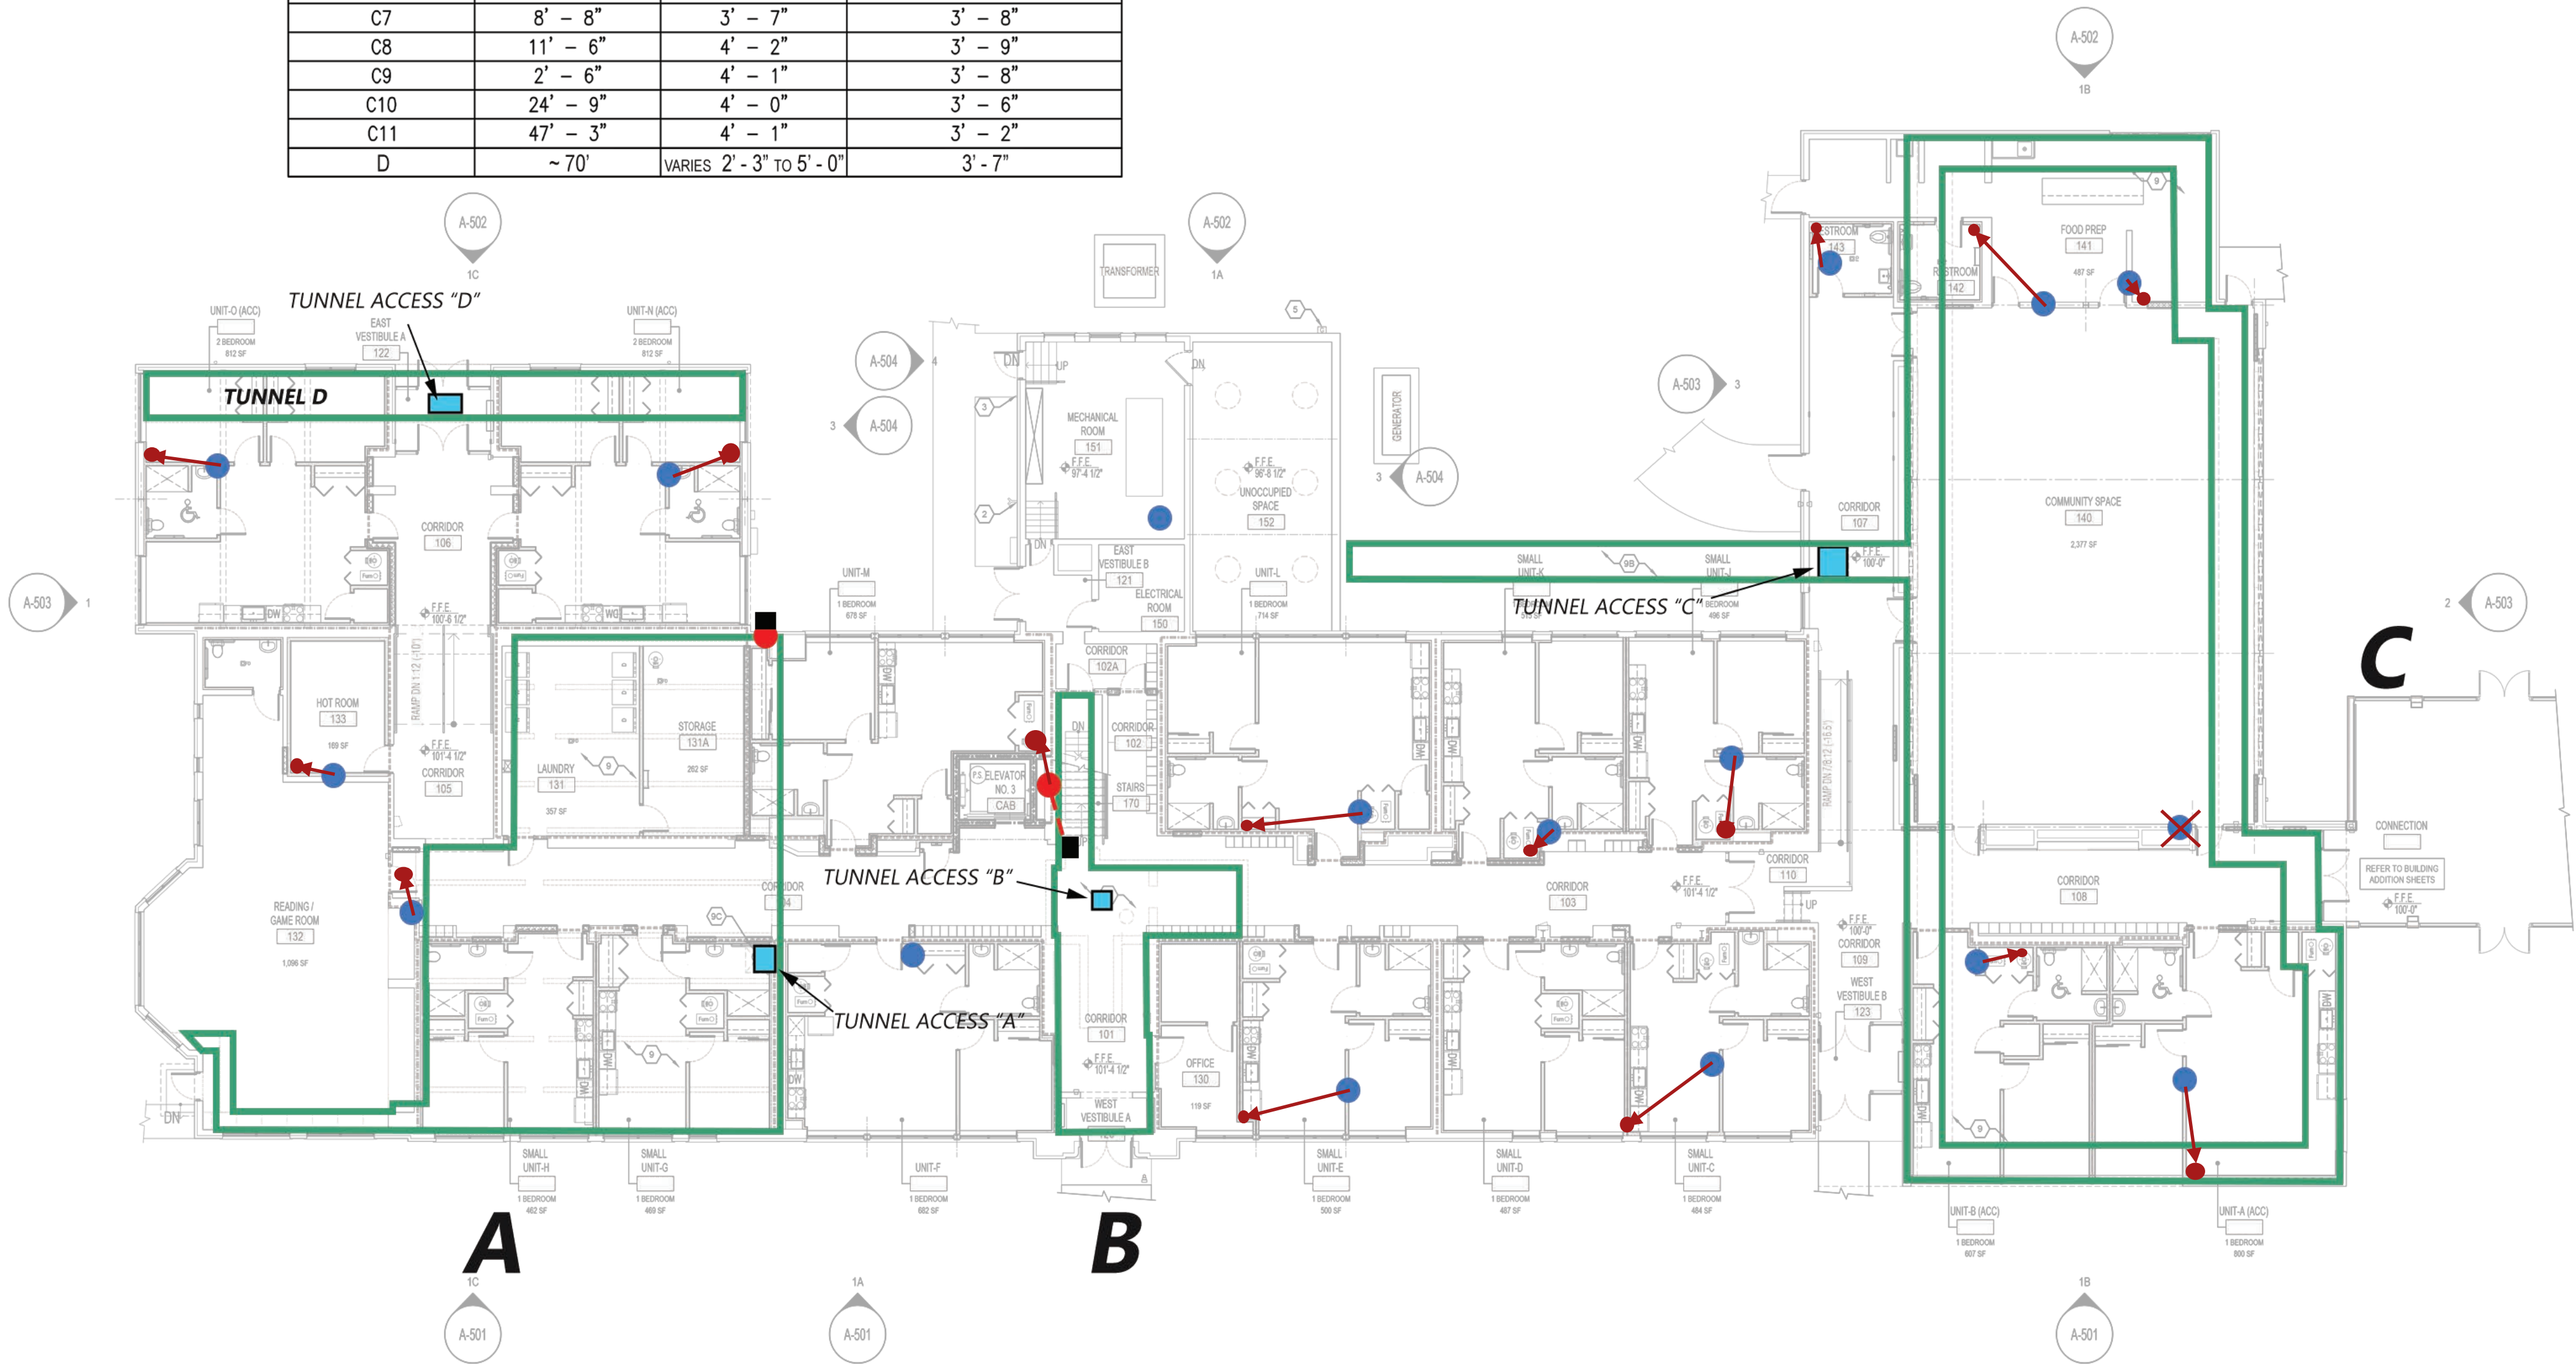

- LEGEND**
- PASSIVE RADON VENT
 - ACTIVE RADON VENT
 - T-CONNECT TO TUNNEL "B"
 - NEMA BOX WITH GAUGE
- NOTES:**
- ALL LOCATIONS APPROXIMATE
 - BASE DRAWING BY SDG ARCHITECTS & PLANNERS
 - MPK 11/11/24

12/19/2024 6:28:09 PM

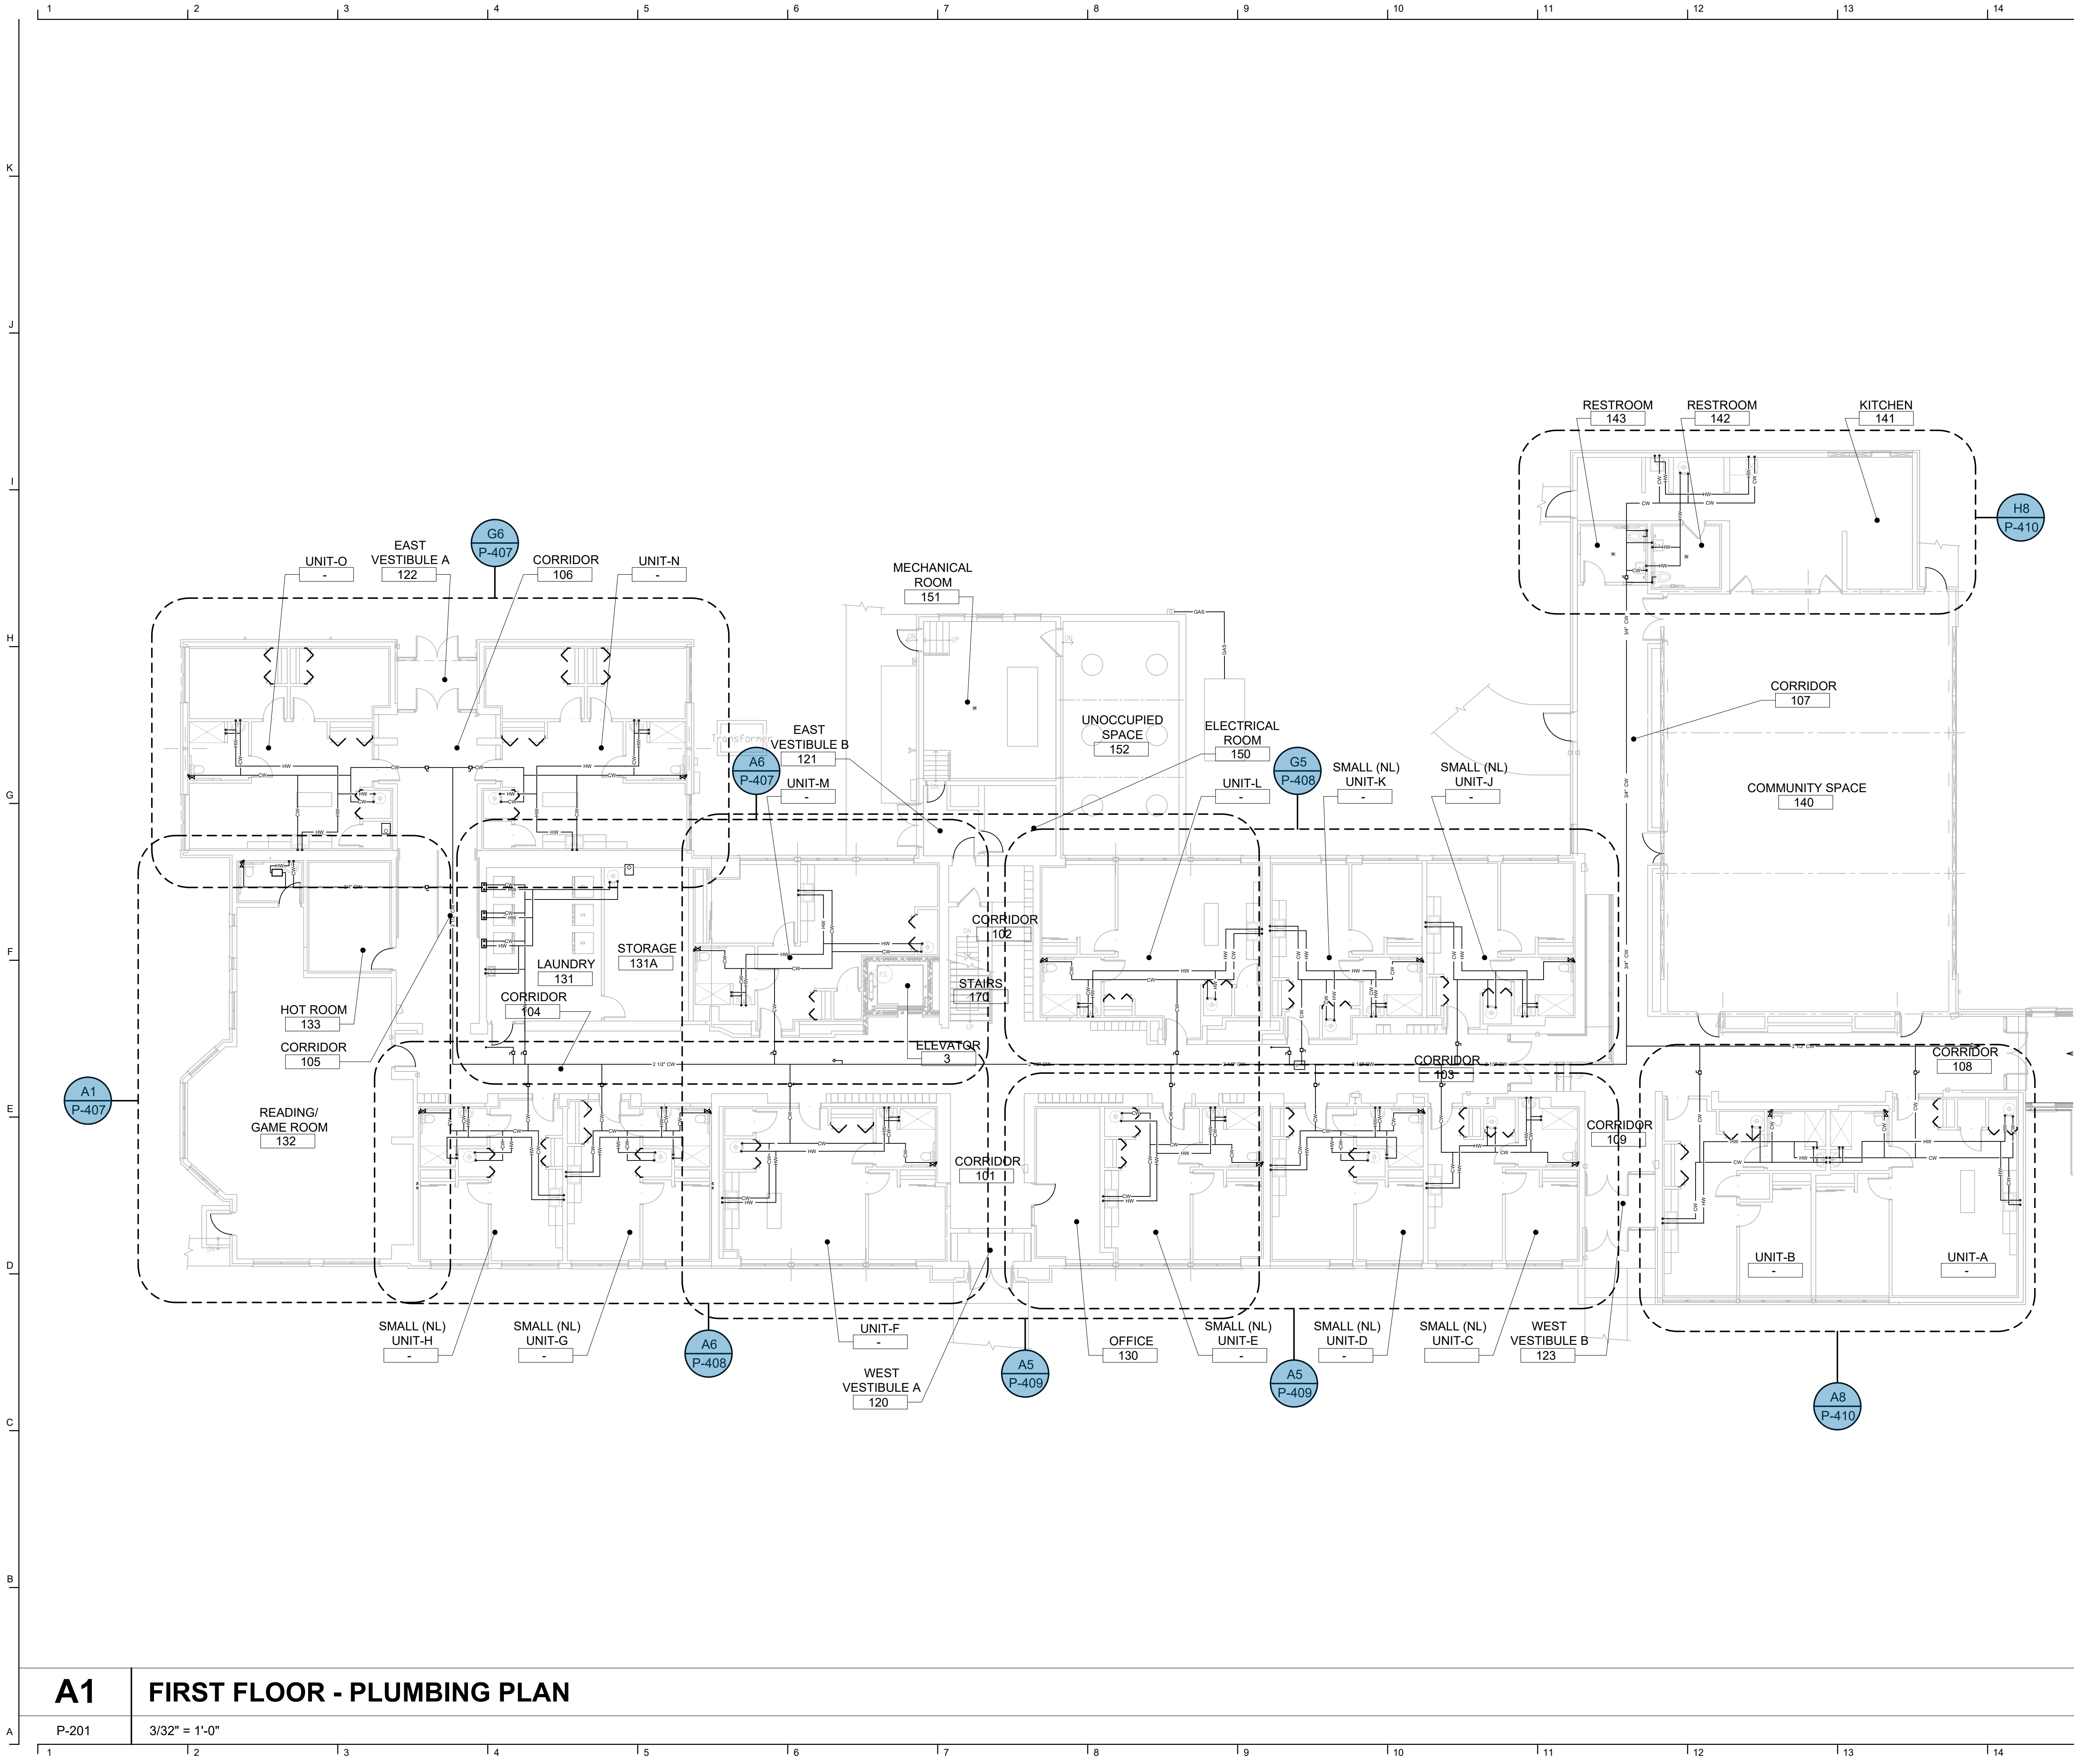

GENERAL

1. SEE SHEET P-001 FOR PLUMBING NOTES

PLUMBING SHEET KEYED NOTES:

- EXTEND CONDENSATE DRAIN TO NEAREST FLOOR DRAIN IN WATER HEATER ROOM.
- EXISTING NATURAL GAS METER AND REGULATOR BY UTILITY COMPANY. VERIFY EXISTING REGULATOR PRESSURE AND COORDINATE TO ENSURE PROPER PRESSURE IS PROVIDED FOR SERVICE TO NATURAL GAS GENERATOR.
- VENT UP AND DOWN
- SANITARY UP AND DOWN AND PROVIDE VERTICAL CLEANOUT.
- REFER TO TYPICAL APARTMENT WATER RISER DIAGRAM FOR PIPING ARRANGEMENT AND SIZES.
- CONTRACTOR TO CONTACT MISS DIG PRIOR TO START OF ANY UNDERGROUND WORK. COORDINATE WORK WITH CIVIL PLANS.
- HEAT PUMP HOT WATER, REFER TO MANUFACTURER DRAWINGS FOR PROPER VENTILATION REQUIREMENTS FOR DOOR CLEARANCES AND SPACE REQUIREMENTS. REFER TO PLUMBING DETAILS FOR HEAT PUMP WATER HEATER PIPING AND EQUIPMENT REQUIRED.
- GARBAGE DISPOSAL, SEE PLUMBING SCHEDULE FOR SPECIFICATIONS AND INSTALL FOR MANUFACTURER REQUIREMENTS. TO BE CONTROLLED BY SWITCH LOCATED ABOVE COUNTER SEE ELECTRICAL.
- ALL SANITARY LINES ARE BELOW FLOOR ELEVATION TO ALLOW FOR PROPER PITCH AND NEEDED FLOW. EXACT LOCATION OF TUNNEL AND BASEMENT ARE UNKNOWN AND SANITARY COULD BE IN BASEMENT OR TUNNEL. ROUTE IN A WAY TO MINIMIZE CORING. ALL VENTING AND WATER DISTRIBUTION ABOVE FINISH CEILING AS HIGH AS POSSIBLE WITHOUT INTERFERING WITH OTHER TRADES.
- IF UNIT IS CONSIDERED ADA SUBSTITUTE FIXTURES TO ADA TYPE. COORDINATE WITH ARCH DRAWINGS.
- DISHWASHER - PROVIDE HOT WATER SUPPLY AND SHUT OFF FROM SINK SUPPLY. PROVIDE SANITARY TO GARBAGE DISPOSAL. COORDINATE LOCATION WITH ARCHITECTURAL.

John Grace Arms
21030 Indian St, Southfield MI 48033
Developed by
John Grace Arms LDHA LLC

SDG
Architects + Planners
607 Shelby Street
Suite 704
Detroit, MI 48226
Tel: 313-961-0000
Fax: 313-964-3233

A & A Engineering & Consulting
28862 Vista Way, South Lyon, MI 48178

REGISTRATION SEAL



KEY PLANS

SHEET TITLE
**FIRST FLOOR
PLUMBING PLAN**

SCALE: AS NOTED

ISSUED FOR
PERMIT
DATE
10.20.24

DRAWN BY

CHECKED

APPROVED

21026.00


FILE NO.
P-201

SHEET NO.

A1 FIRST FLOOR - PLUMBING PLAN

P-201 3/32" = 1'-0"

12/19/2024 6:26:25 PM

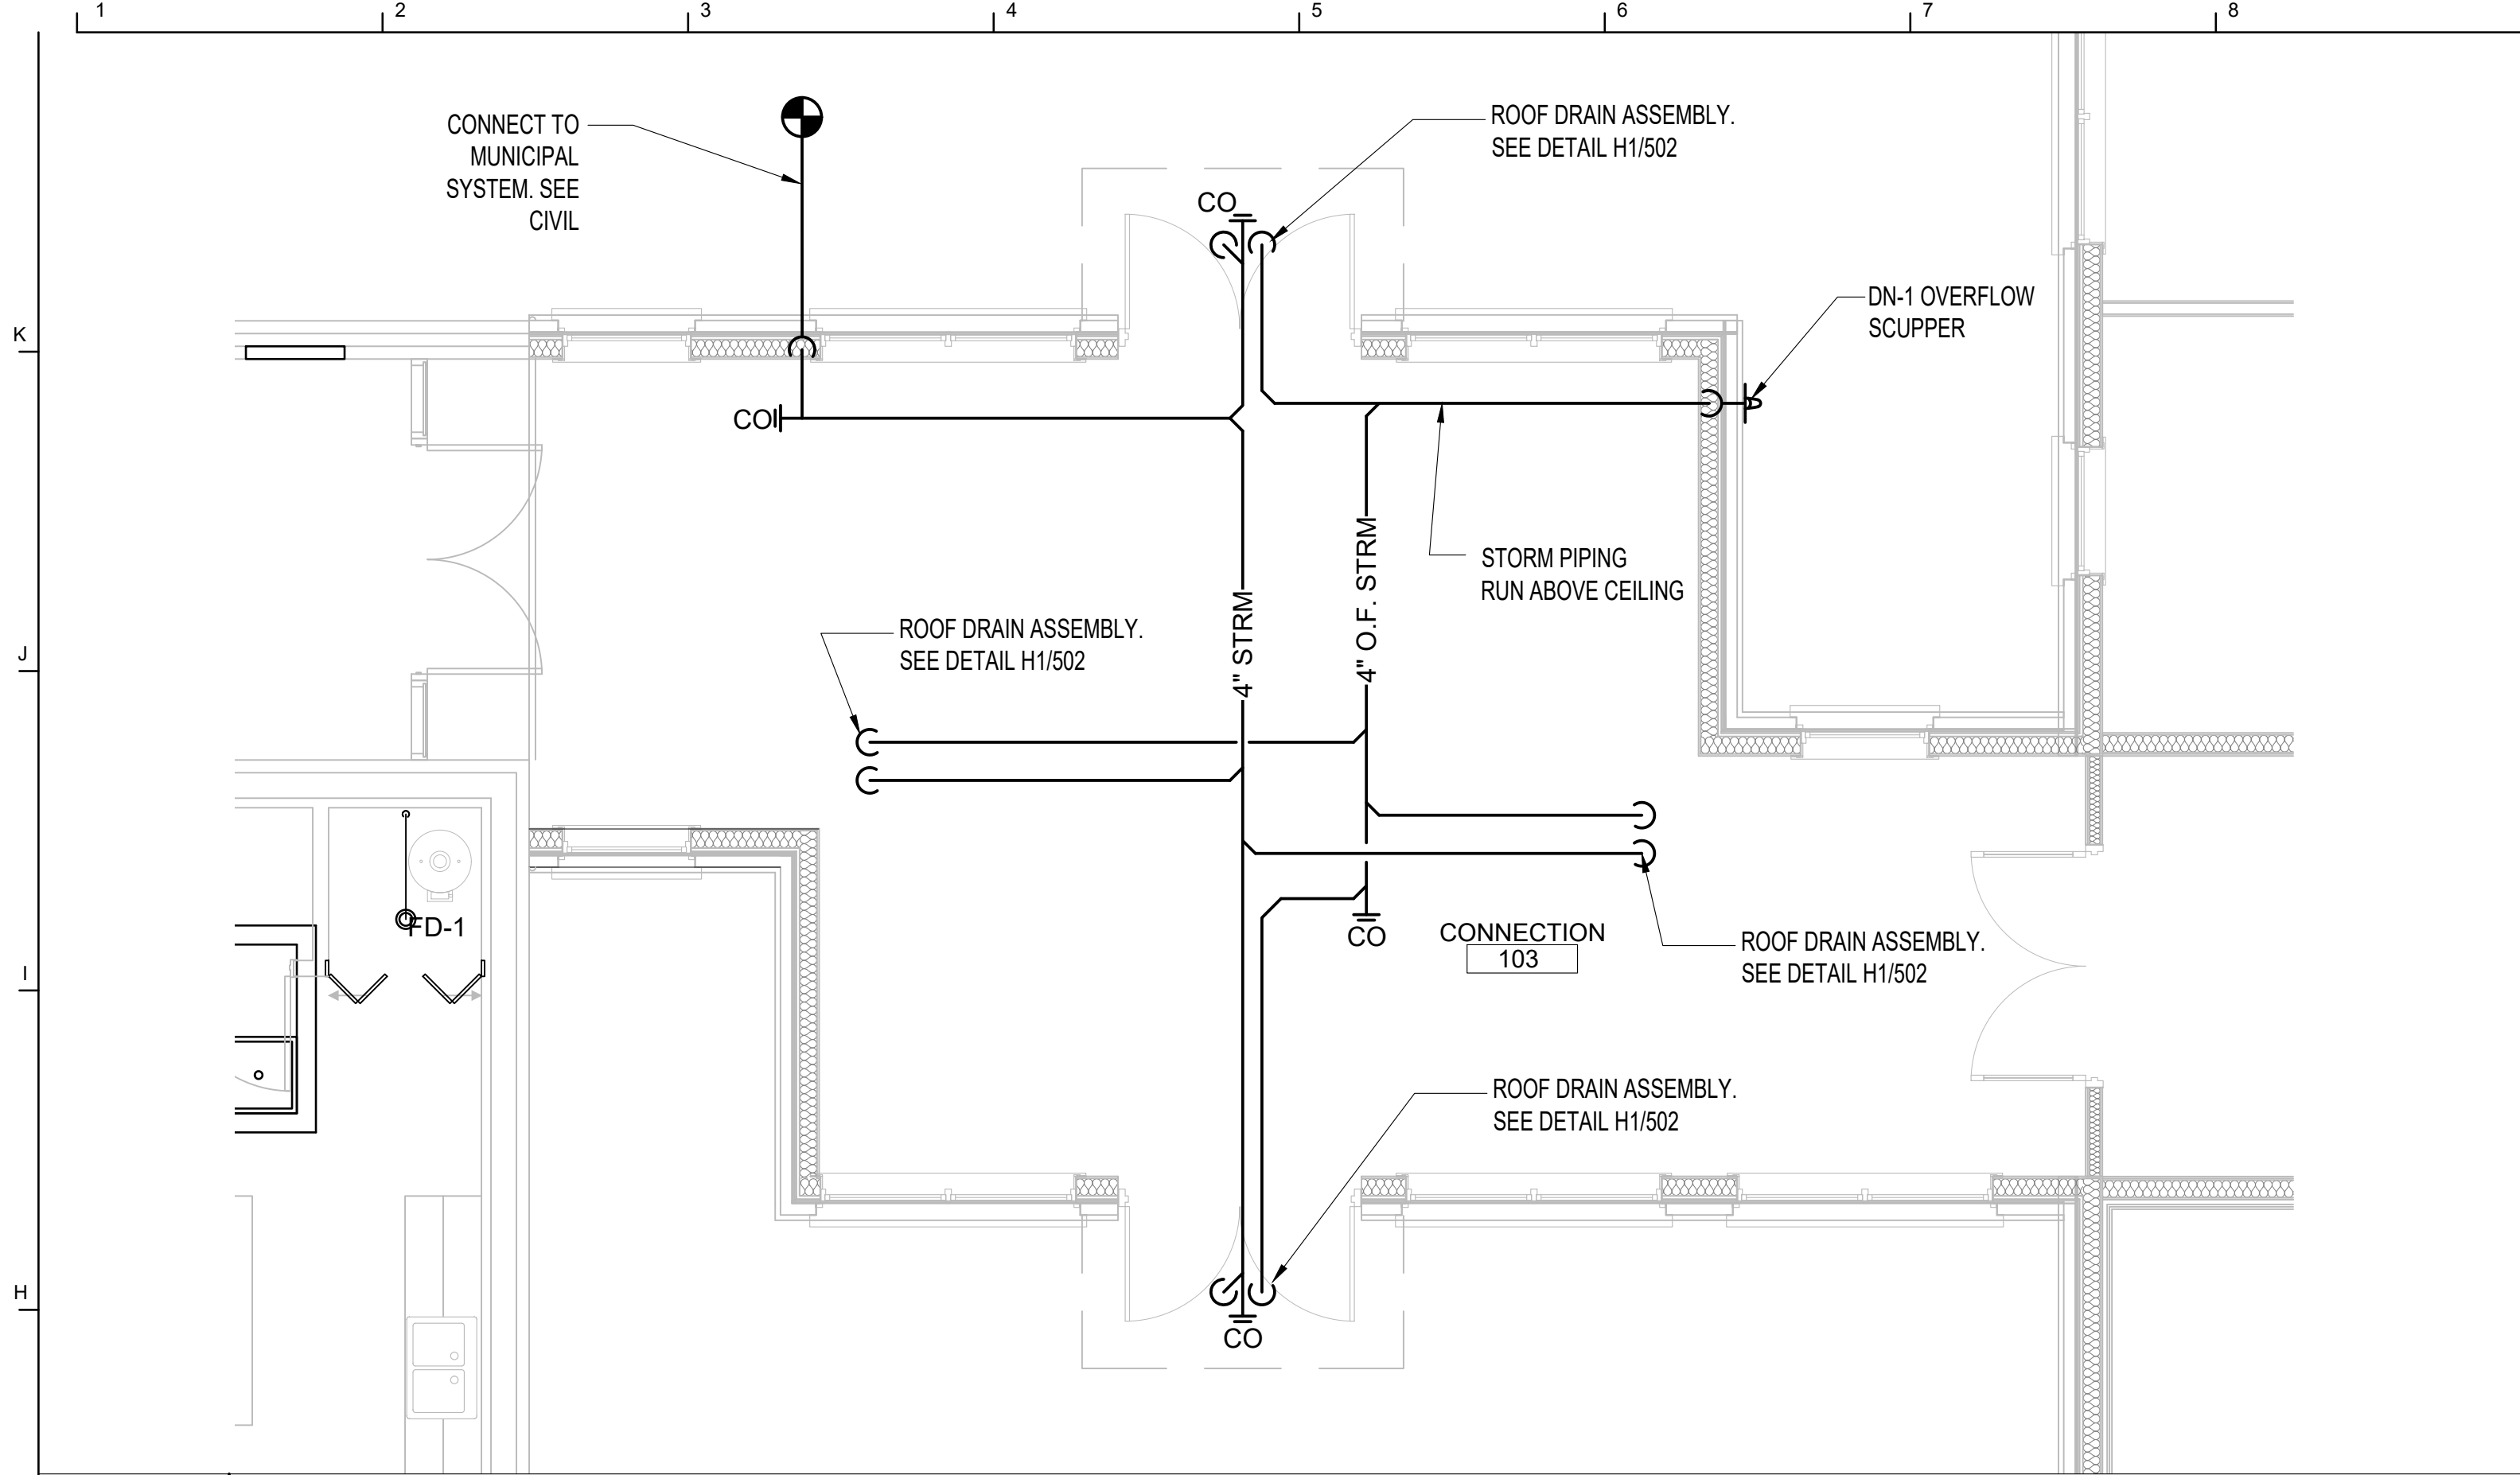

G1 CONNECTION 103 - STORM WATER PLAN

P-402 1/4" = 1'-0"

GENERAL

1. SEE SHEET **P-001** FOR PLUMBING NOTES

PLUMBING SHEET KEYED NOTES:

1. EXTEND CONDENSATE DRAIN TO NEAREST FLOOR DRAIN IN WATER HEATER ROOM.
2. EXISTING NATURAL GAS METER AND REGULATOR BY UTILITY COMPANY. VERIFY EXISTING REGULATOR PRESSURE AND COORDINATE TO ENSURE PROPER PRESSURE IS PROVIDE FOR SERVICE TO NATURAL GAS GENERATOR.
3. VENT UP AND DOWN
4. SANITARY UP AND DOWN AND PROVIDE VERTICAL CLEANOUT.
5. REFER TO TYPICAL APARTMENT WATER RISER DIAGRAM FOR PIPING ARRANGEMENT AND SIZES.
6. CONTRACTOR TO CONTACT MISS DIG PRIOR TO START OF ANY UNDERGROUND WORK, COORDINATE WORK WITH CIVIL PLANS.
7. HEAT PUMP HOT WATER, REFER TO MANUFACTURER DRAWINGS FOR PROPER VENTILATION REQUIREMENTS FOR DOOR CLEARANCES AND SPACE REQUIREMENTS. REFER TO PLUMBING DETAILS FOR HEAT PUMP WATER HEATER PIPING AND EQUIPMENT REQUIRED.
8. GARBAGE DISPOSAL, SEE PLUMBING SCHEDULE FOR SPECIFICATIONS AND INSTALL FOR MANUFACTURER REQUIREMENTS. TO BE CONTROLLED BY SWITCH LOCATED ABOVE COUNTER SEE ELECTRICAL.
9. ALL SANITARY LINES ARE BELOW FLOOR ELEVATION TO ALLOW FOR PROPER PITCH AND NEEDED FLOW. EXACT LOCATION OF TUNNEL AND BASEMENT ARE UNKNOWN AND SANITARY COULD BE IN BASEMENT OR TUNNEL. ROUTE IN A WAY TO MINIMIZE CORING. ALL VENTING AND WATER DISTRIBUTION ABOVE FINISH CEILING AS HIGH AS POSSIBLE WITHOUT INTERFERING WITH OTHER TRADES.
10. IF UNIT IS CONSIDERED ADA SUBSTITUTE FIXTURES TO ADA TYPE. COORDINATE WITH ARCH DRAWINGS.
11. DISHWASHER - PROVIDE HOT WATER SUPPLY AND SHUT OFF FROM SINK SUPPLY. PROVIDE SANITARY TO GARBAGE DISPOSAL. COORDINATE LOCATION WITH ARCHITECTURAL.

John Grace Arms
21030 Indian St, Southfield MI 48033
Developed by
John Grace Arms LDHA LLC

SDG
Architects + Planners
607 Shelby Street
Suite 704
Detroit, MI 48226
Tel: 313-961-0000
Fax: 313-964-3233




A & A Engineering & Consulting
28862 Vista Way, South Lyon, MI 48178

REGISTRATION SEAL




KEY PLANS

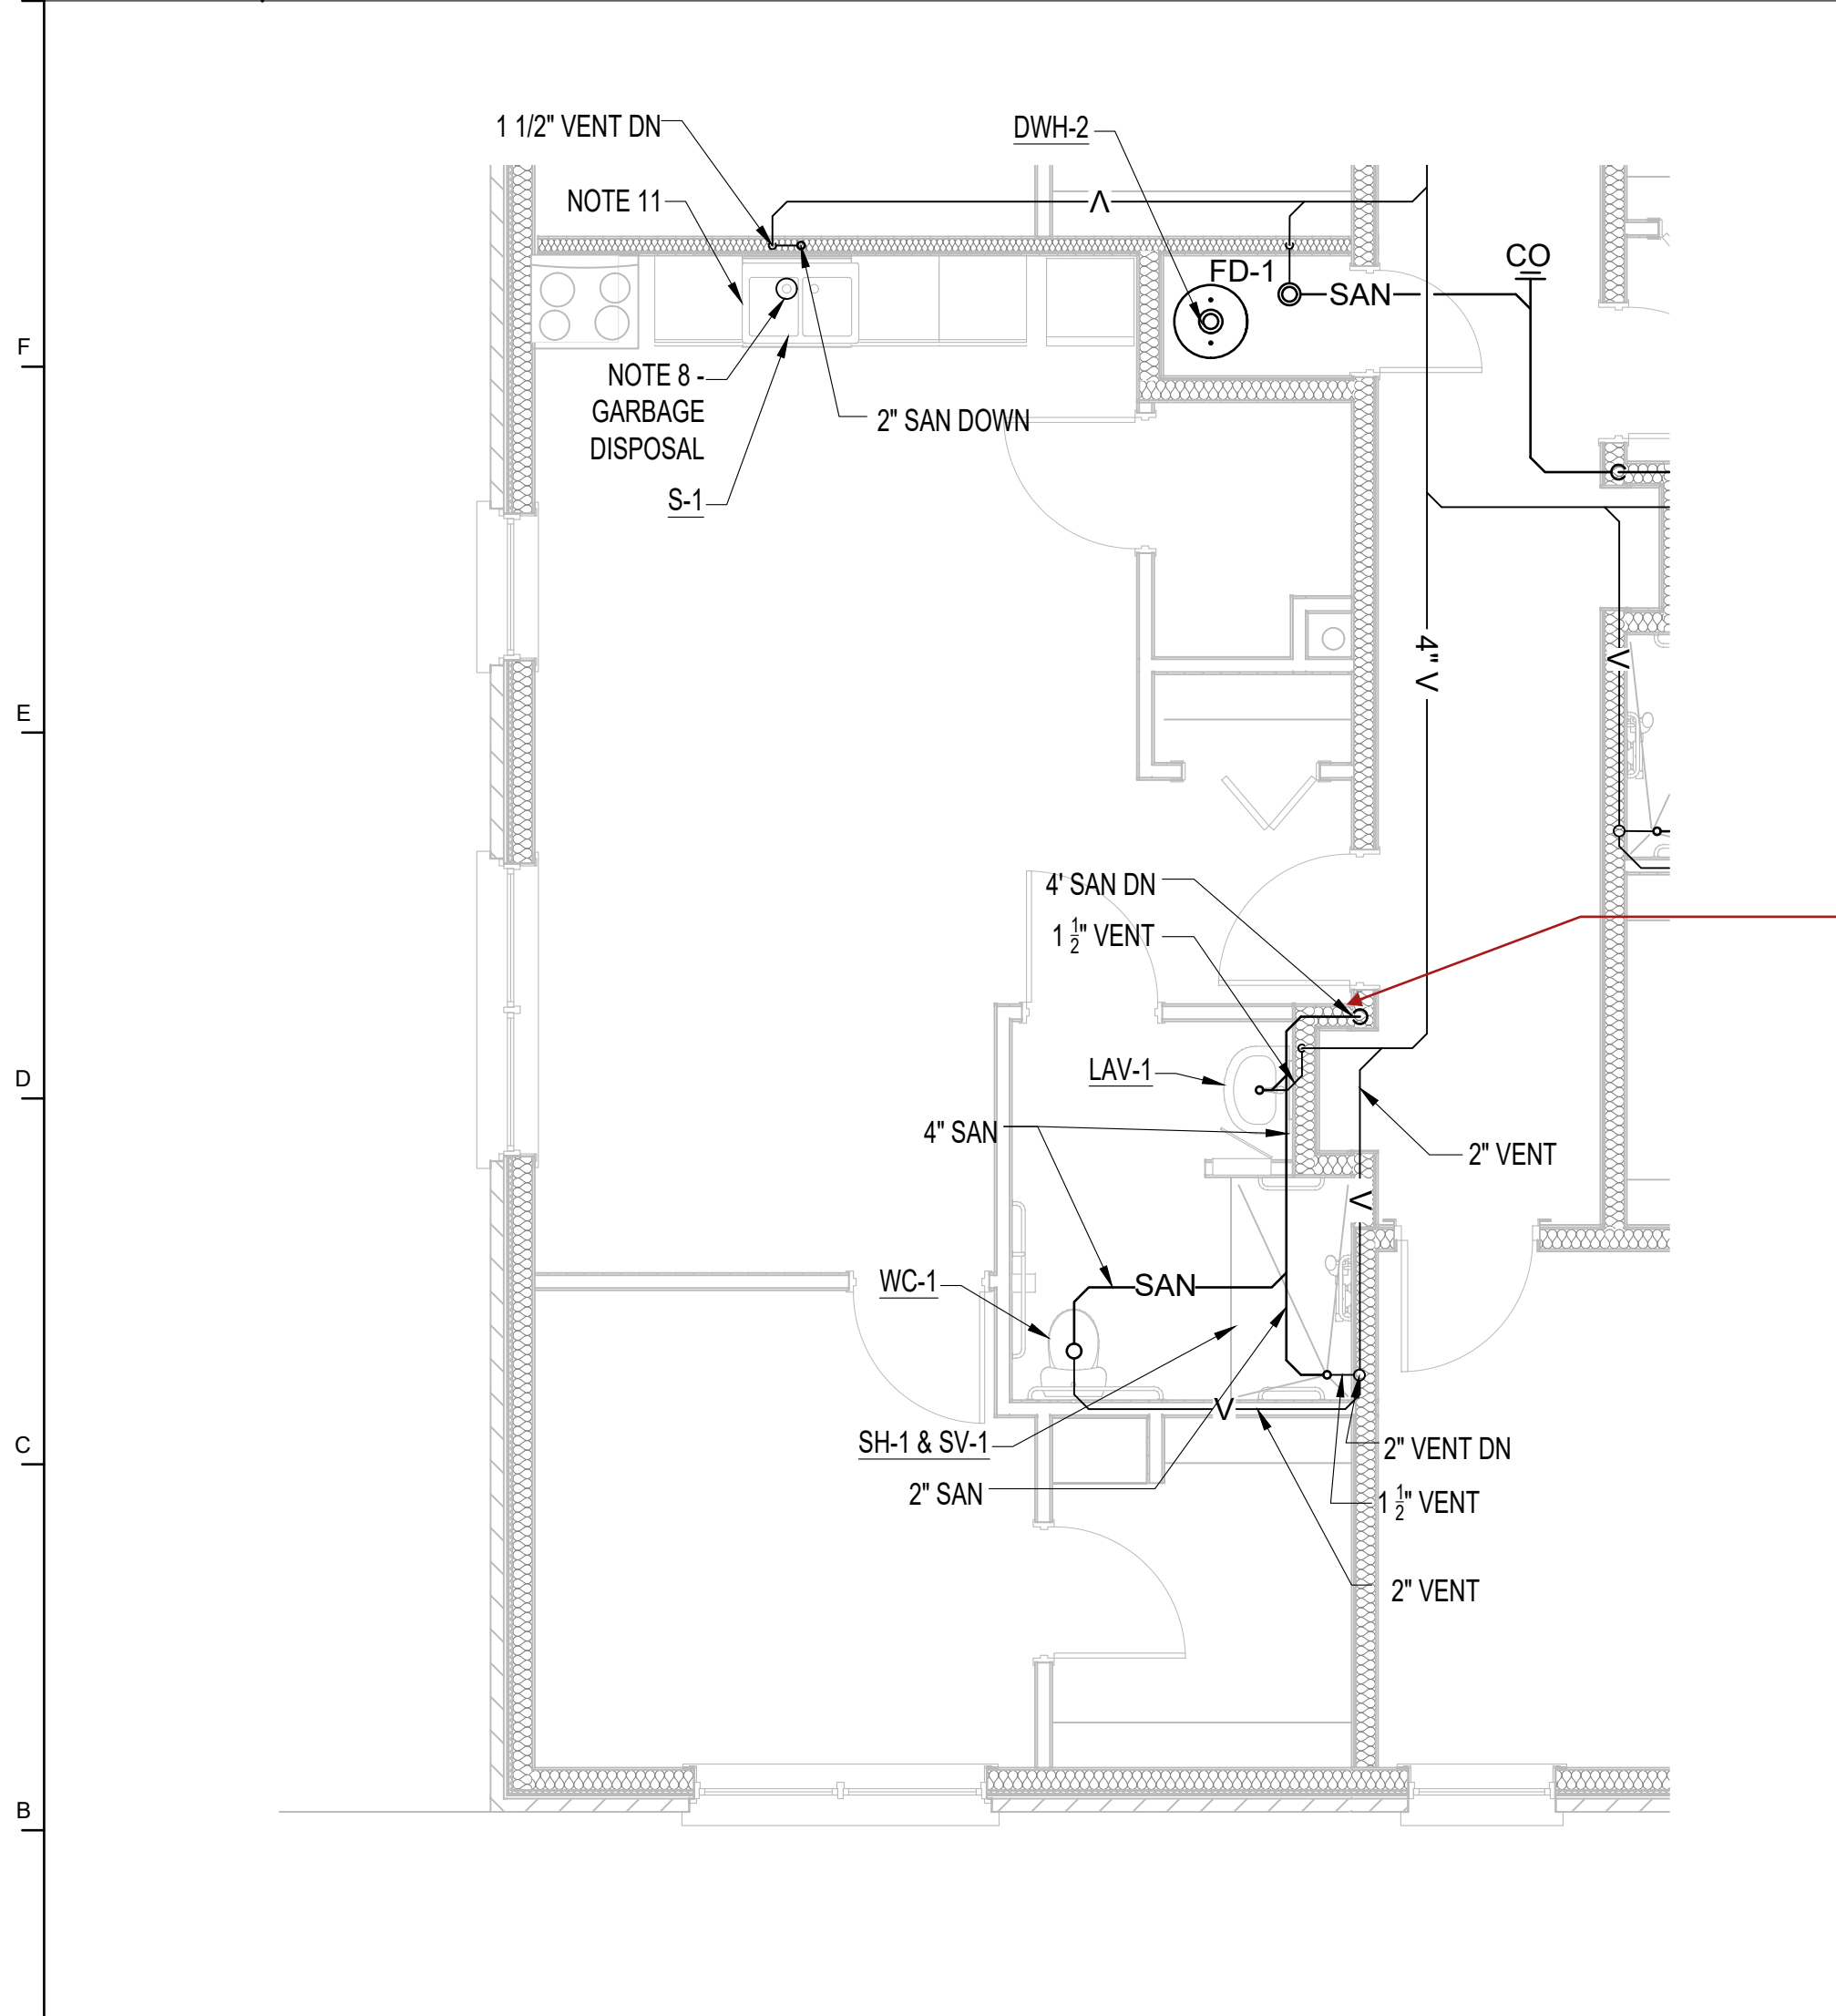

A1 1B UNIT A - 2ND FLR SANITARY/VENTING PLAN

P-402 1/4" = 1'-0"

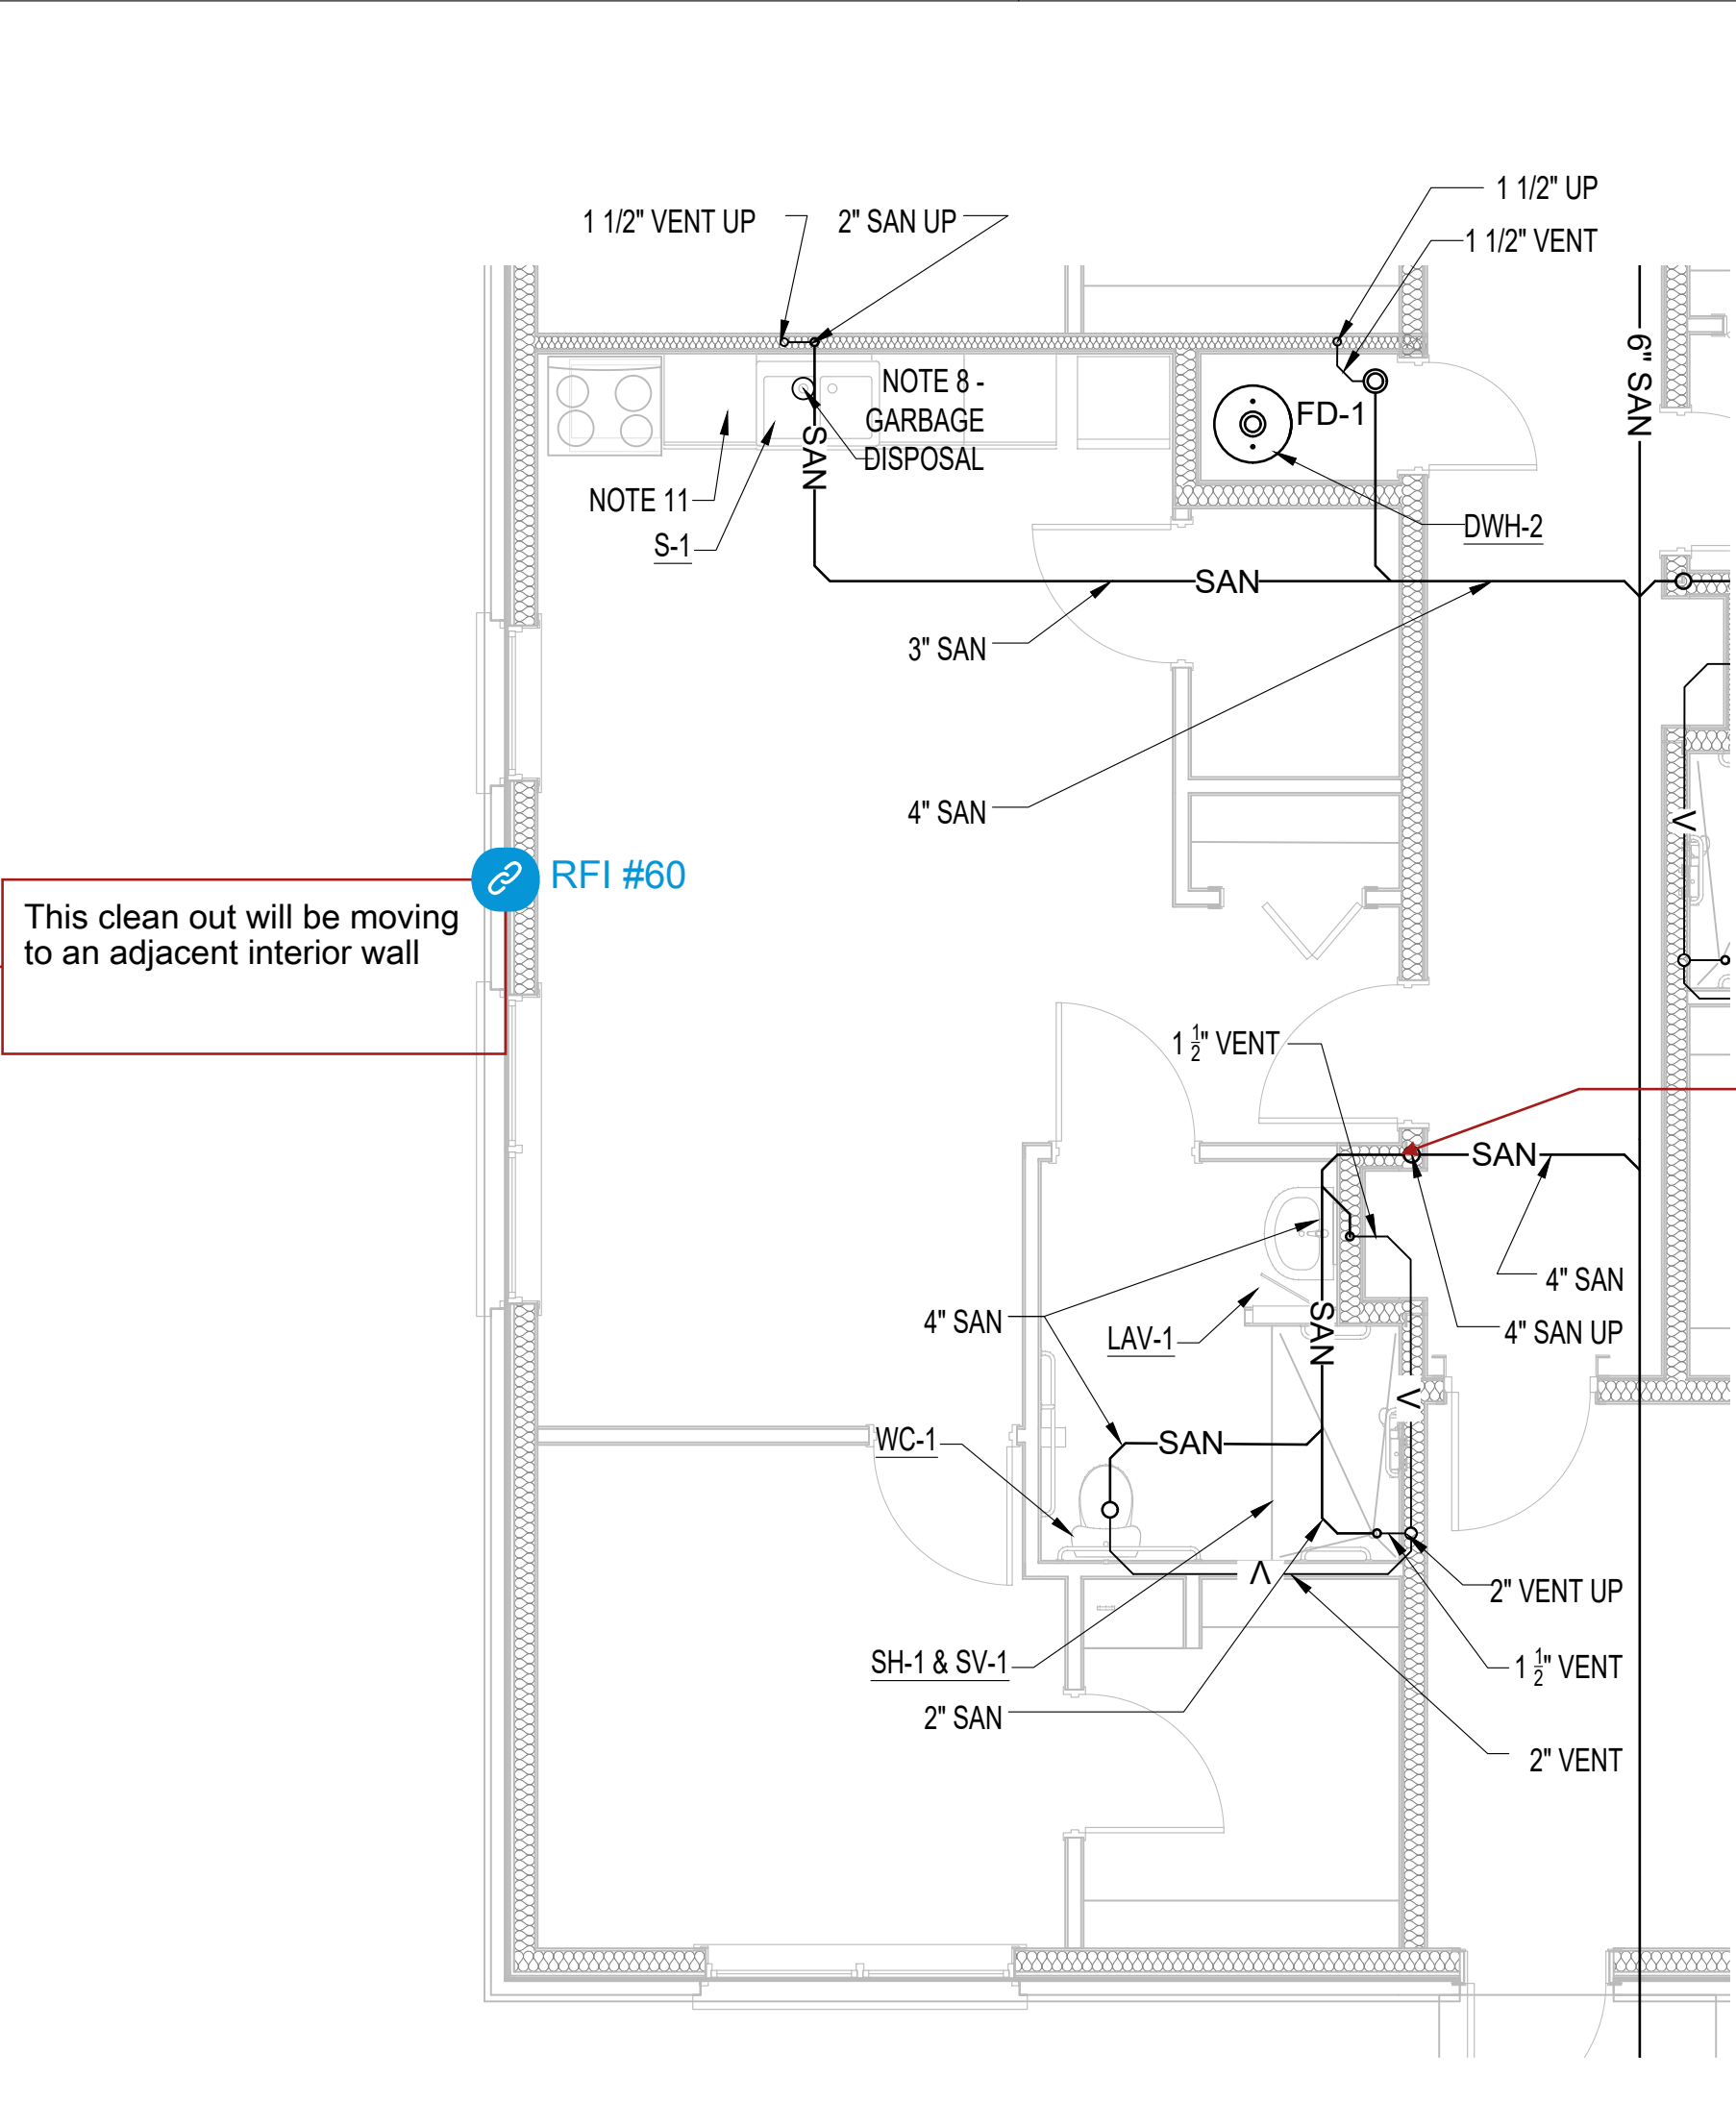


This clean out will be moving to an adjacent interior wall

RFI #60

A6 1B UNIT A - 1ST FLR SANITARY/VENTING PLAN

P-402 1/4" = 1'-0"

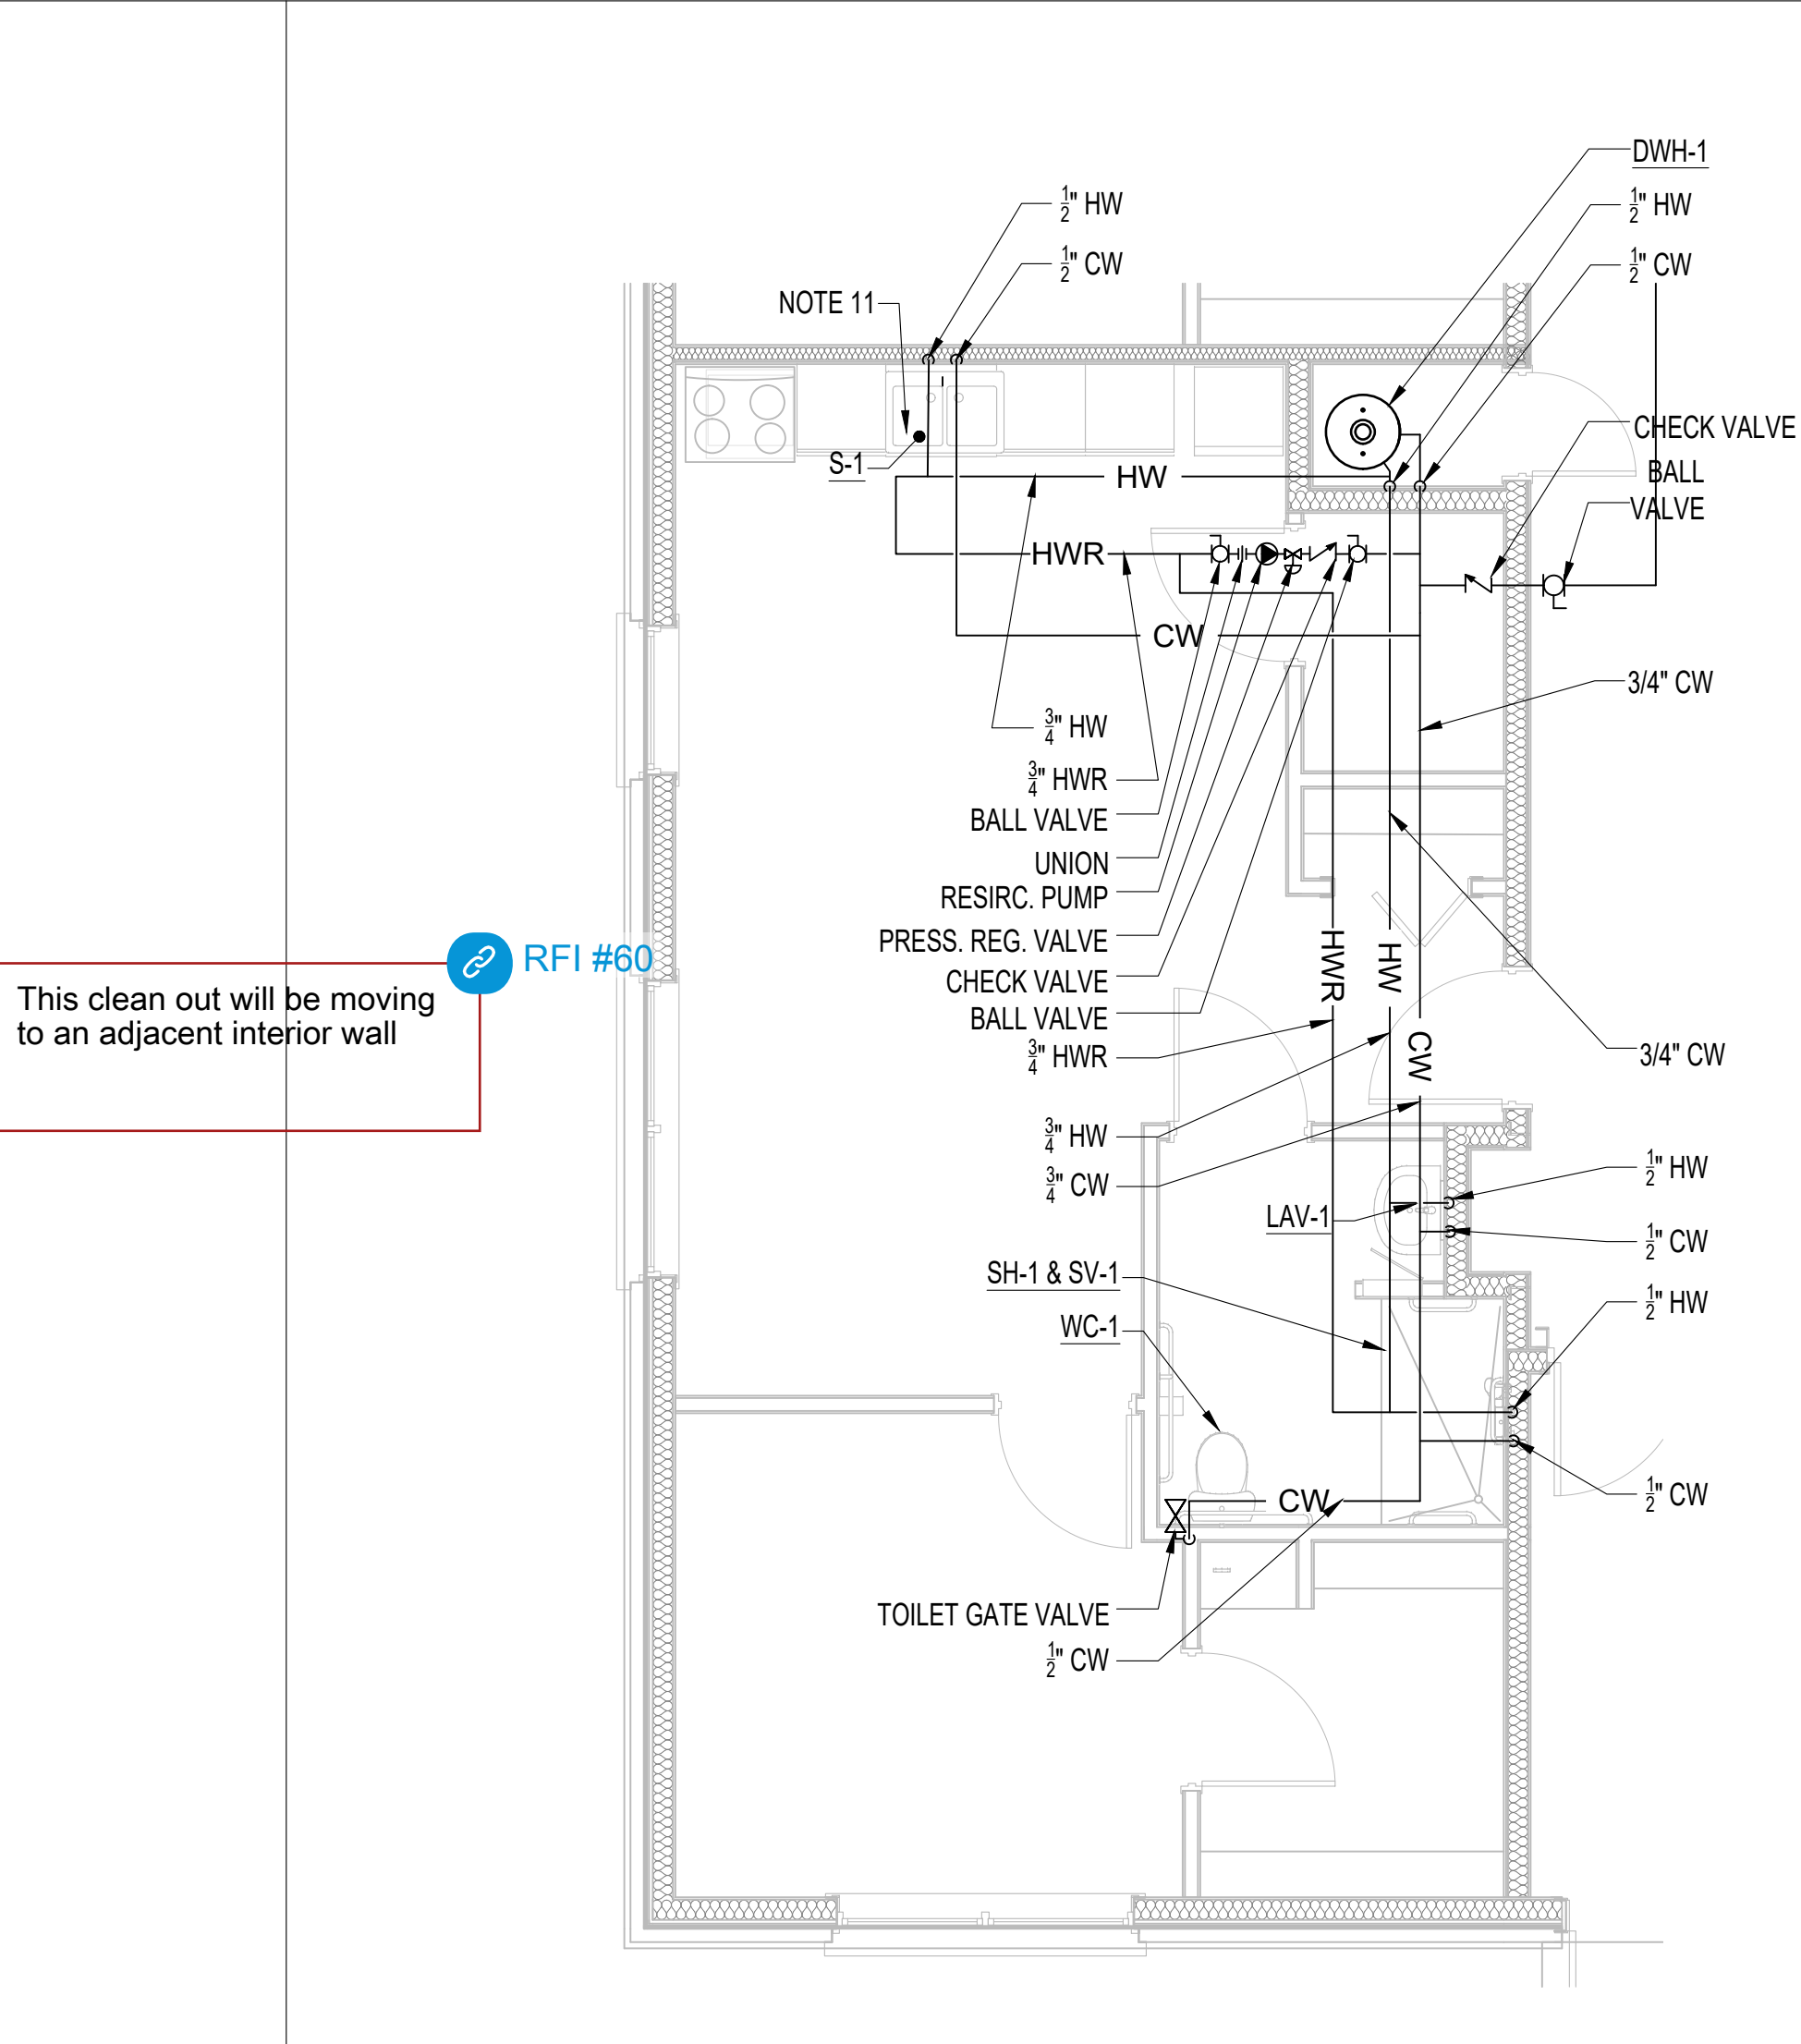

This clean out will be moving to an adjacent interior wall

RFI #60

A12 1B UNIT A - PLUMBING PLAN

P-402 1/4" = 1'-0"

SHEET TITLE

ENLARGED PLUMBING PLANS

SCALE: AS NOTED

ISSUED FOR PERMIT DATE 10.20.24

DRAWN BY

CHECKED

APPROVED


FILE NO.

SHEET NO.

21026.00


P-402

5/19/2025 5:34:20 AM

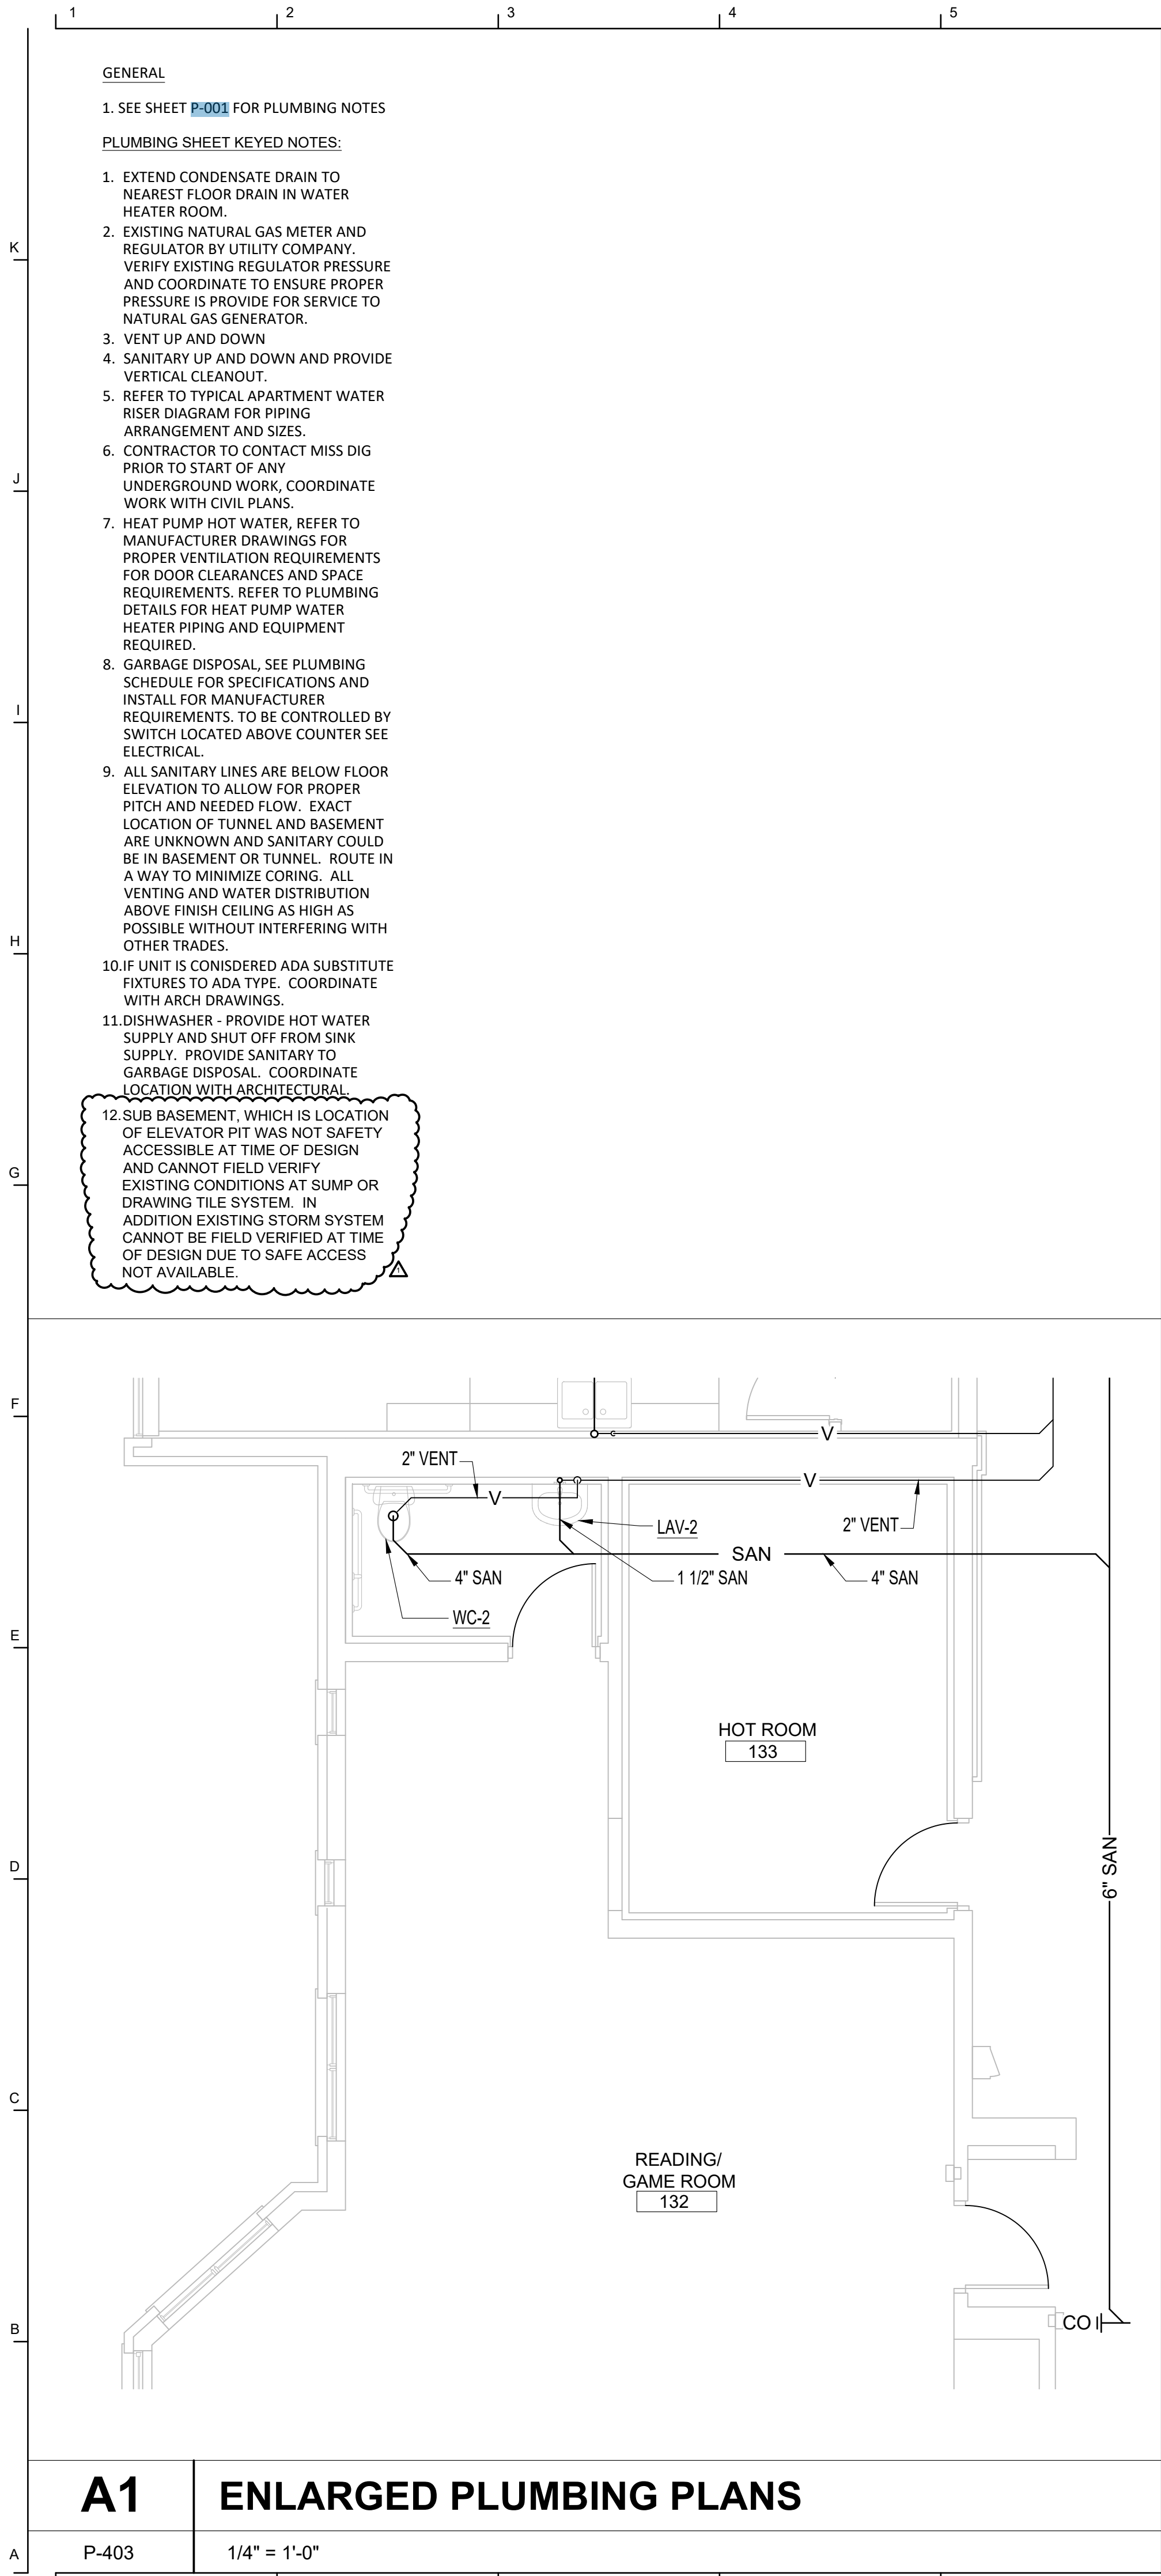

A1 ENLARGED PLUMBING PLANS

P-403 1/4" = 1'-0"

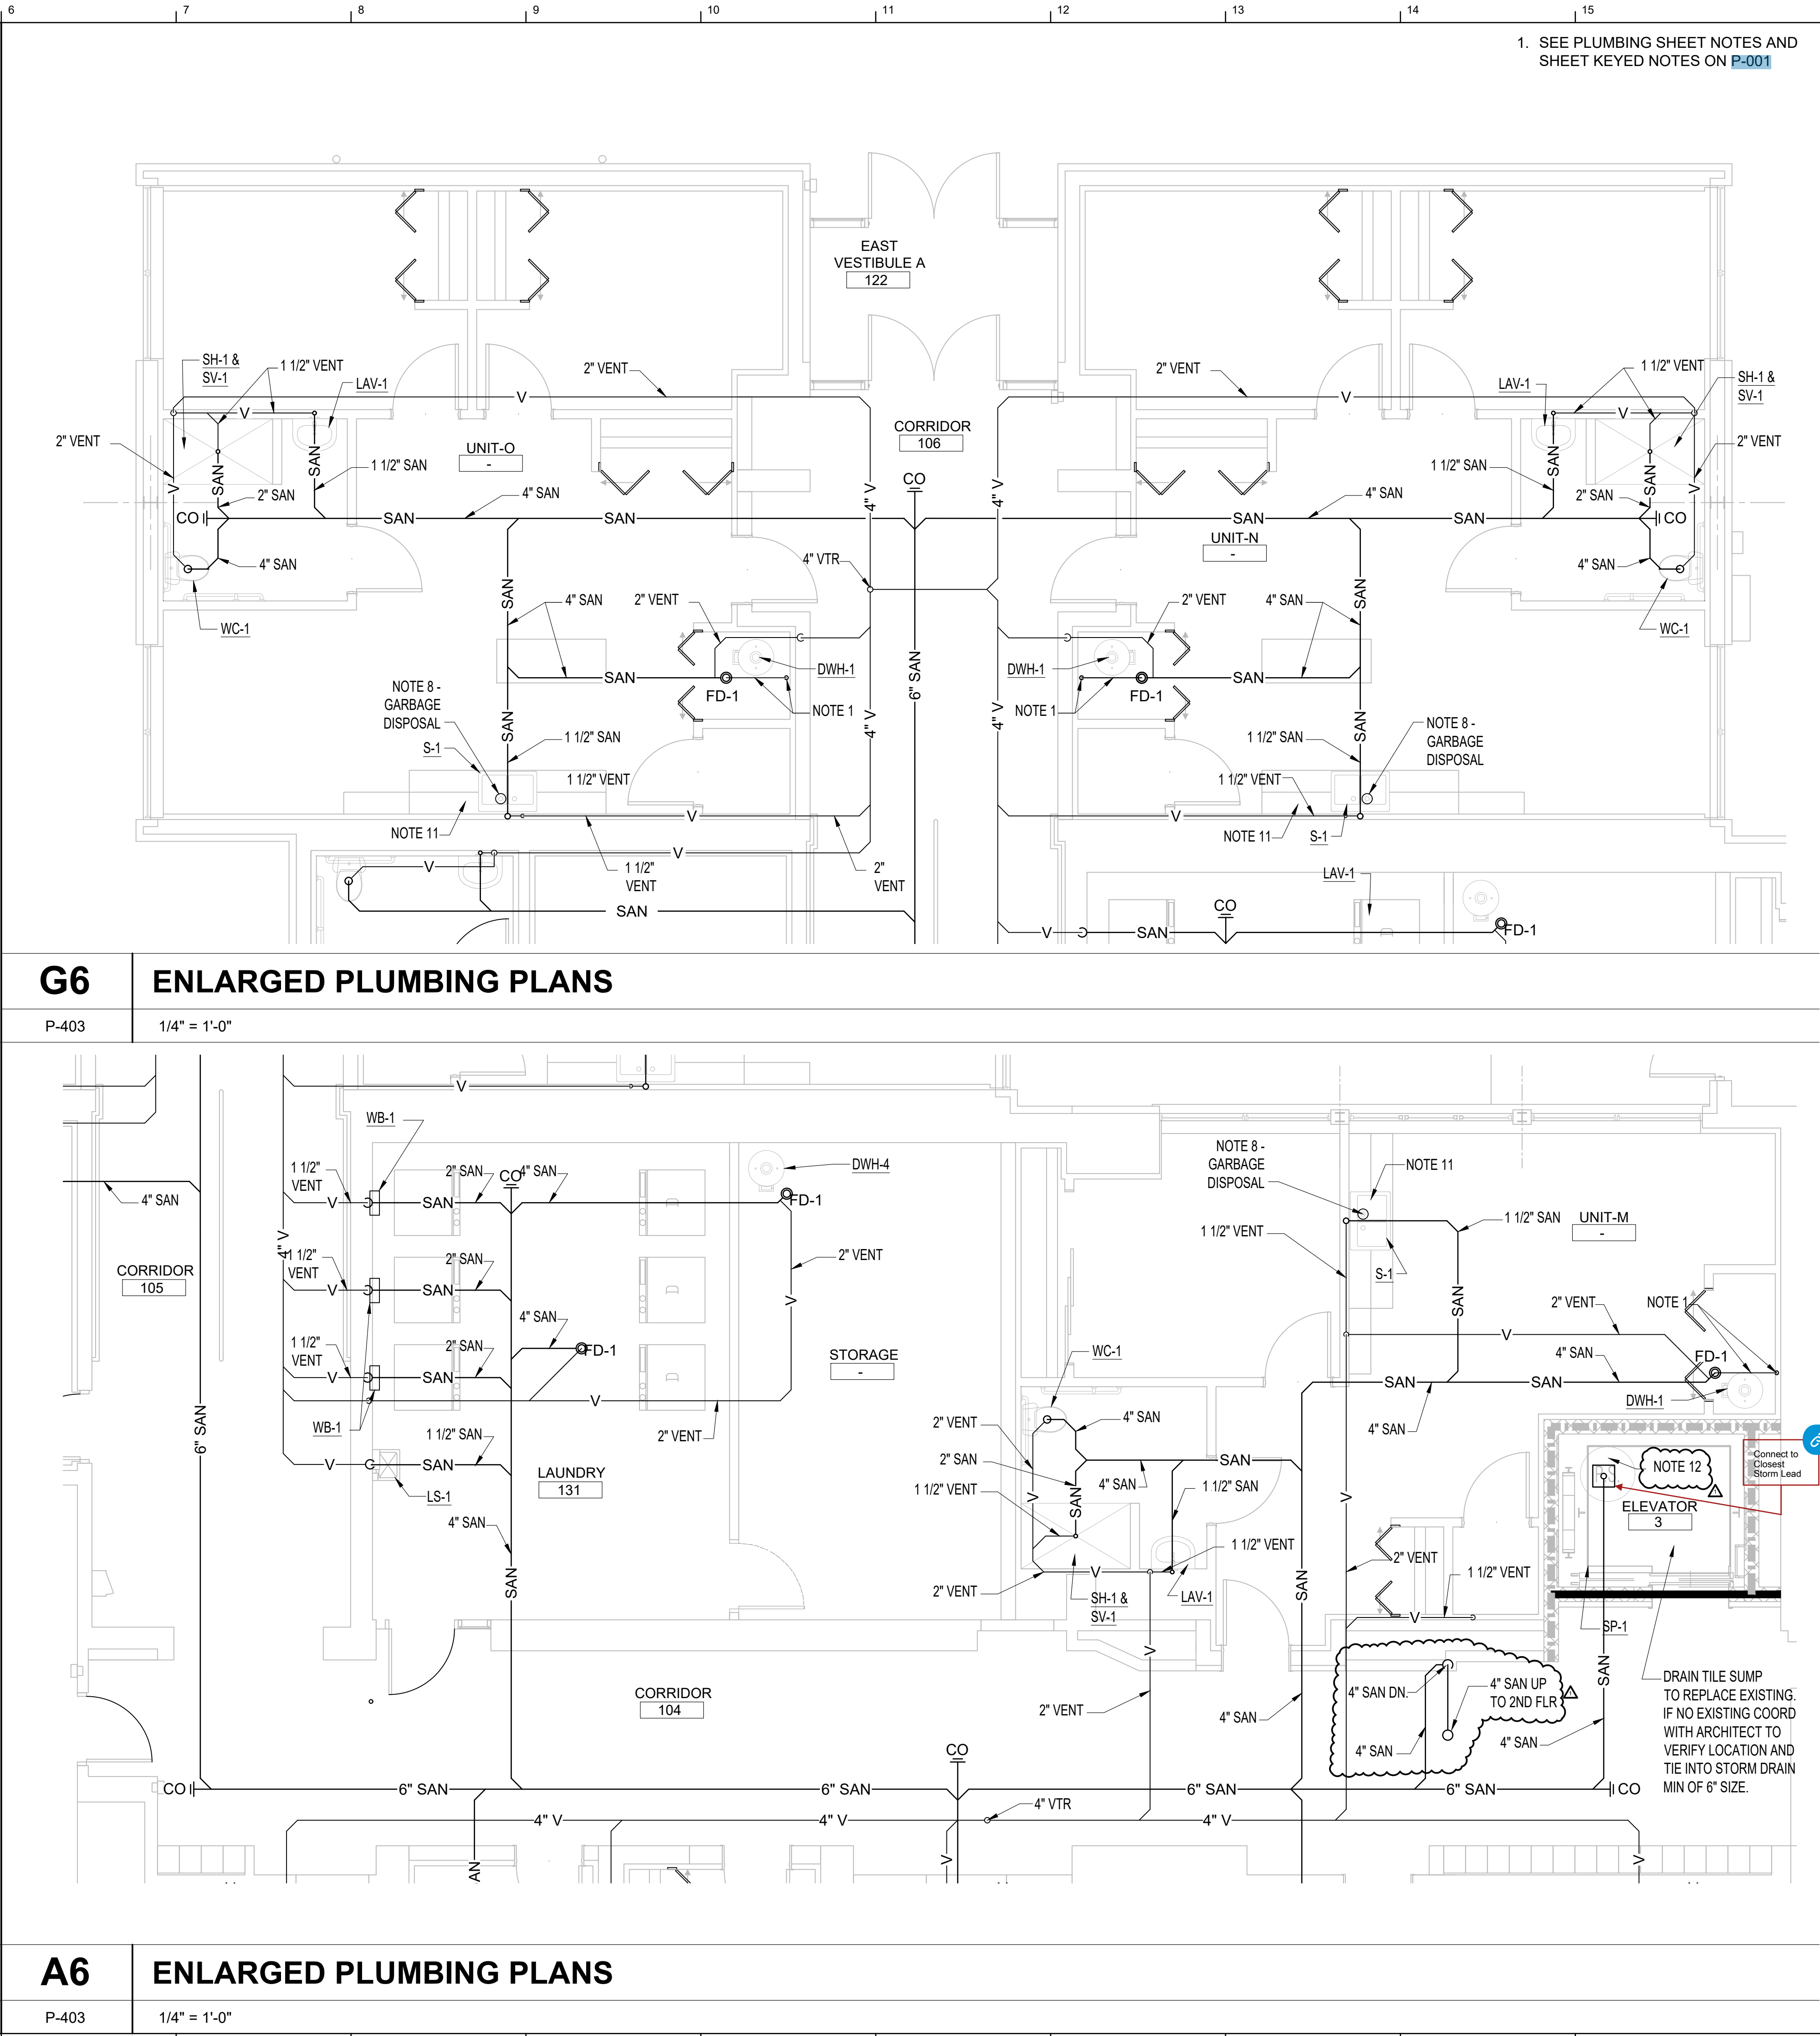

John Grace Arms
21030 Indian St, Southfield MI 48033
Developed by
John Grace Arms LDHA LLC

SDG
Architects + Planners
607 Shelby Street
Suite 704
Detroit, MI 48226
Tel: 313-961-0000
Fax: 313-964-3233

A & A Engineering & Consulting
28862 Vista Way, South Lyon, MI 48178

REGISTRATION SEAL

KEY PLANS

SHEET TITLE

ENLARGED PLUMBING PLANS

RFI #14

SCALE: AS NOTED

ISSUED FOR	DATE
PERMIT	10.20.24
Δ BULLETIN 3	5.19.25

DRAWN BY

CHECKED


APPROVED

21026.00

P-403

SHEET NO.

2/18/2025 4:10:00 PM

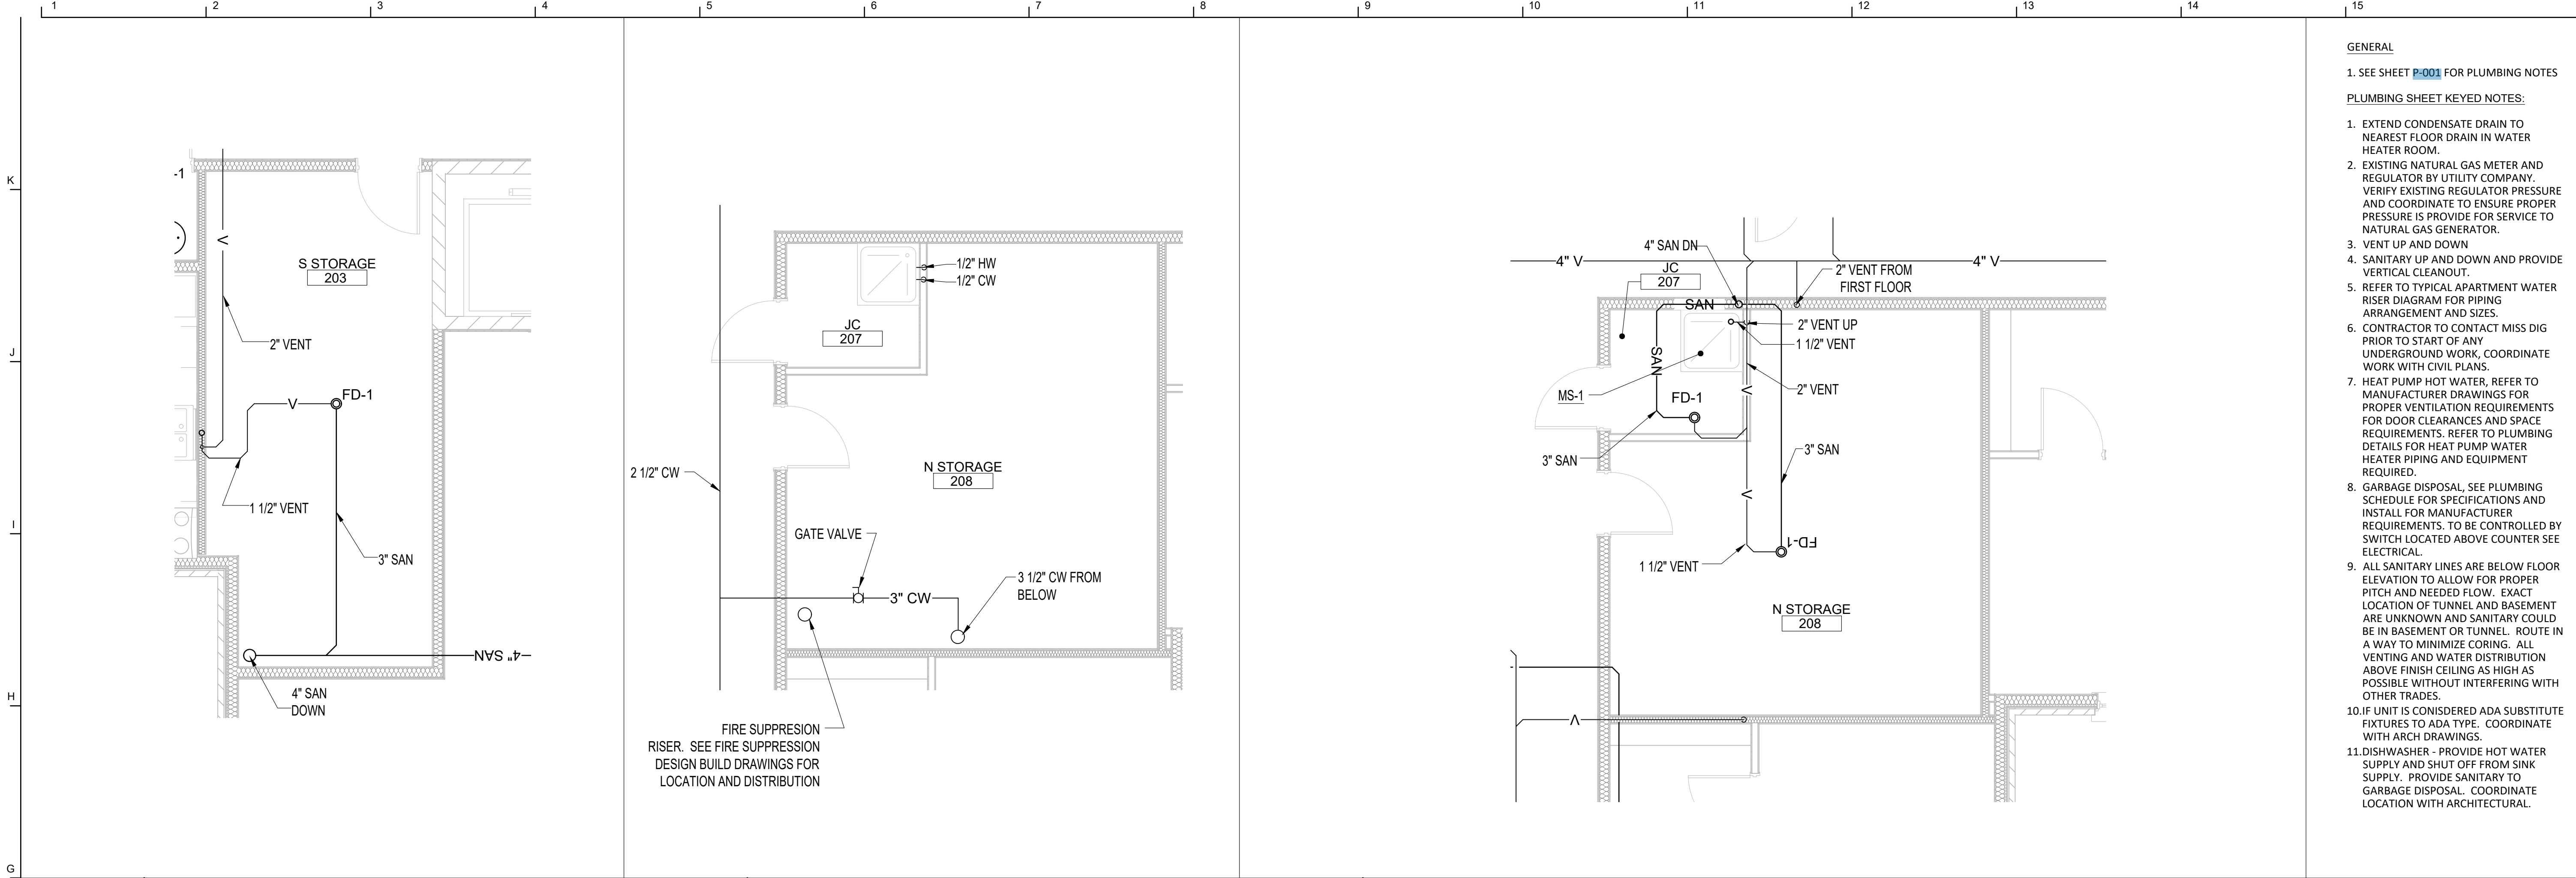

GENERAL

1. SEE SHEET **P-001** FOR PLUMBING NOTES

PLUMBING SHEET KEYED NOTES:

1. EXTEND CONDENSATE DRAIN TO NEAREST FLOOR DRAIN IN WATER HEATER ROOM.
2. EXISTING NATURAL GAS METER AND REGULATOR BY UTILITY COMPANY. VERIFY EXISTING REGULATOR PRESSURE AND COORDINATE TO ENSURE PROPER PRESSURE IS PROVIDE FOR SERVICE TO NATURAL GAS GENERATOR.
3. VENT UP AND DOWN
4. SANITARY UP AND DOWN AND PROVIDE VERTICAL CLEANOUT.
5. REFER TO TYPICAL APARTMENT WATER RISER DIAGRAM FOR PIPING ARRANGEMENT AND SIZES.
6. CONTRACTOR TO CONTACT MISS DIG PRIOR TO START OF ANY UNDERGROUND WORK, COORDINATE WORK WITH CIVIL PLANS.
7. HEAT PUMP HOT WATER, REFER TO MANUFACTURER DRAWINGS FOR PROPER VENTILATION REQUIREMENTS FOR DOOR CLEARANCES AND SPACE REQUIREMENTS. REFER TO PLUMBING DETAILS FOR HEAT PUMP WATER HEATER PIPING AND EQUIPMENT REQUIRED.
8. GARBAGE DISPOSAL, SEE PLUMBING SCHEDULE FOR SPECIFICATIONS AND INSTALL FOR MANUFACTURER REQUIREMENTS. TO BE CONTROLLED BY SWITCH LOCATED ABOVE COUNTER SEE ELECTRICAL.
9. ALL SANITARY LINES ARE BELOW FLOOR ELEVATION TO ALLOW FOR PROPER PITCH AND NEEDED FLOW. EXACT LOCATION OF TUNNEL AND BASEMENT ARE UNKNOWN AND SANITARY COULD BE IN BASEMENT OR TUNNEL. ROUTE IN A WAY TO MINIMIZE CORING. ALL VENTING AND WATER DISTRIBUTION ABOVE FINISH CEILING AS HIGH AS POSSIBLE WITHOUT INTERFERING WITH OTHER TRADES.
10. IF UNIT IS CONSIDERED ADA SUBSTITUTE FIXTURES TO ADA TYPE. COORDINATE WITH ARCH DRAWINGS.
11. DISHWASHER - PROVIDE HOT WATER SUPPLY AND SHUT OFF FROM SINK SUPPLY. PROVIDE SANITARY TO GARBAGE DISPOSAL. COORDINATE LOCATION WITH ARCHITECTURAL.

G1 ENLARGED PLUMBING PLANS


P-405 1/4" = 1'-0"

G4 ENLARGED PLUMBING PLANS

P-405 1/4" = 1'-0"


G9 ENLARGED PLUMBING PLANS

P-405 1/4" = 1'-0"

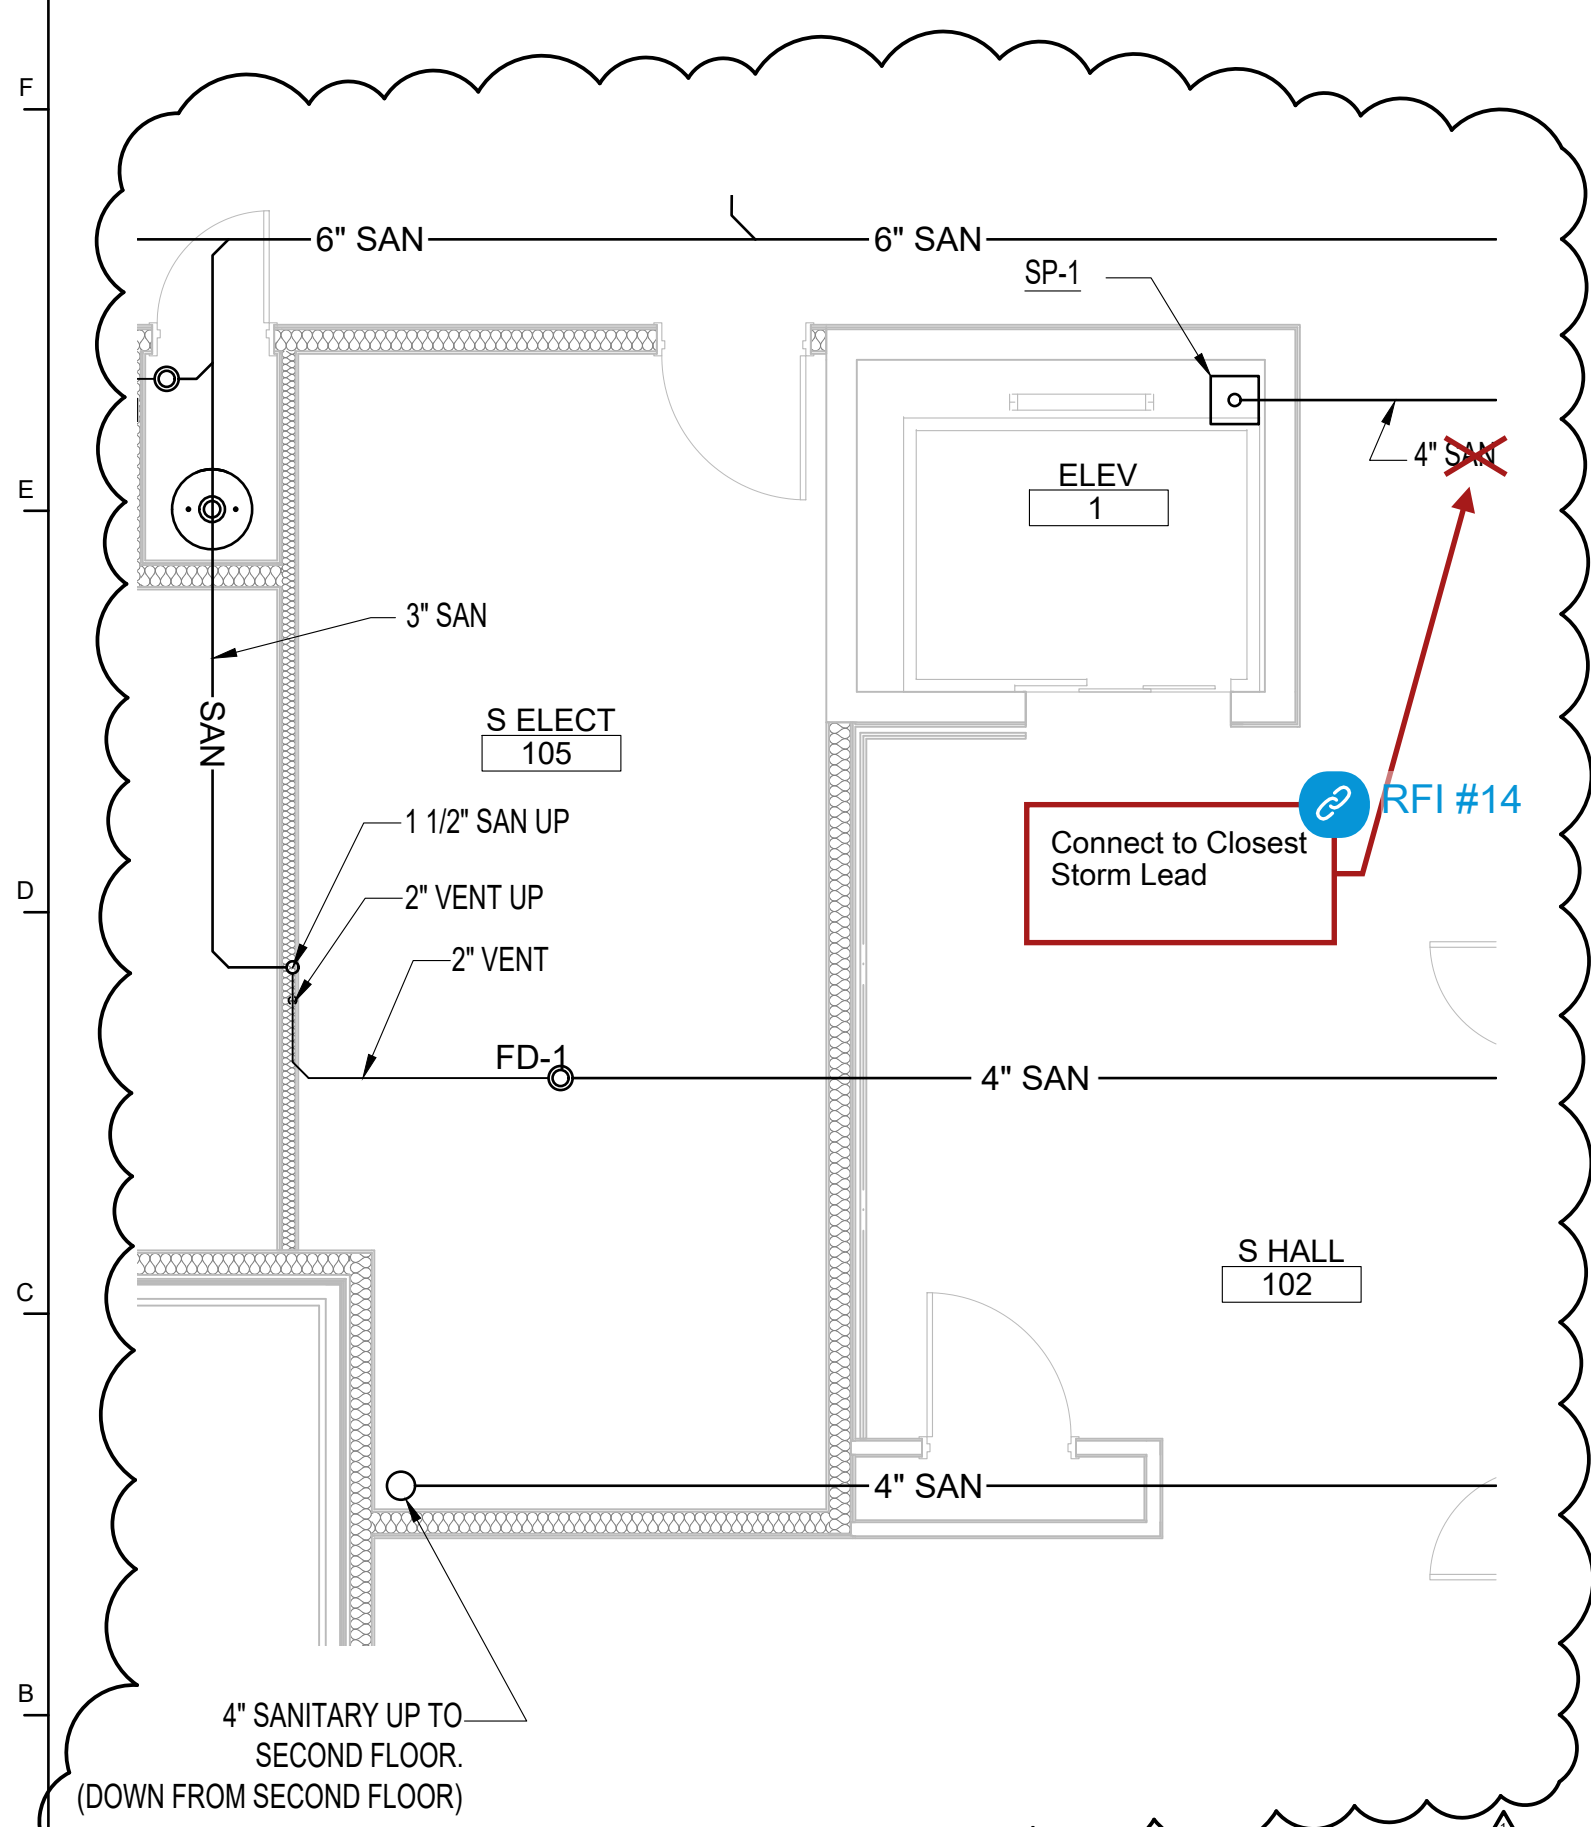

A1 ENLARGED PLUMBING PLANS

P-405 1/4" = 1'-0"

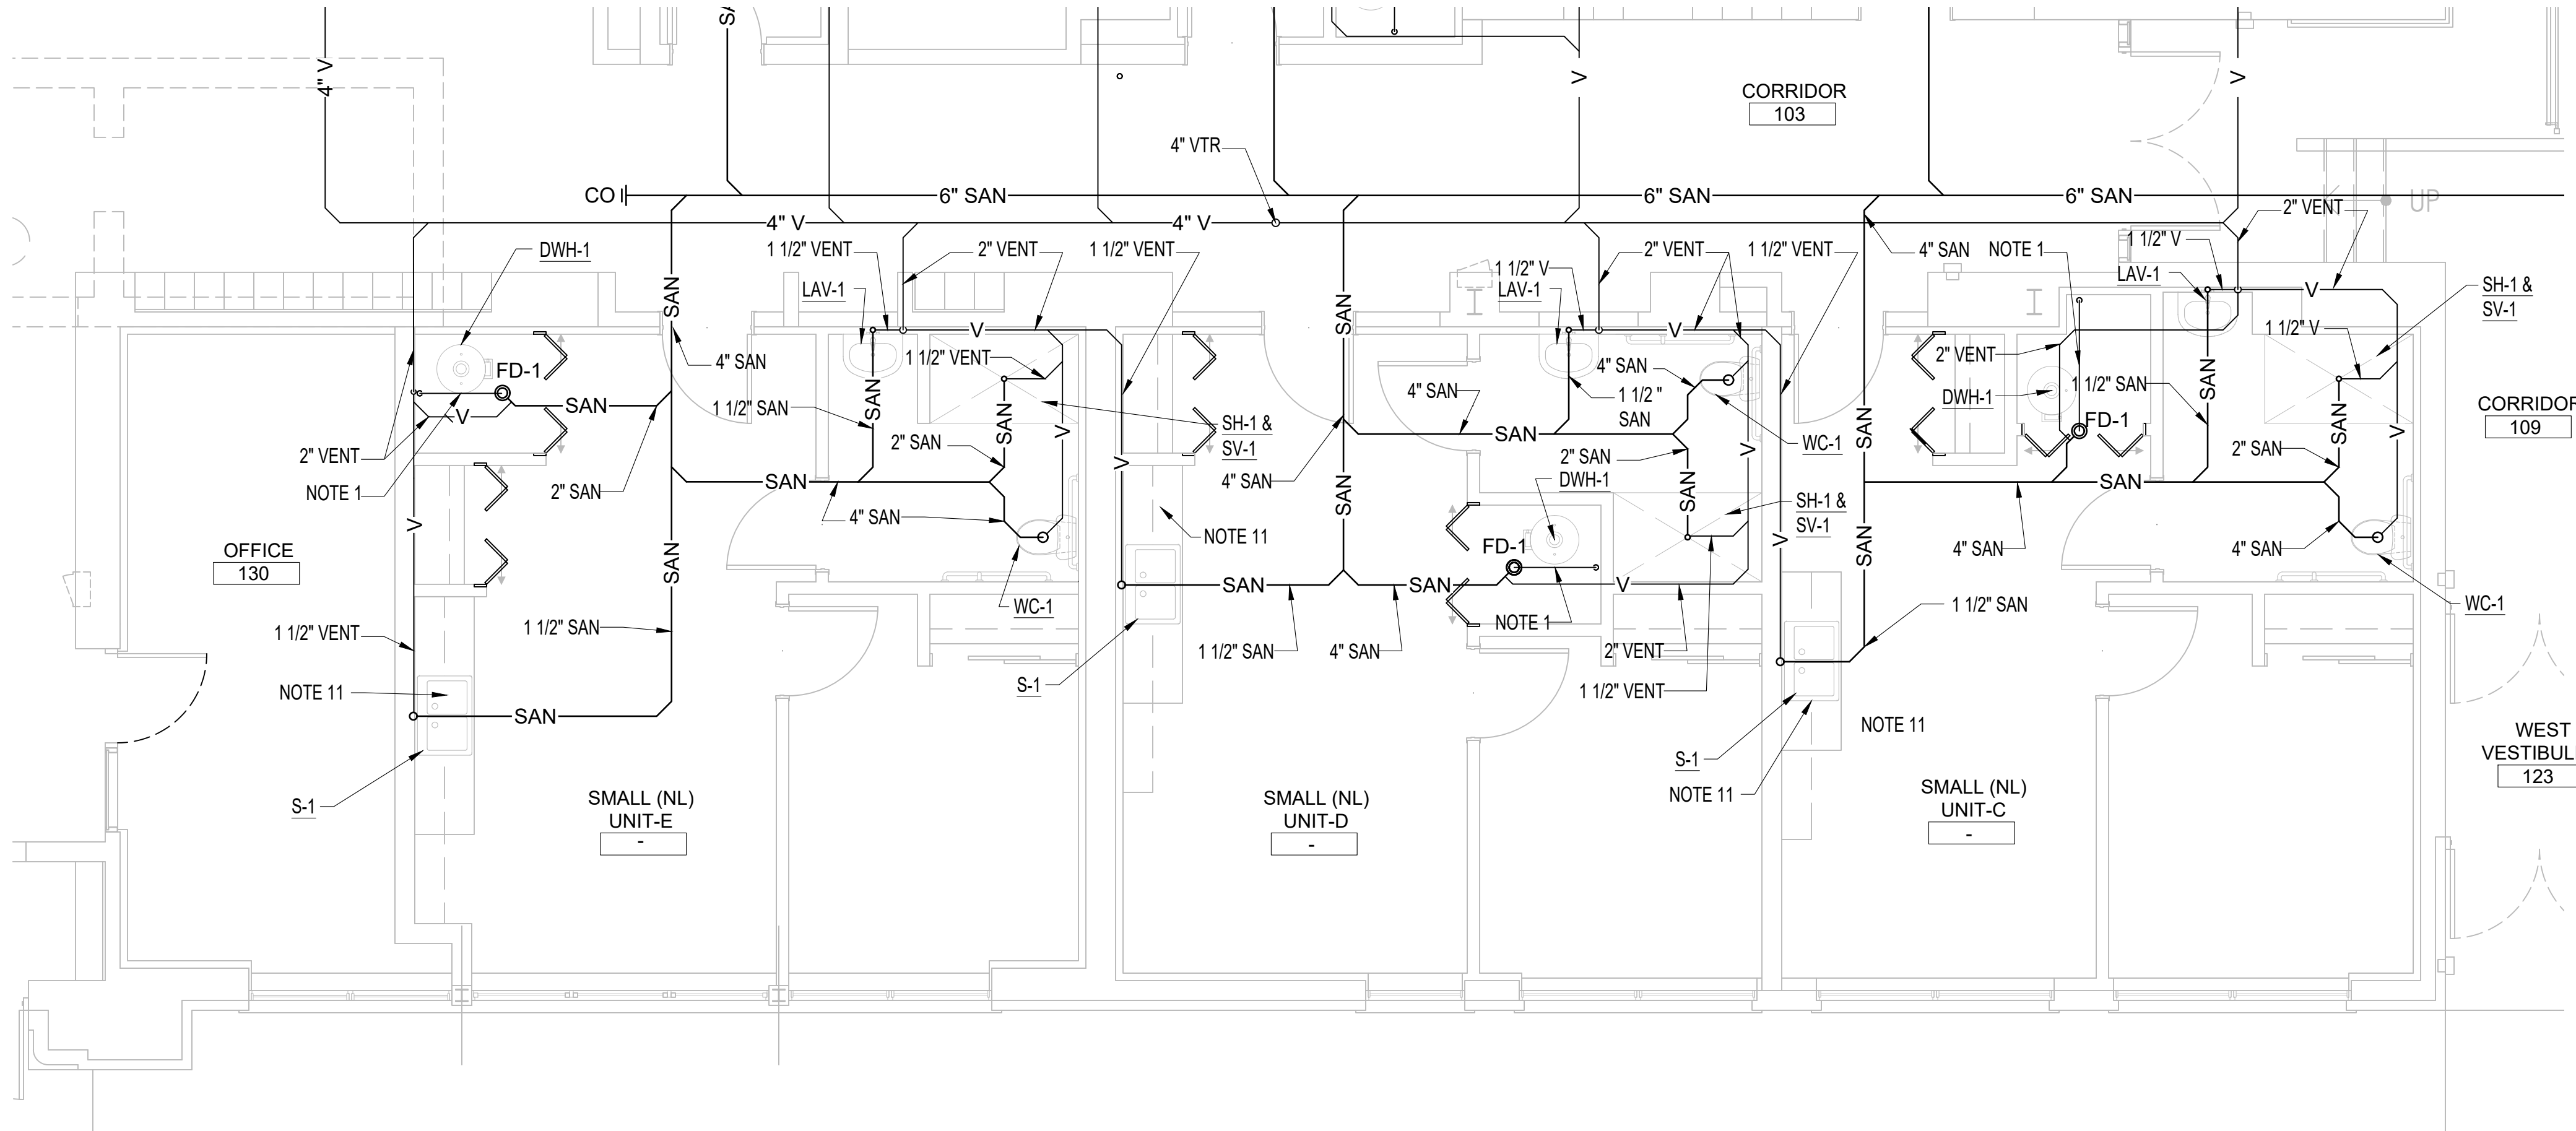

A5 ENLARGED PLUMBING PLANS

P-405 1/4" = 1'-0"

John Grace Arms
21030 Indian St, Southfield MI 48033
Developed by
John Grace Arms LDHA LLC

SDG
Architects + Planners
607 Shelby Street
Suite 704
Detroit, MI 48226
Tel: 313-961-0000
Fax: 313-964-3233



A & A Engineering & Consulting
28862 Vista Way, South Lyon, MI 48178

REGISTRATION SEAL



KEY PLANS

SHEET TITLE

ENLARGED PLUMBING
PLANS

SCALE: AS NOTED

ISSUED FOR	DATE
PERMIT	10.20.24
△ BULLETIN 1	2.19.25

DRAWN BY

CHECKED

APPROVED

21026.00

FILE NO.


P-405

SHEET NO.

12/19/2024 6:24:50 PM

K
J
I
H
G
F
E
D
C
B
A


- GENERAL
1. SEE SHEET **P-001** FOR PLUMBING NOTES
- PLUMBING SHEET KEYED NOTES:
1. EXTEND CONDENSATE DRAIN TO NEAREST FLOOR DRAIN IN WATER HEATER ROOM.
 2. EXISTING NATURAL GAS METER AND REGULATOR BY UTILITY COMPANY. VERIFY EXISTING REGULATOR PRESSURE AND COORDINATE TO ENSURE PROPER PRESSURE IS PROVIDE FOR SERVICE TO NATURAL GAS GENERATOR.
 3. VENT UP AND DOWN
 4. SANITARY UP AND DOWN AND PROVIDE VERTICAL CLEANOUT.
 5. REFER TO TYPICAL APARTMENT WATER RISER DIAGRAM FOR PIPING ARRANGEMENT AND SIZES.
 6. CONTRACTOR TO CONTACT MISS DIG PRIOR TO START OF ANY UNDERGROUND WORK. COORDINATE WORK WITH CIVIL PLANS.
 7. HEAT PUMP HOT WATER, REFER TO MANUFACTURER DRAWINGS FOR PROPER VENTILATION REQUIREMENTS FOR DOOR CLEARANCES AND SPACE REQUIREMENTS. REFER TO PLUMBING DETAILS FOR HEAT PUMP WATER HEATER PIPING AND EQUIPMENT REQUIRED.
 8. GARBAGE DISPOSAL, SEE PLUMBING SCHEDULE FOR SPECIFICATIONS AND INSTALL FOR MANUFACTURER REQUIREMENTS. TO BE CONTROLLED BY SWITCH LOCATED ABOVE COUNTER SEE ELECTRICAL.
 9. ALL SANITARY LINES ARE BELOW FLOOR ELEVATION TO ALLOW FOR PROPER PITCH AND NEEDED FLOW. EXACT LOCATION OF TUNNEL AND BASEMENT ARE UNKNOWN AND SANITARY COULD BE IN BASEMENT OR TUNNEL. ROUTE IN A WAY TO MINIMIZE CORING. ALL VENTING AND WATER DISTRIBUTION ABOVE FINISH CEILING AS HIGH AS POSSIBLE WITHOUT INTERFERING WITH OTHER TRADES.
 10. IF UNIT IS CONSIDERED ADA SUBSTITUTE FIXTURES TO ADA TYPE. COORDINATE WITH ARCH DRAWINGS.
 11. DISHWASHER - PROVIDE HOT WATER SUPPLY AND SHUT OFF FROM SINK SUPPLY. PROVIDE SANITARY TO GARBAGE DISPOSAL. COORDINATE LOCATION WITH ARCHITECTURAL.

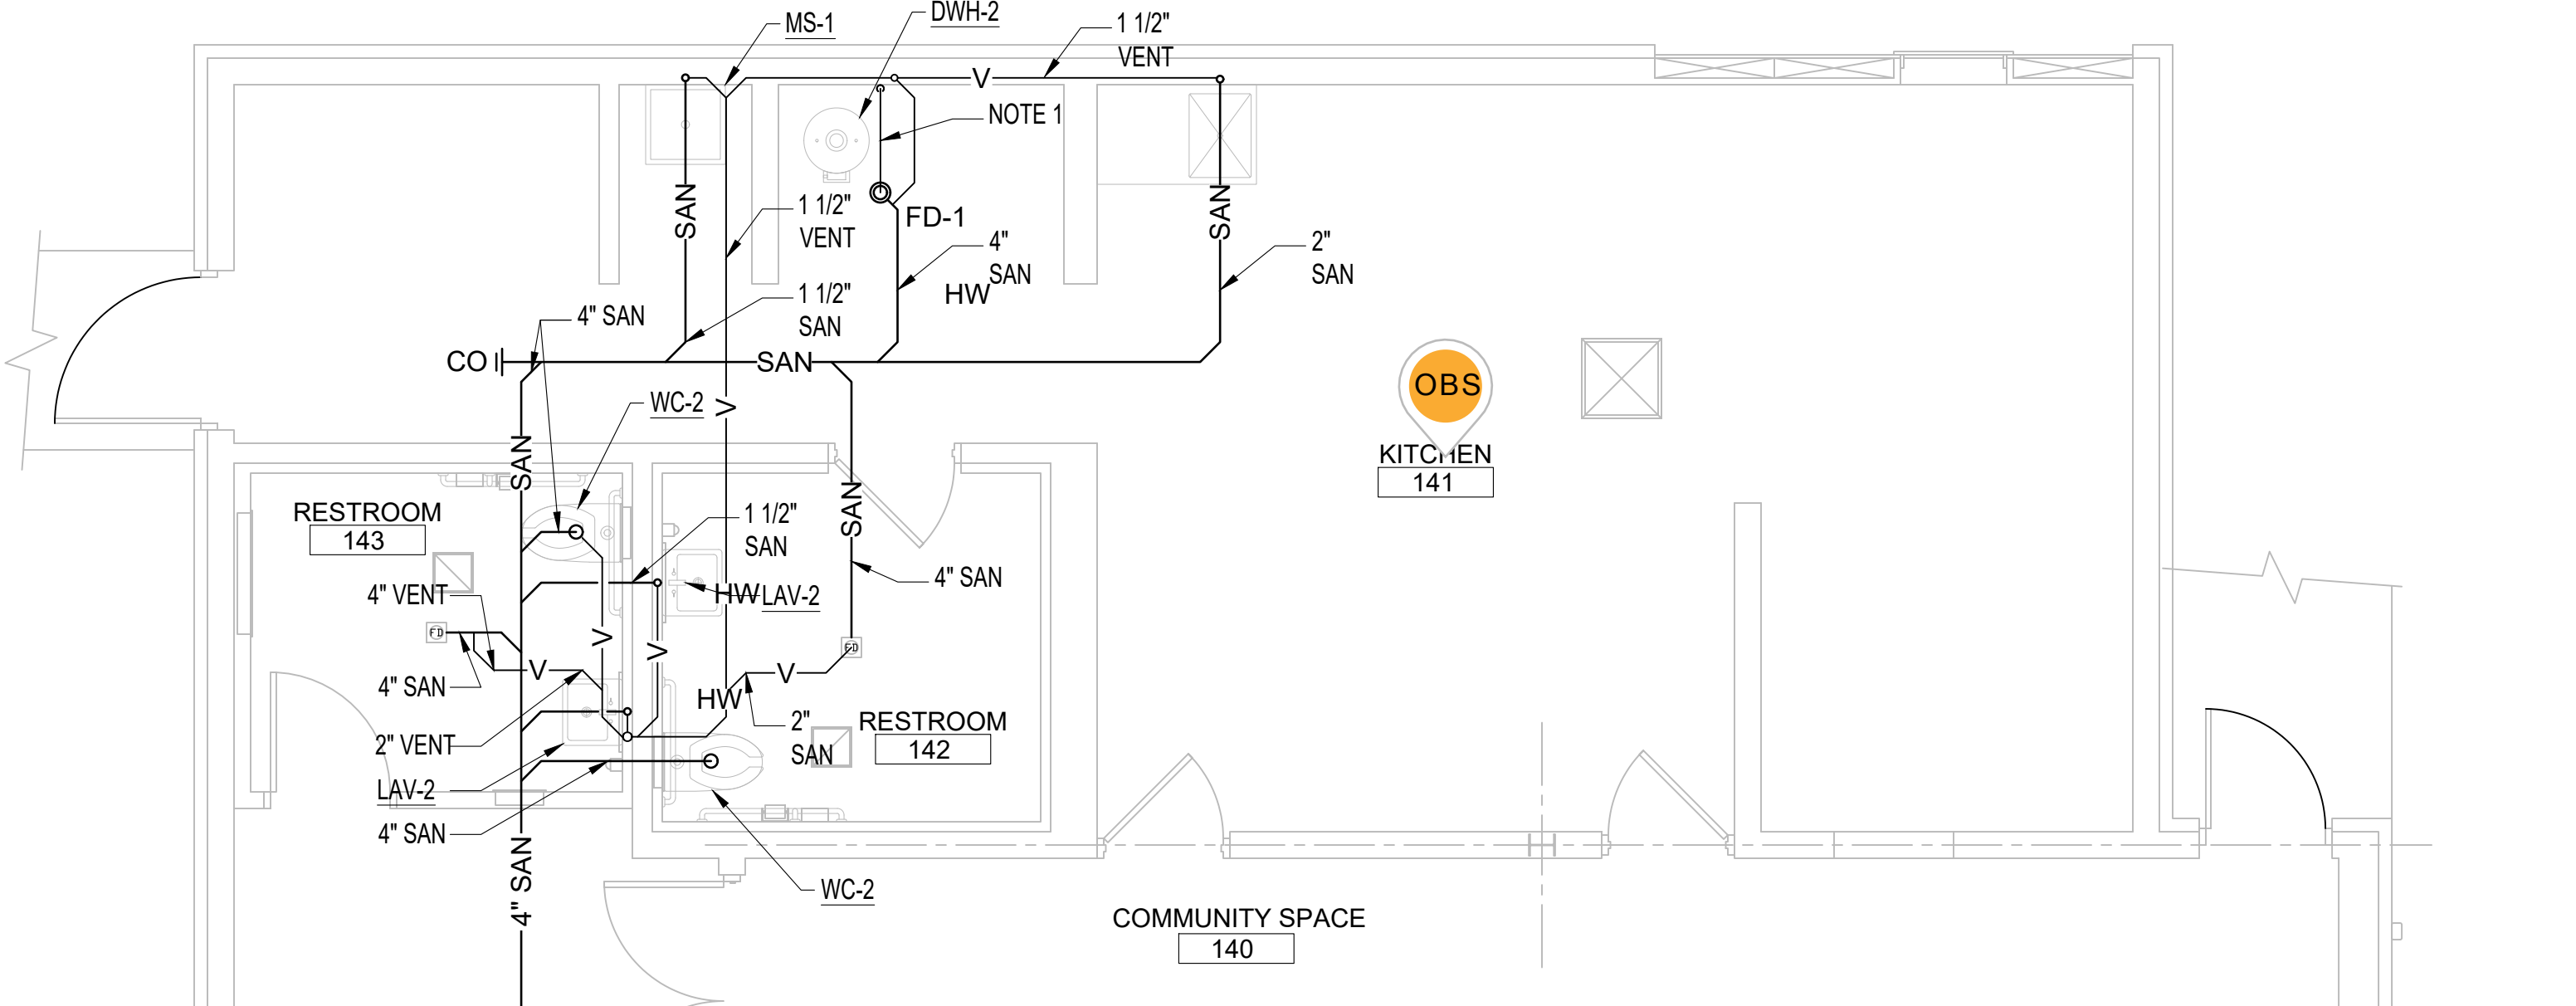

H8 ENLARGED PLUMBING PLANS

P-406

1/4" = 1'-0"

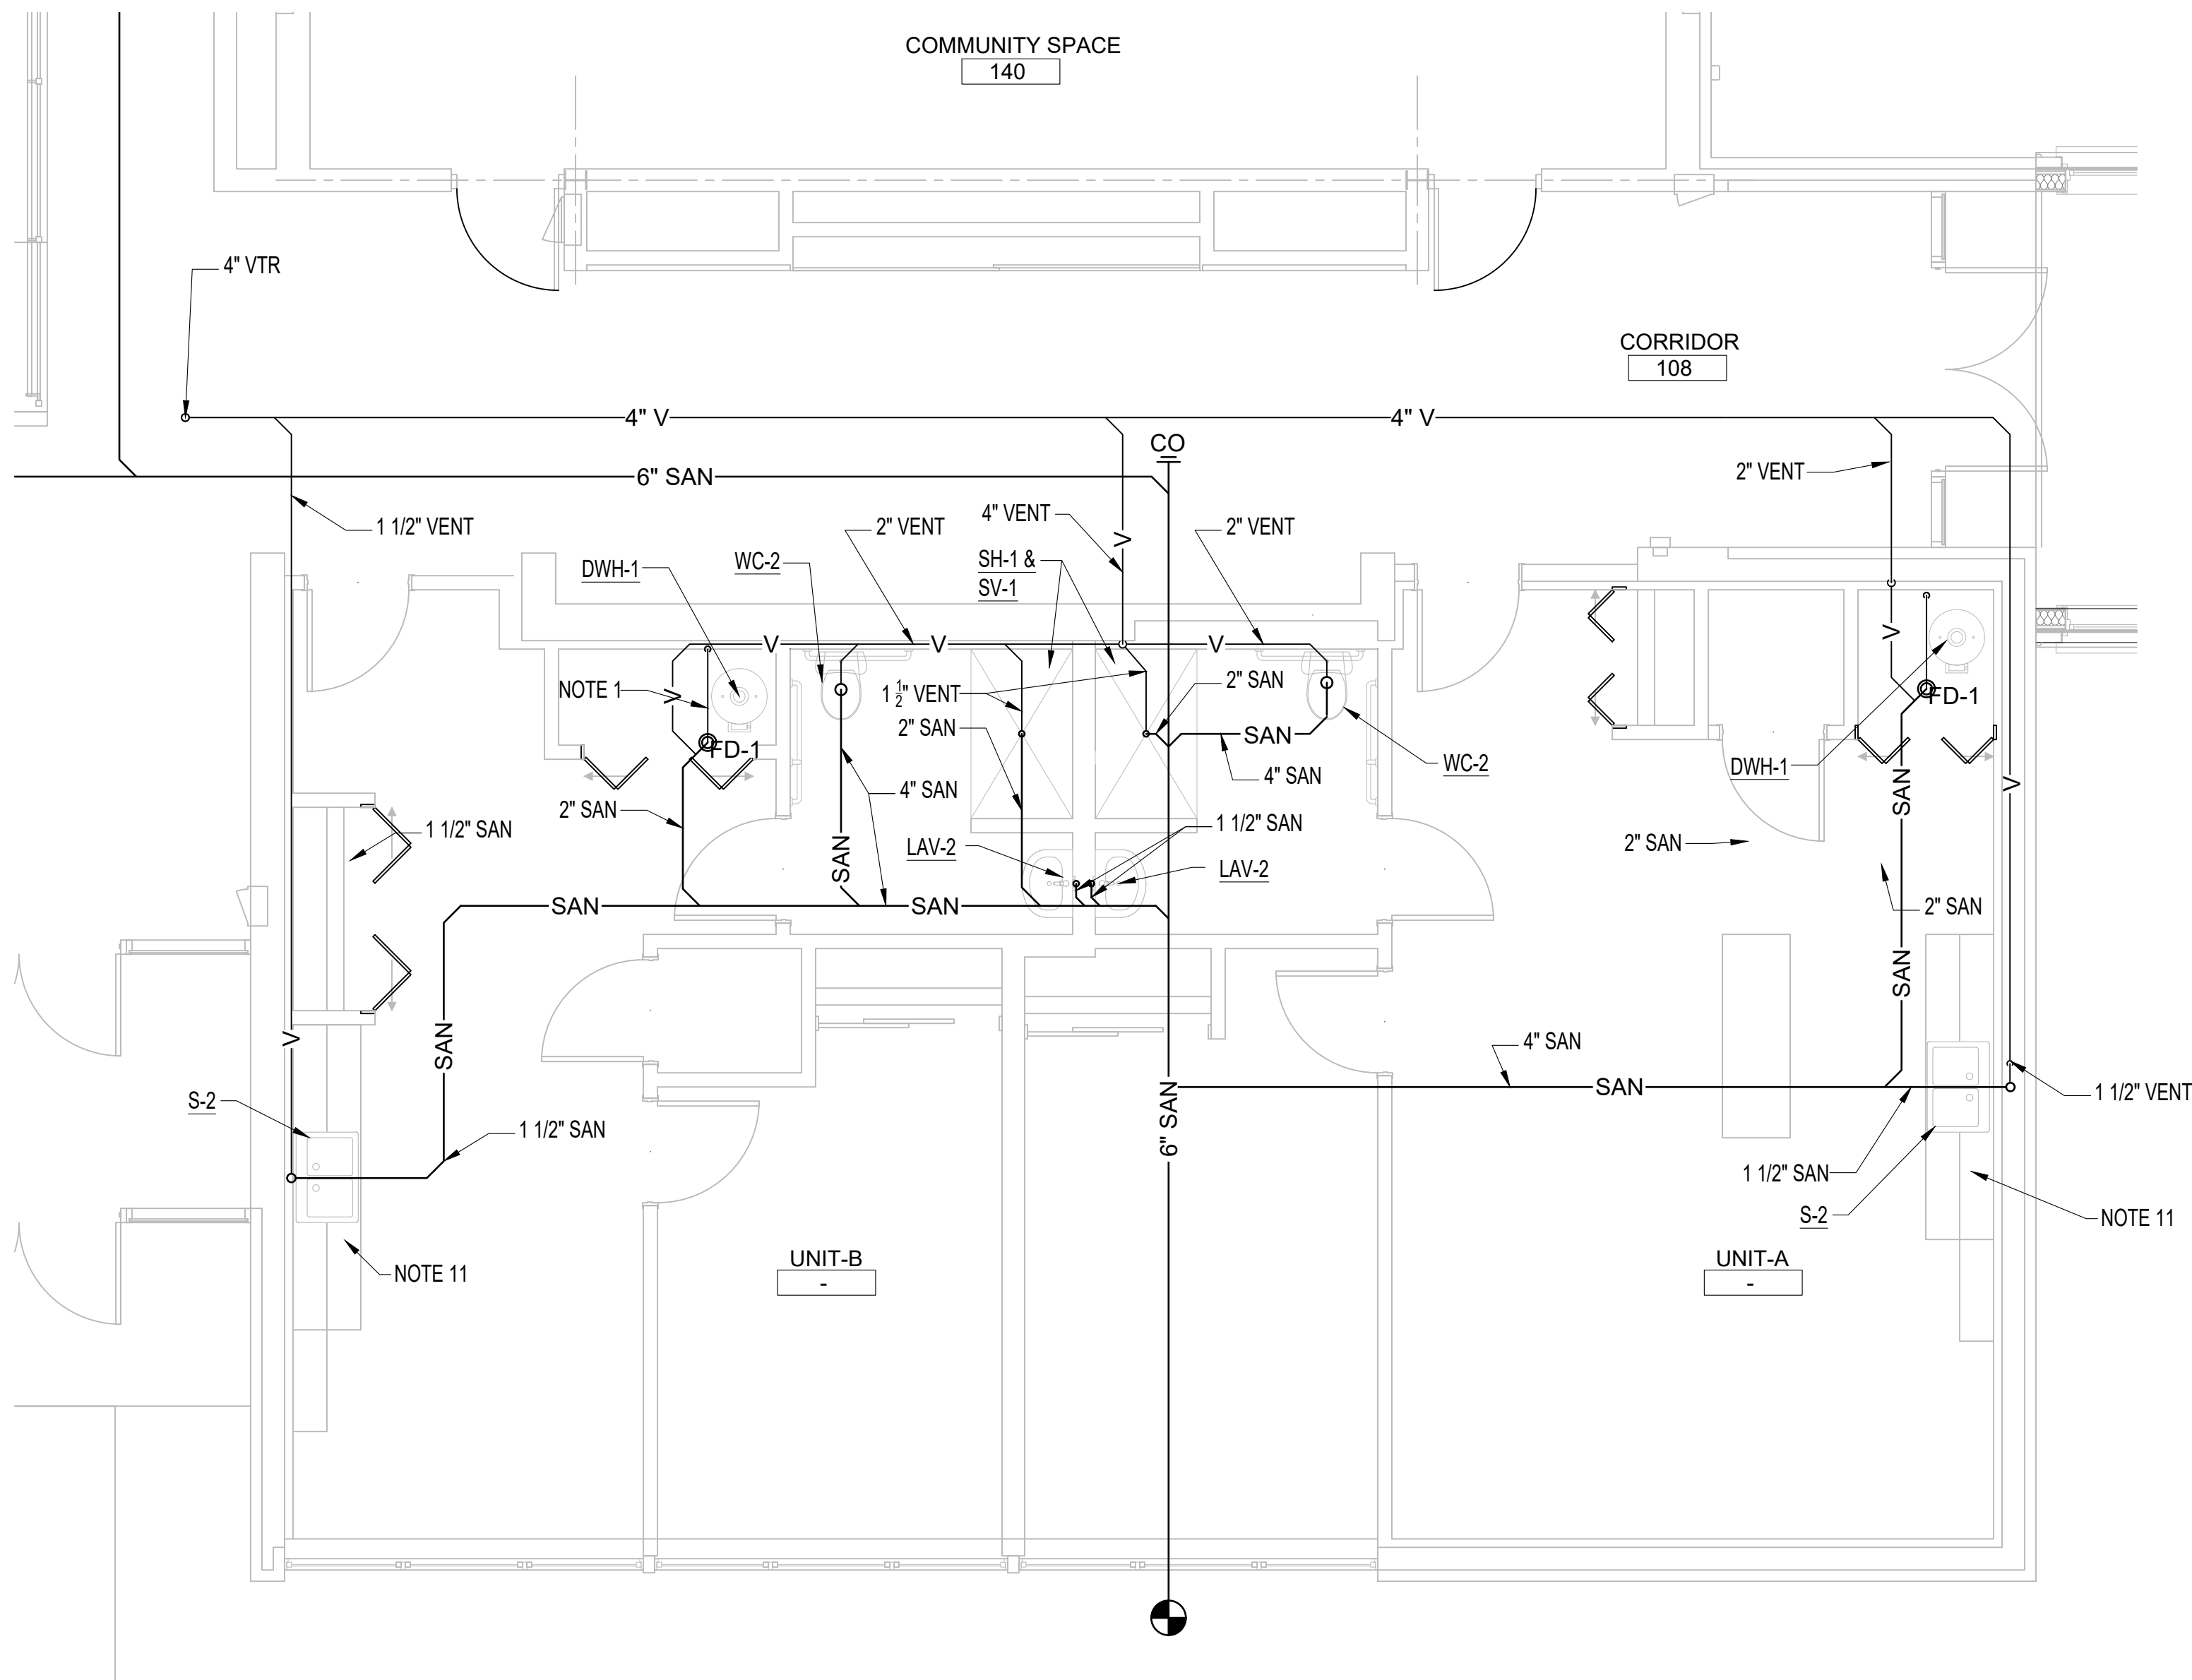

A5 ENLARGED PLUMBING PLANS

P-406

1/4" = 1'-0"

John Grace Arms
21030 Indian St, Southfield MI 48033
Developed by
John Grace Arms LDHA LLC

SDG
Architects + Planners
607 Shelby Street
Suite 704
Detroit, MI 48226
Tel: 313-961-0000
Fax: 313-964-3233



A & A Engineering & Consulting
28862 Vista Way, South Lyon, MI 48178

REGISTRATION SEAL



KEY PLANS

SHEET TITLE
ENLARGED PLUMBING PLANS

SCALE: AS NOTED

ISSUED FOR
PERMIT
DATE
10.20.24

DRAWN BY

CHECKED

APPROVED

21026.00

FILE NO.


P-406

SHEET NO.

A vertical line with points A, B, C, D, E, F, G, H, I, J, K marked from bottom to top.

1. SEE SHEET P-001 FOR PLUMBING NOTES


1. EXTEND CONDENSATE DRAIN TO NEAREST FLOOR DRAIN IN WATER HEATER ROOM.
2. EXISTING NATURAL GAS METER AND REGULATOR BY UTILITY COMPANY. VERIFY EXISTING REGULATOR PRESSURE AND COORDINATE TO ENSURE PROPER PRESSURE IS PROVIDE FOR SERVICE TO NATURAL GAS GENERATOR.
3. VENT UP AND DOWN
4. SANITARY UP AND DOWN AND PROVIDE VERTICAL CLEANOUT.
5. REFER TO TYPICAL APARTMENT WATER RISER DIAGRAM FOR PIPING ARRANGEMENT AND SIZES.
6. CONTRACTOR TO CONTACT MISS DIG PRIOR TO START OF WORK TO DETERMINE UNDERGROUND WORK. COORDINATE WORK WITH CIVIL PLANS.
7. HEAT PUMP HOT WATER, REFER TO MANUFACTURER DRAWINGS FOR PROPER VENTILATION REQUIREMENTS FOR DOOR CLEARANCES AND SPACE BETWEEN UNITS. REFER TO PLUMBING DETAILS FOR HEAT PUMP WATER HEATER PIPING AND EQUIPMENT REQUIRED.
8. GARBAGE DISPOSAL, SEE PLUMBING SCHEDULE FOR SPECIFICATIONS AND INSTALL FOR MANUFACTURER REQUIREMENTS. TO BE CONTROLLED BY SUBMITTAL PLACED ABOVE COUNTER SEE ELECTRICAL.
9. ALL SANITARY LINES ARE BELOW FLOOR ELEVATION TO ALLOW FOR PROPER PITCH AND NEEDED FLOW. EXACT LOCATION OF TUNNEL AND BASEMENT ARE UNKNOWN AND SANITARY COULD BE IN BASEMENT OR TUNNEL. ROUTE TO BE DETERMINED BY PLUMBING. ALL VENTING AND WATER DISTRIBUTION ABOVE FINISH CEILING AS HIGH AS POSSIBLE WITHOUT INTERFERING WITH OTHER TRADES.
10. IF UNIT IS CONSIDERED ADA SUBSTITUT FIXTURES TO ADA TYPE. COORDINATE WITH ARCH DRAWINGS.
11. DISHWASHER - PROVIDE HOT WATER SUPPLY SHUT OFF FROM SINK SUPPLY. PROVIDE SANITARY TO GARBAGE DISPOSAL. COORDINATE LOCATION WITH ARCHITECTURAL.

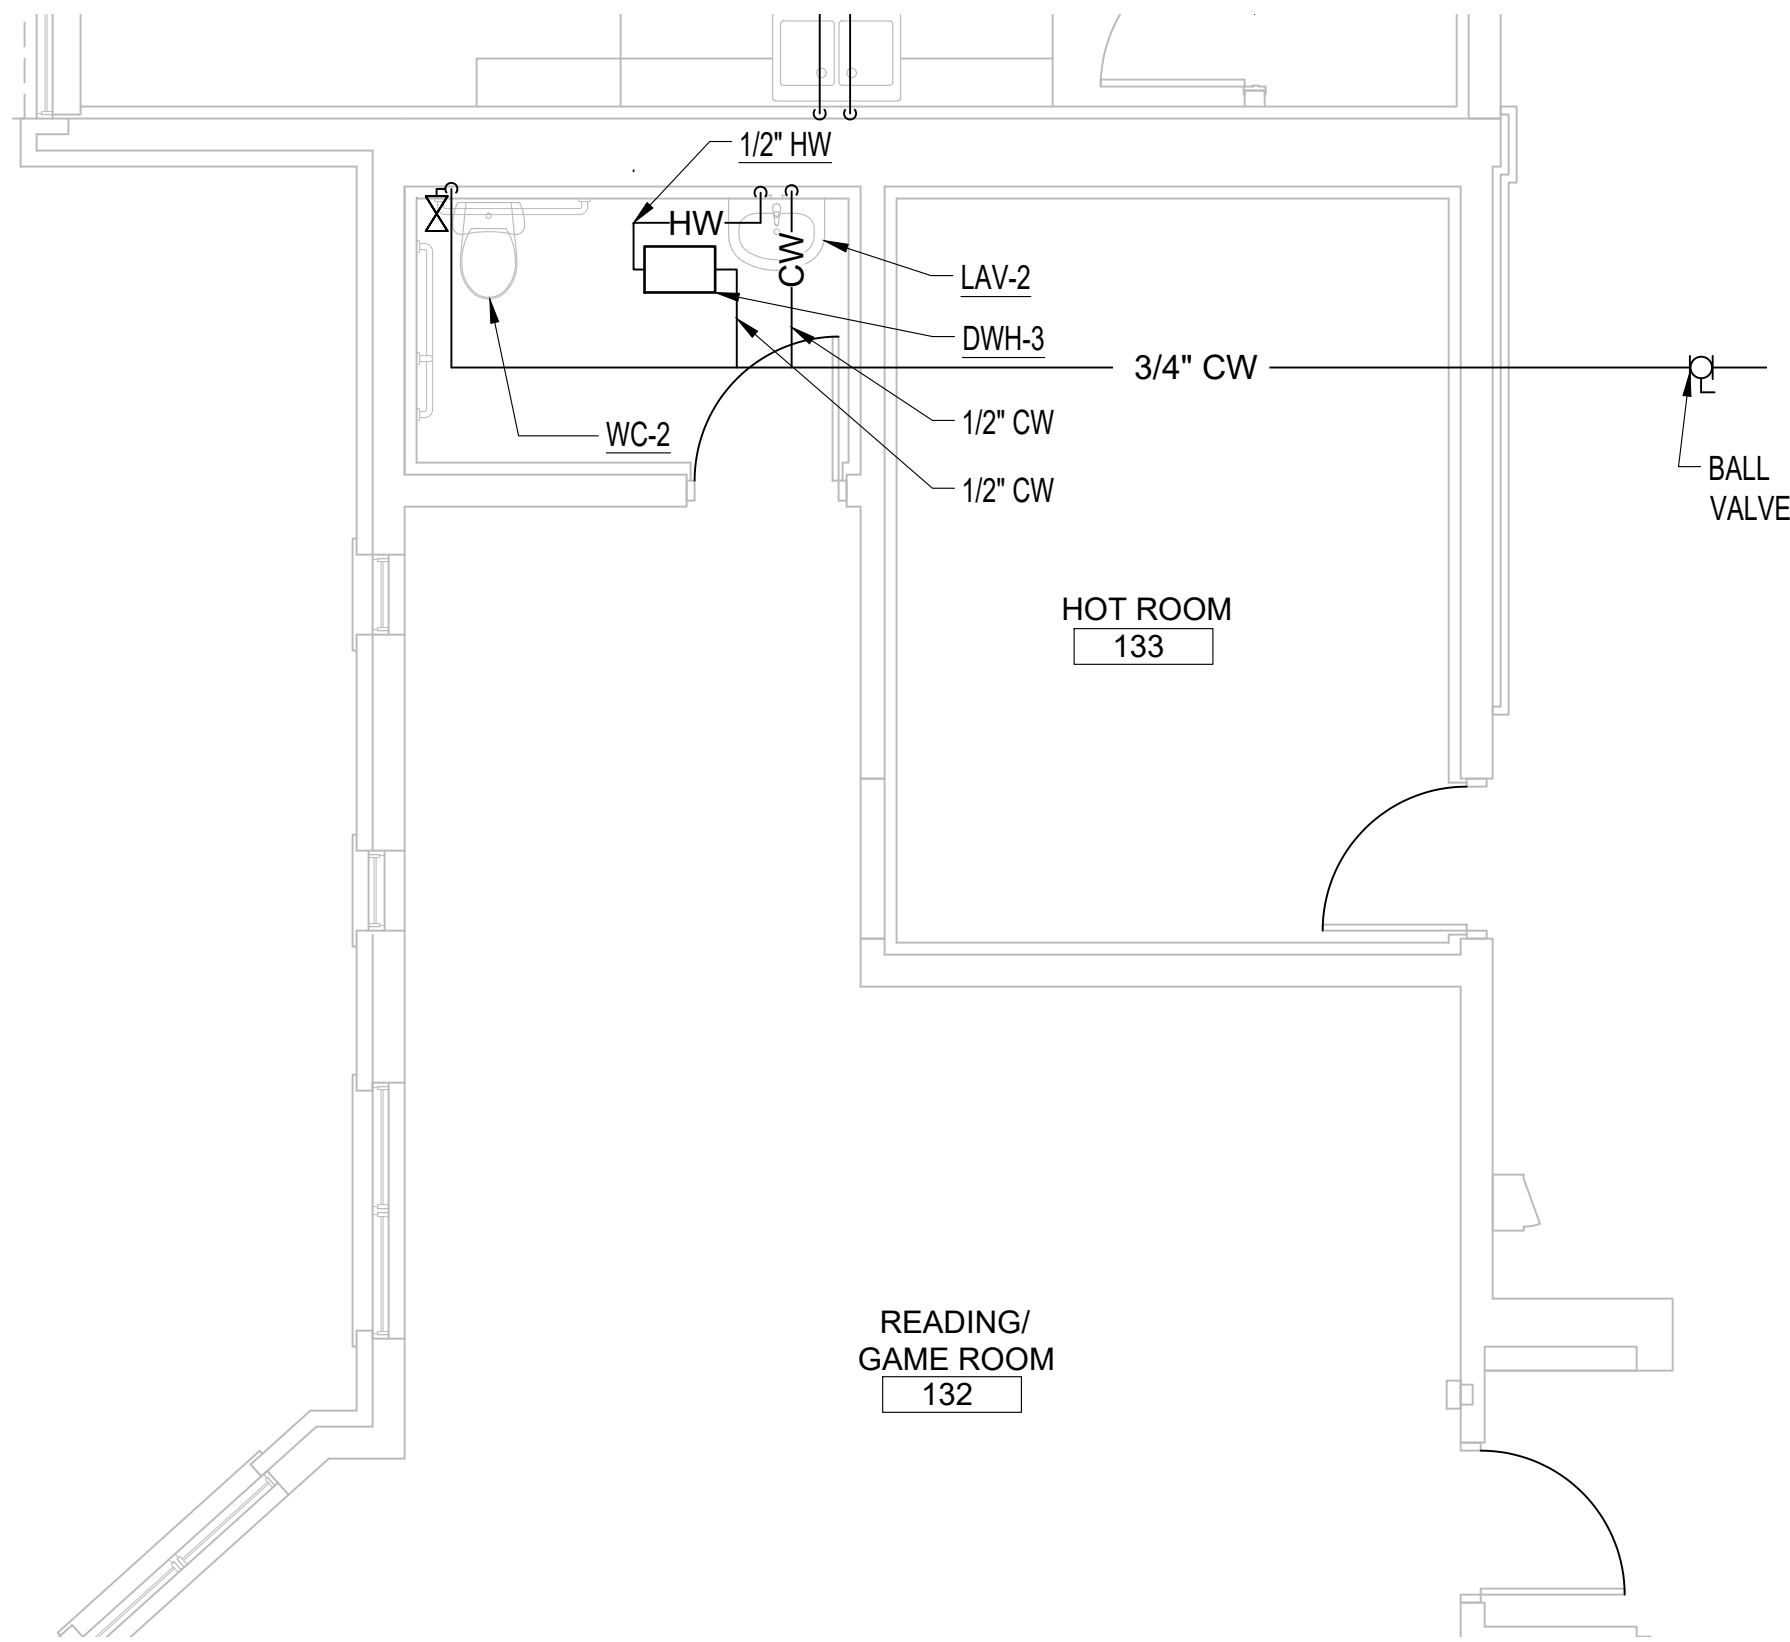

ENLARGED PLUMBING PLANS

$$1/4" = 1'-0"$$


ENLARGED PLUMBING PLANS
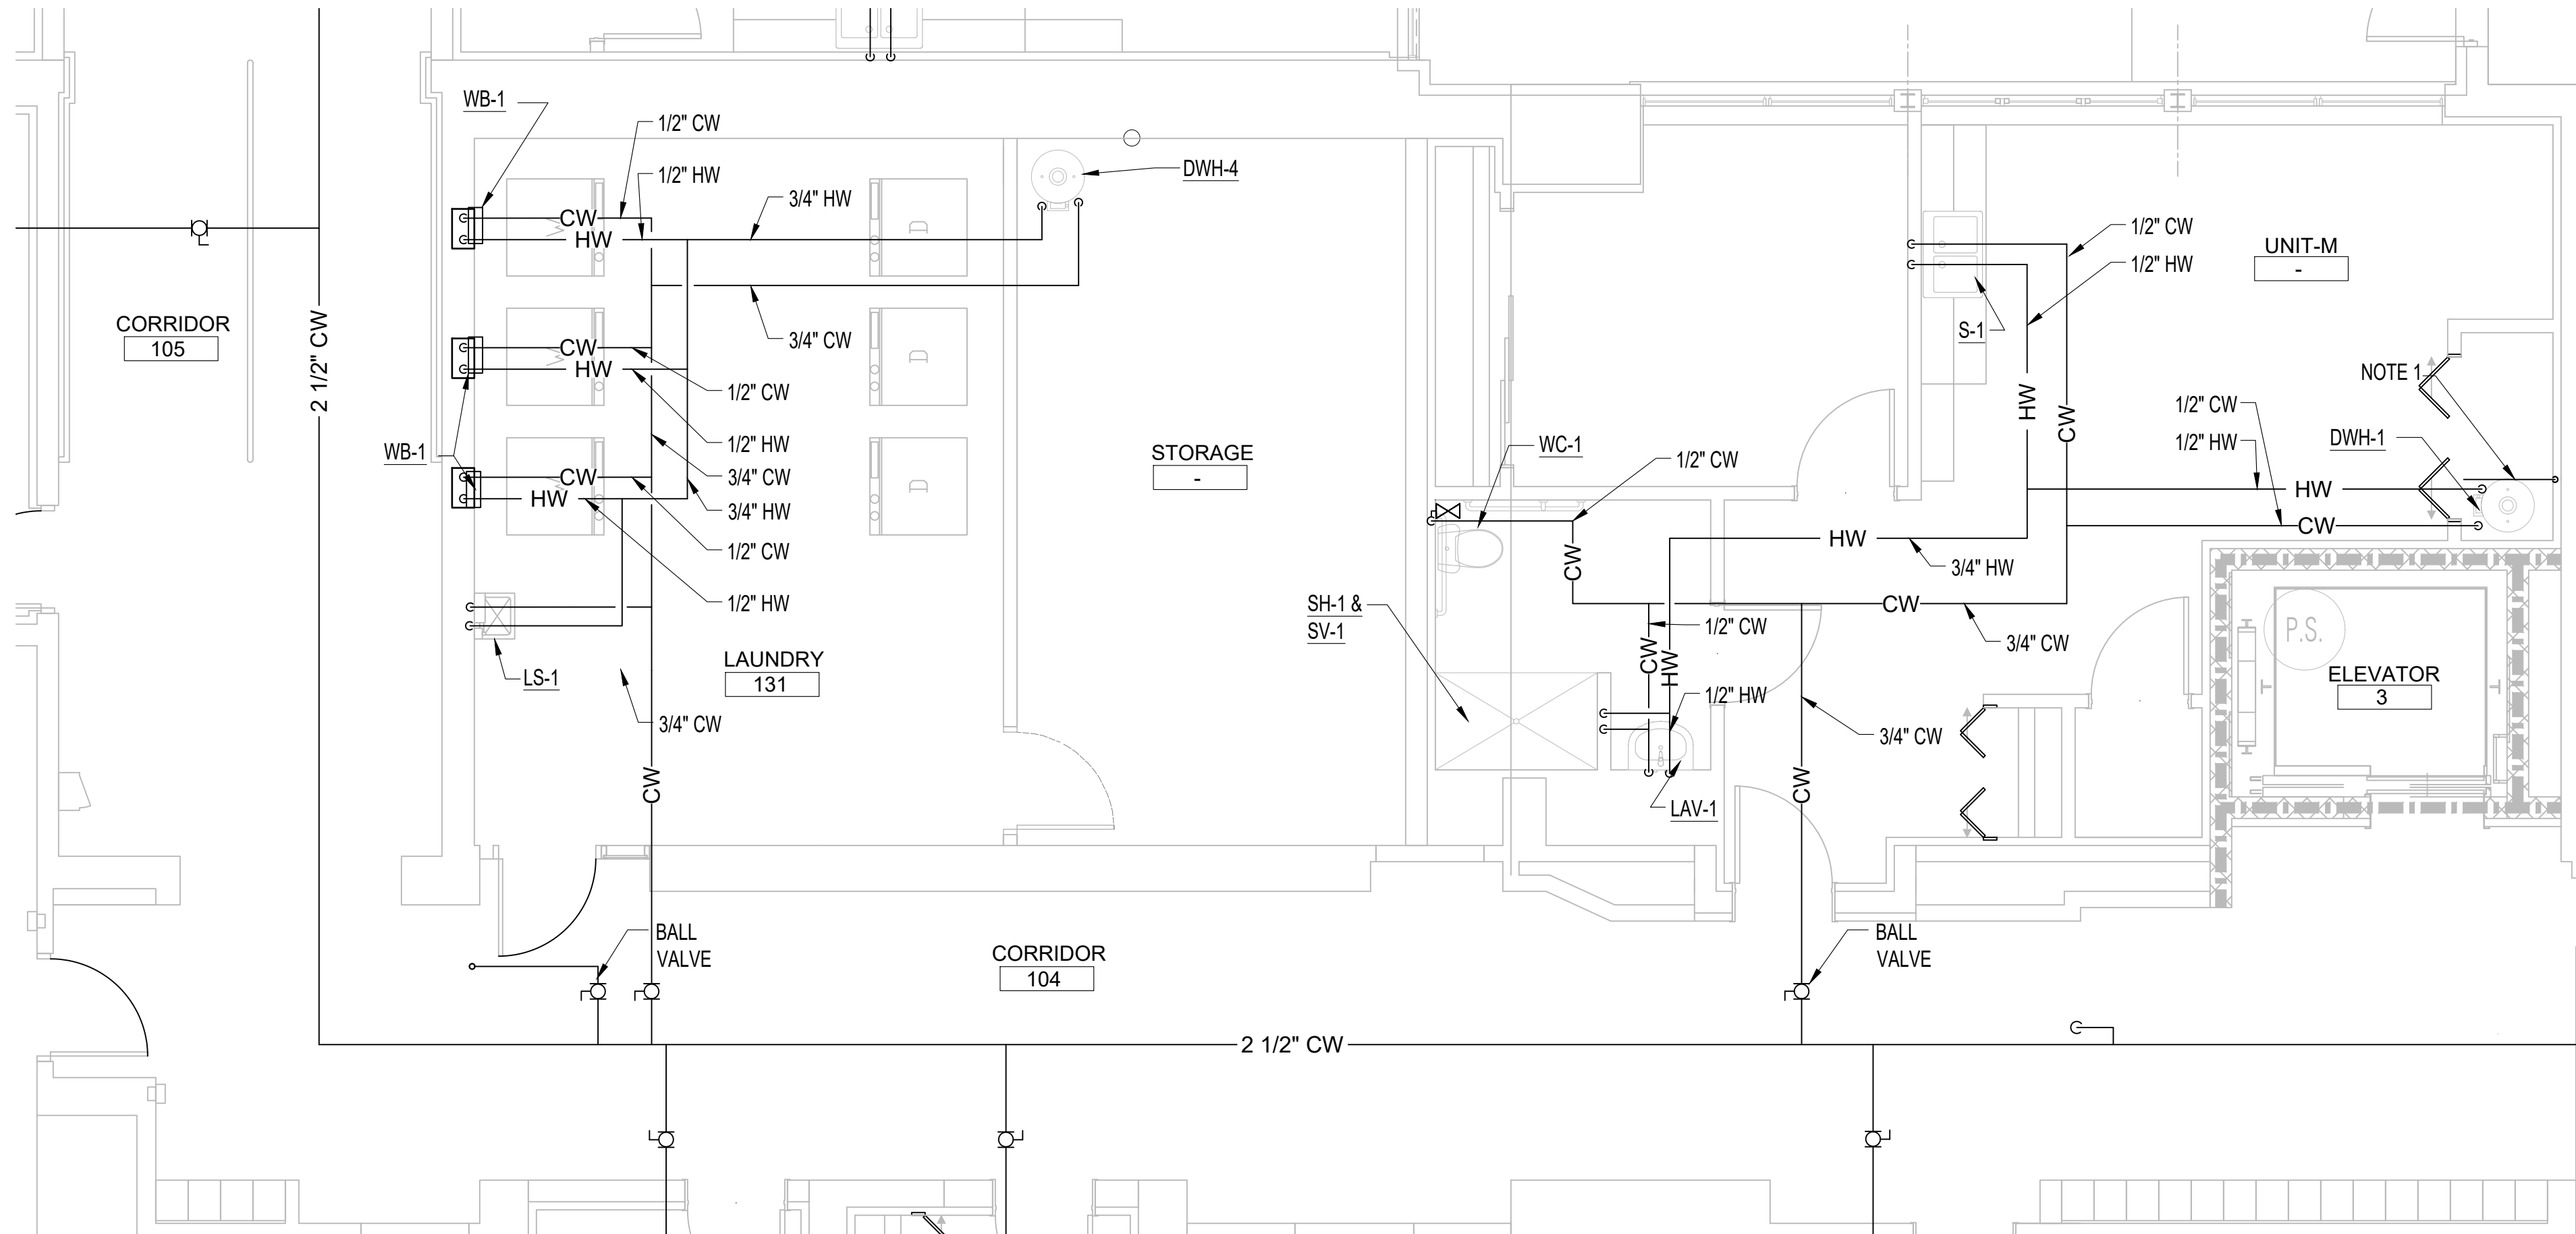
$$1/4'' = 1'-0''$$


ENLARGED PLUMBING PLANS

$$1/4" = 1'-0"$$

1. SEE PLUMBING SHEET NOTES AND SHEET KEYED NOTES ON P-001

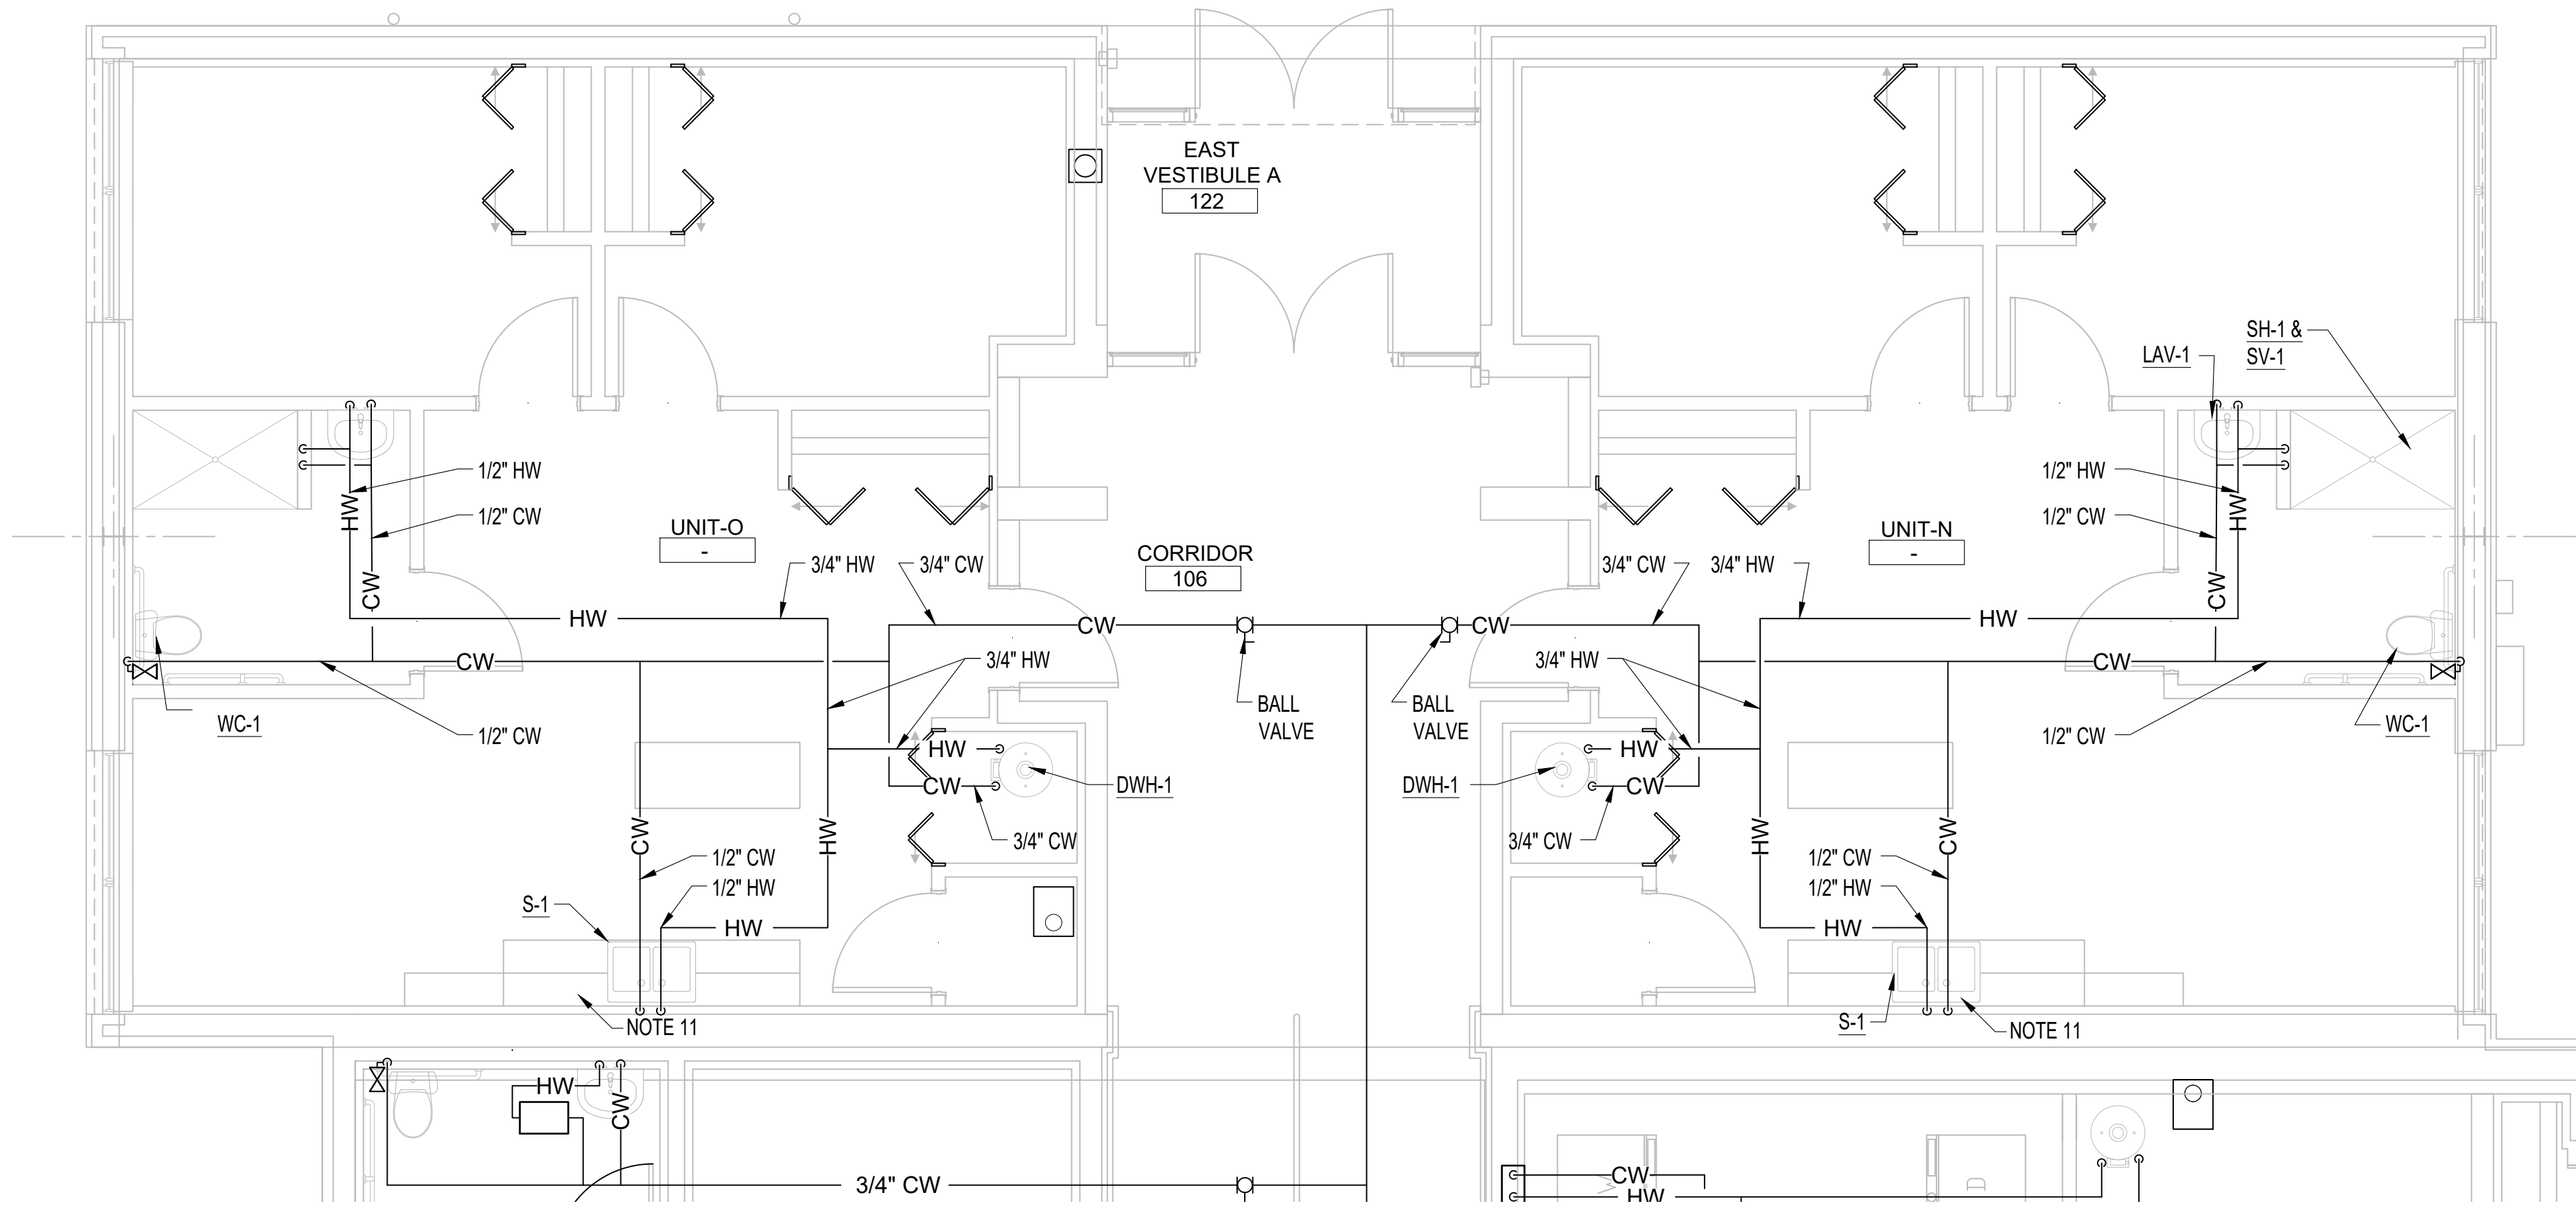

John Grace Arms
21030 Indian St, Southfield MI 48033
Developed by
John Grace Arms LDHA LLC

SDG
Architects + Planners
607 Shelby Street
Suite 704
Detroit, MI 48226
Tel: 313-961-9000
Fax: 313-964-3233



A & A Engineering & Consulting
28862 Vista Way, South Lyon, MI 48178

REGISTRATION SEAL



KEY PLANS

SHEET TITLE

ENLARGED PLUMBING PLANS

SCALE: AS NOTED

ISSUED FOR	DATE
PERMIT	10.20.24

DRAWN BY


CHECKED

APPROVED

FILE NO.

SHEET NO.

P-407

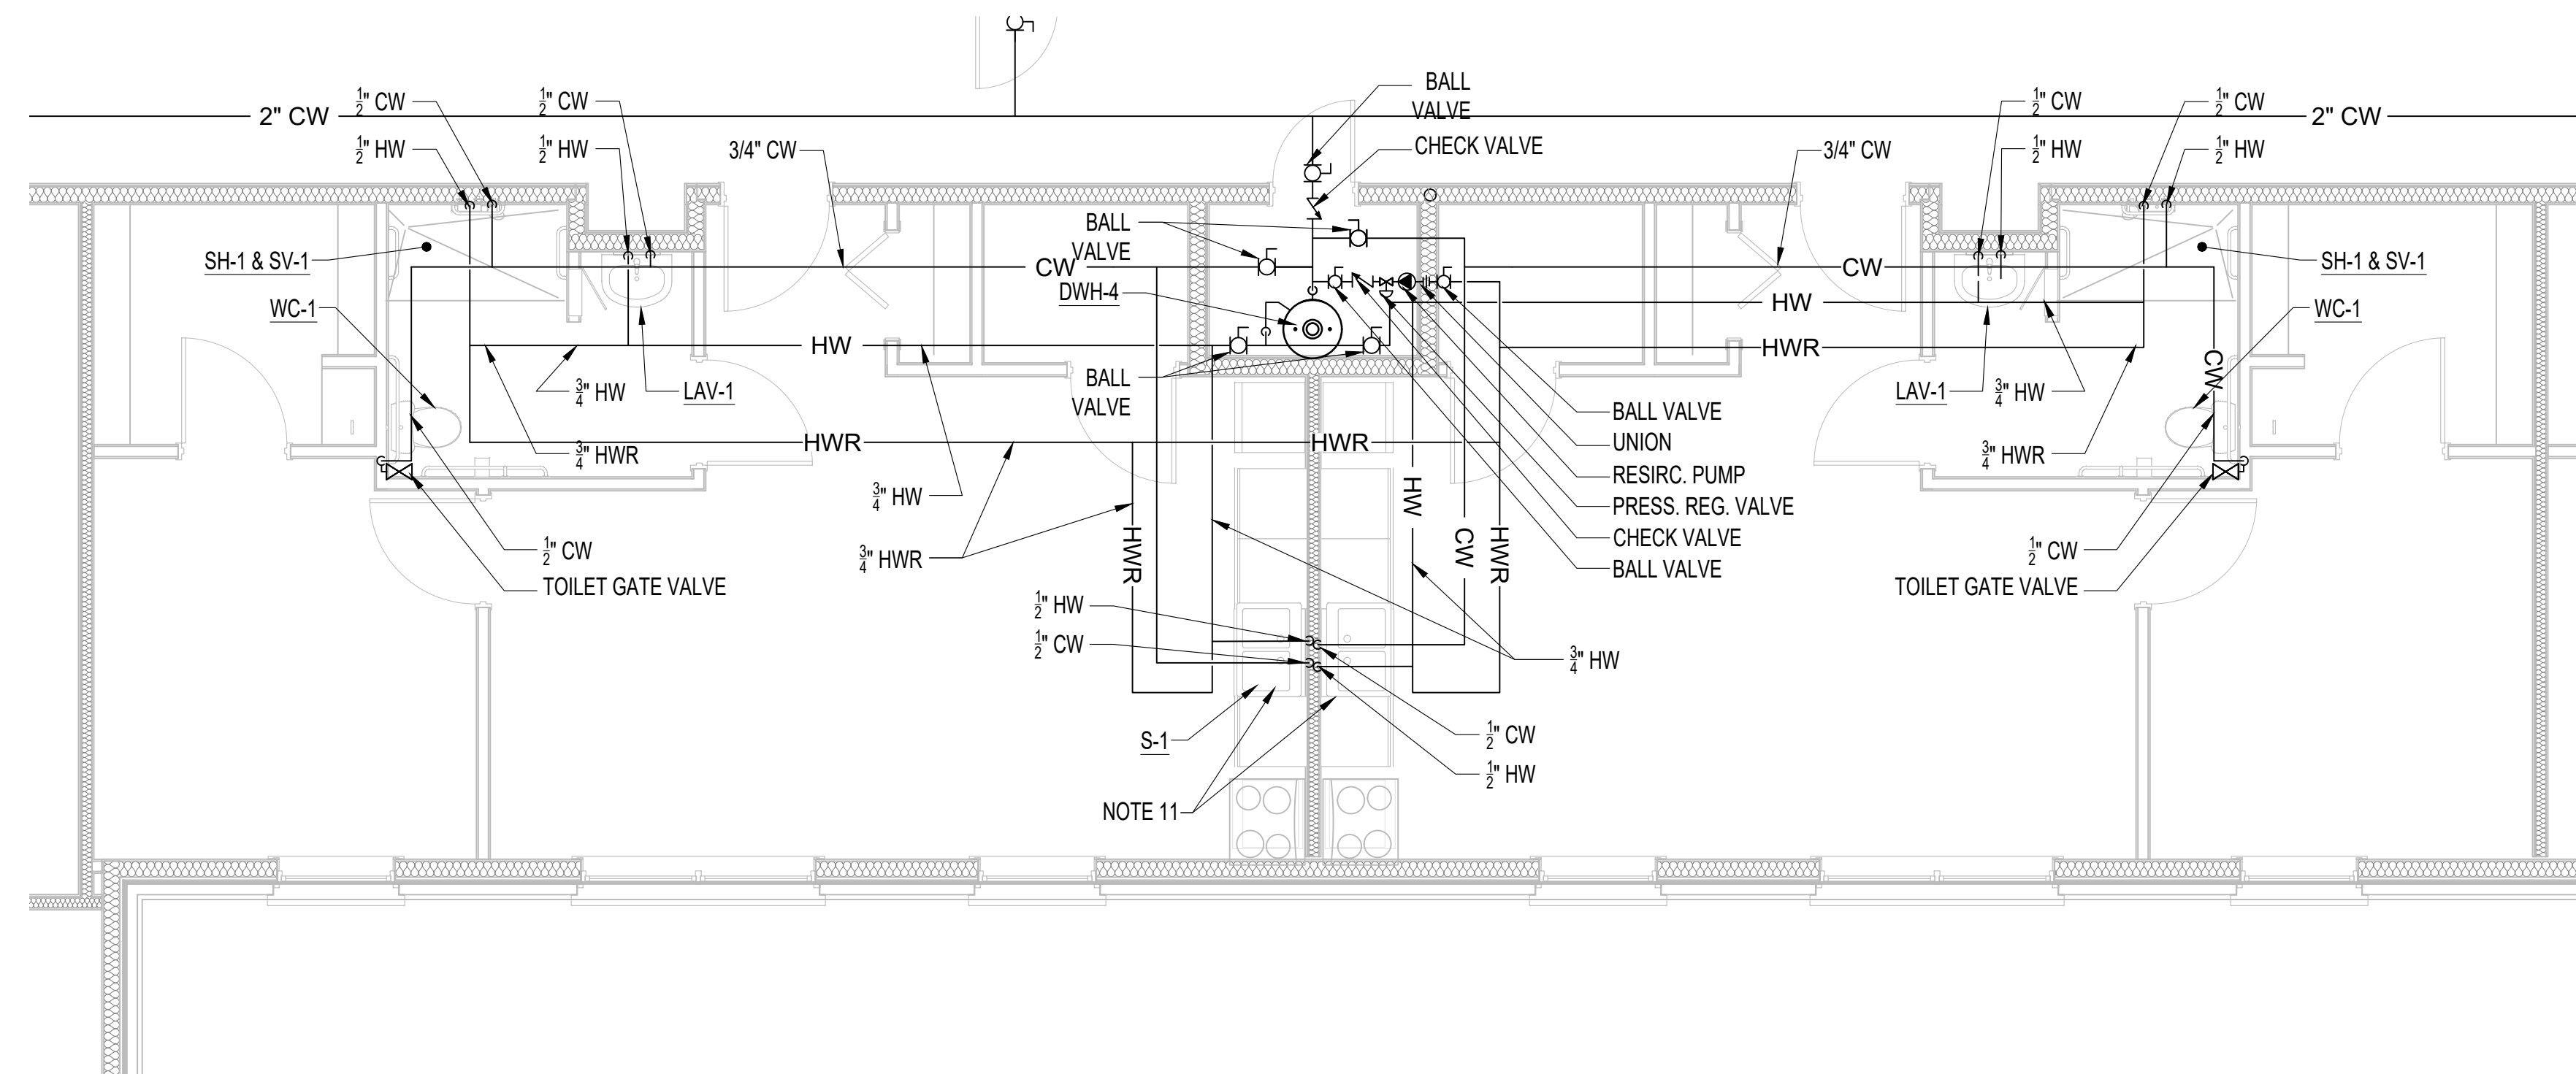

GENERAL


1. SEE SHEET P-001 FOR PLUMBING NOTES

PLUMBING SHEET KEYED NOTES:

1. EXTEND CONDENSATE DRAIN TO NEAREST FLOOR DRAIN IN WATER HEATER ROOM.
2. EXISTING NATURAL GAS METER AND REGULATOR BY UTILITY COMPANY. VERIFY EXISTING REGULATOR PRESSURE AND COORDINATE TO ENSURE PROPER PRESSURE IS PROVIDED FOR SERVICE TO NATURAL GAS GENERATOR.
3. VENT UP AND DOWN
4. SANITARY UP AND DOWN AND PROVIDE VERTICAL CLEANOUT.
5. REFER TO TYPICAL APARTMENT WATER RISER DIAGRAM FOR PIPING ARRANGEMENT AND SIZES.
6. CONTACT OWNER TO CONTACT MISS DIG PRIOR TO START OF ANY UNDERGROUND WORK. COORDINATE WORK WITH CIVIL PLANS.
7. HEAT PUMP HOT WATER, REFER TO MANUFACTURER DRAWINGS FOR PROPER VENTILATION REQUIREMENTS FOR DOOR CLEARANCES AND SPACE REQUIREMENTS. REFER TO PLUMBING DETAILS FOR HEAT PUMP WATER HEATER PIPING AND EQUIPMENT REQUIRED.
8. GARBAGE DISPOSAL, SEE PLUMBING SCHEDULE FOR SPECIFICATIONS AND INSTALL FOR MANUFACTURER REQUIREMENTS. TO BE CONTROLLED BY SUB CONTRACTOR LOCATED ABOVE COUNTER SEE ELECTRICAL.
9. ALL SANITARY LINES ARE BELOW FLOOR ELEVATION TO ALLOW FOR PROPER PITCH AND NEEDED FLOW. EXACT LOCATION OF TUNNEL AND BASEMENT ARE UNKNOWN AND SANITARY COULD BE BASEMENT OR TUNNEL ROUTE IN A WATER MINIMIZING DRAINING. ALL VENTING AND WATER DISTRIBUTION ABOVE FINISH CEILING AS HIGH AS POSSIBLE WITHOUT INTERFERING WITH OTHER TRADES.
10. IF UNIT IS CONSIDERED ADA SUBSTITUTE FIXTURES TO ADA TYPE. COORDINATE WITH OWNER AND DRINKING WATER.
11. DISHWASHER - PROVIDE HOT WATER SUPPLY AND SHUT OFF FROM SINK SUPPLY. PROVIDE SANITARY TO GARBAGE DISPOSAL. COORDINATE LOCATION WITH ARCHITECTURAL.

G5 ENLARGED PLUMBING PLANS

P-409	1/4" = 1'-0"
-------	--------------

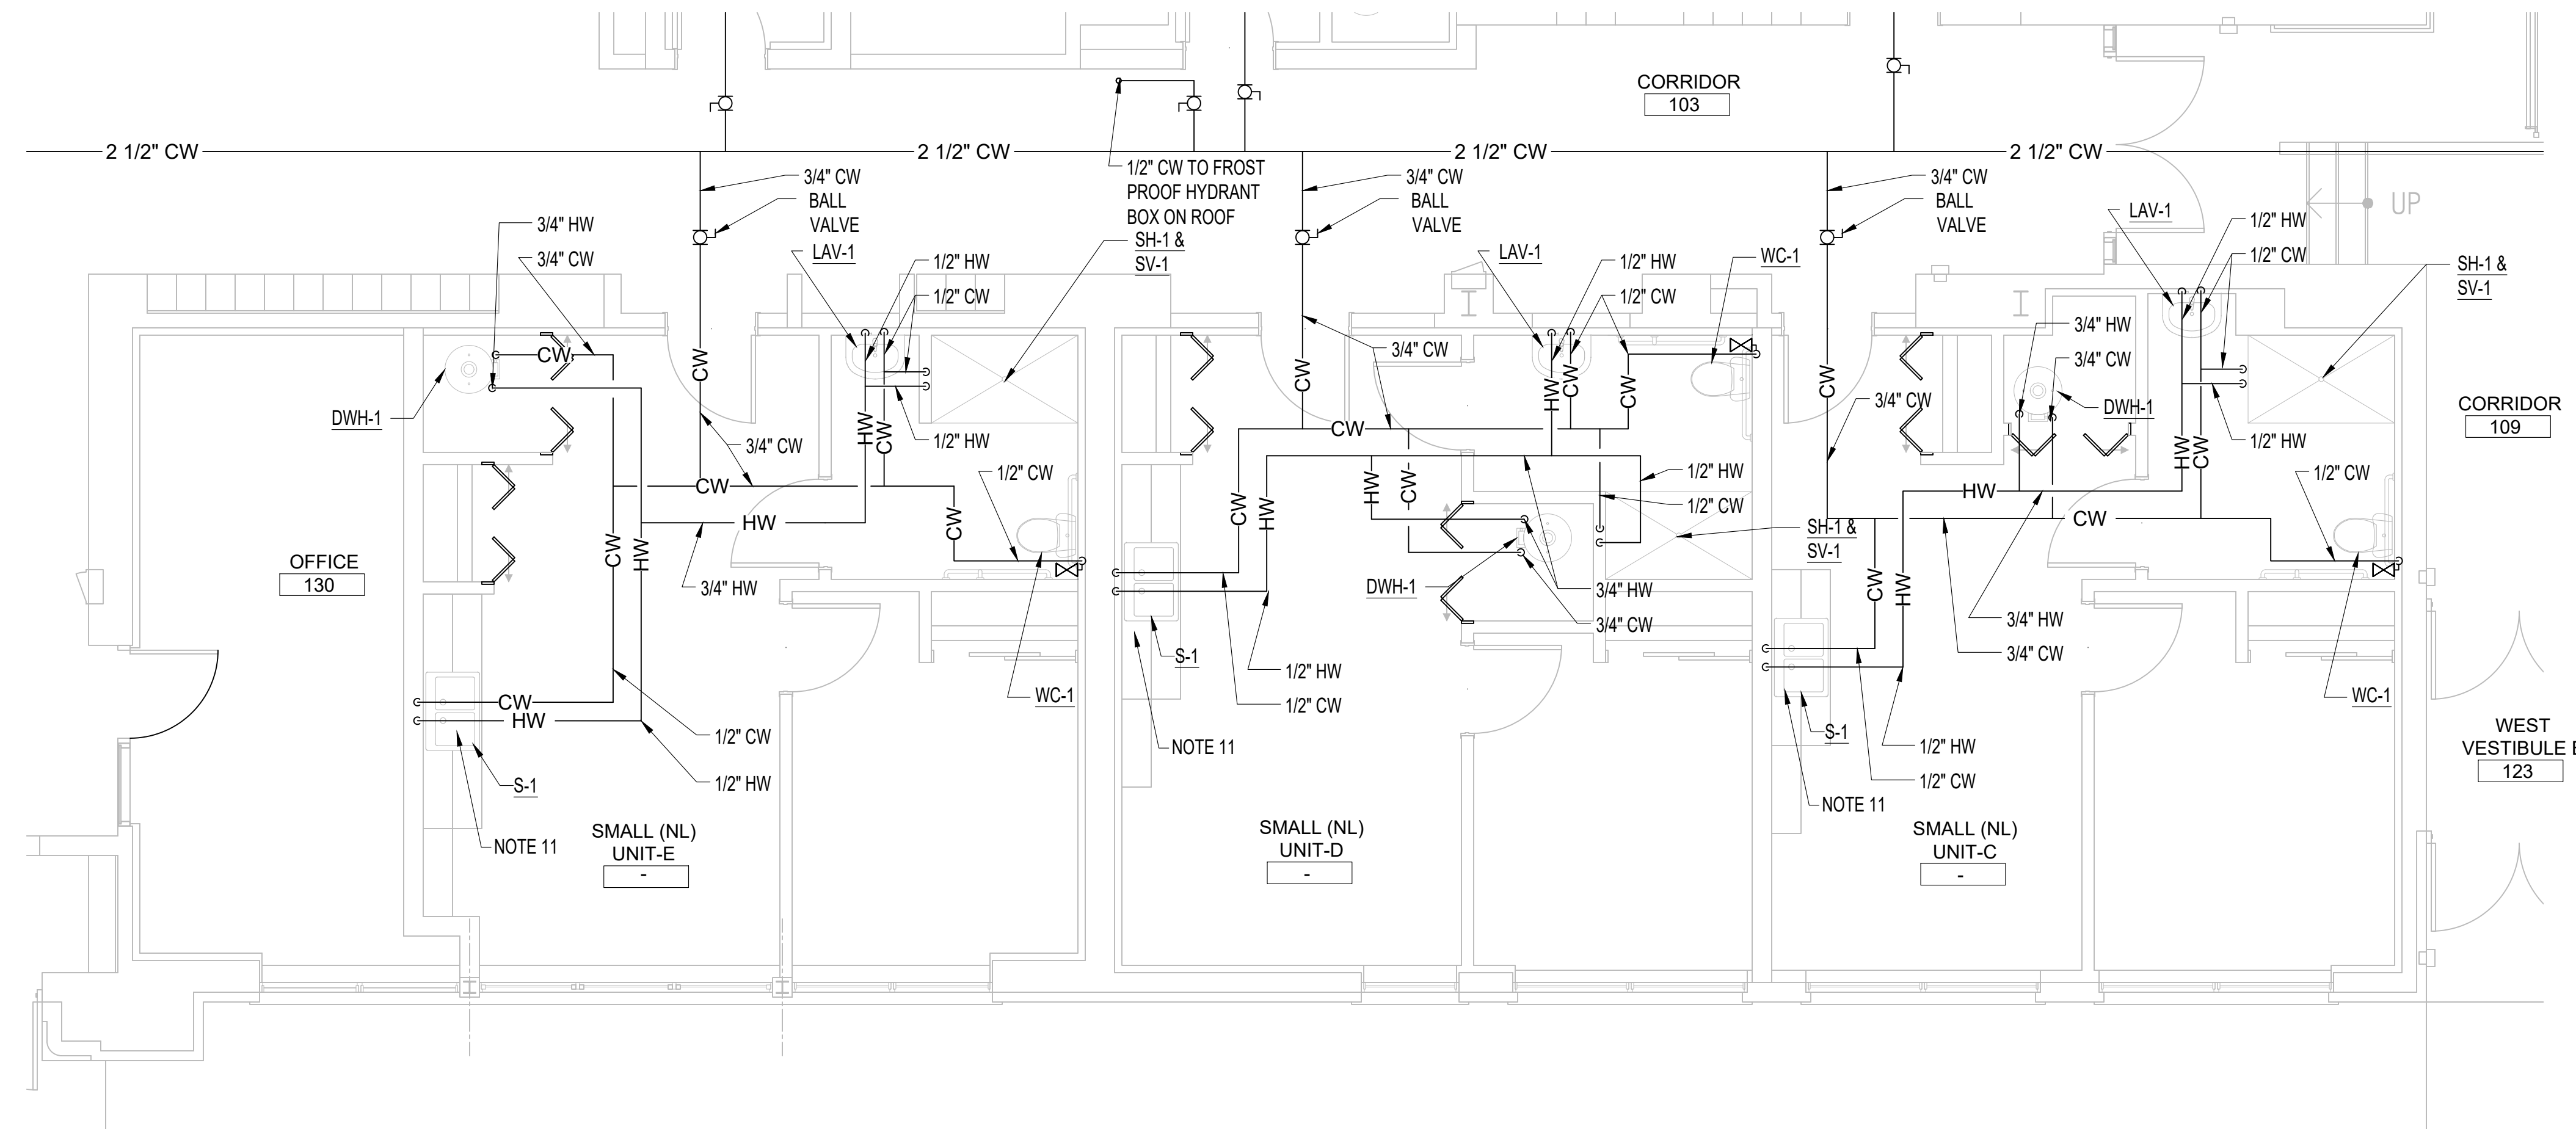

A5 ENLARGED PLUMBING PLANS

P-409	1/4" = 1'-0"
-------	--------------

John Grace Arms
21030 Indian St, Southfield MI 48033
Developed by
John Grace Arms LDHA LLC

SDG
Architects + Planners

607 Shelby Street
Suite 704
Detroit, MI 48226

Tel: 313-961-9000
Fax: 313-964-3233



A & A Engineering & Consulting
28862 Vista Way, South Lyon, MI 48178

REGISTRATION SEAL



KEY PLANS

SHEET TITLE

ENLARGED PLUMBING PLANS

SCALE: AS NOTED

ISSUED FOR	DATE
PERMIT	10.20.24

DRAWN BY _____

CHECKED

APPROVED

21026.00

FILE NO. _____

P-409


SHEET NO. _____

1. SEE SHEET **P-001** FOR PLUMBING NOTES

PLUMBING SHEET KEYED NOTES


PLUMBING SHEET KEYED NOTES

1. EXTEND CONDENSATE DRAIN TO NEAREST FLOOR DRAIN IN WATER HEATER ROOM.
2. EXISTING NATURAL GAS METER AND REGULATOR BY UTILITY COMPANY. VERIFY EXISTING REGULATOR PRESSURE AND COORDINATE TO ENSURE PROPER PRESSURE IS PROVIDED FOR SERVICE TO NATURAL GAS GENERATOR.
3. VENT UP AND DOWN
4. SANITARY UP AND DOWN AND PROVIDE VERTICAL CLEANOUT.
5. REFER TO TYPICAL APARTMENT WATER RIGID PROGRAM FOR PIPING ARRANGEMENT AND SPACE REQUIREMENTS.
6. CONTRACTOR TO CONTACT MISS DIG PRIOR TO START OF ANY UNDERGROUND WORK, COORDINATE WORK WITH CIVIL PLANS.
7. HEAT PUMP HOT WATER, REFER TO MANUFACTURER DRAWINGS FOR PROPER VENTILATION REQUIREMENTS FOR CLEARANCES AND SPACE REQUIREMENTS. REFER TO PLUMBING DETAILS FOR HEAT PUMP WATER HEATER PIPING AND EQUIPMENT REQUIRED.
8. GARBAGE DISPOSAL, SEE PLUMBING SCHEDULE FOR SPECIFICATIONS AND INSTALL FOR MANUFACTURER SPECIFICATIONS. TO BE CONTROLLED BY SWITCH LOCATED ABOVE COUNTER SEE ELECTRICAL.
9. ALL SANITARY LINES ARE BELOW FLOOR ELEVATION TO ALLOW FOR PROPER PITCH AND NEEDED FLOW. EXACT LOCATION OF TUNNEL AND BASEMENT ARE UNKNOWN AND SANITARY COULD BE LOCATED AT OR BELOW LEVEL. ROUTE IN A WAY TO MINIMIZE CORING. ALL VENTING AND WATER DISTRIBUTION ABOVE FINISH CEILING AS HIGH AS POSSIBLE WITHOUT INTERFERING WITH OTHER TRADES.
10. IF UNIT IS CONSIDERED ADA SUBSTITUTE FINISHES TO ADA TYPE. COORDINATE WITH ARCHITECTURAL DRAWING.
11. DISHWASHER - PROVIDE HOT WATER SUPPLY AND SHUT OFF FROM SINK SUPPLY. PROVIDE SANITARY TO GARBAGE DISPOSAL. COORDINATE LOCATION WITH ARCHITECTURAL.

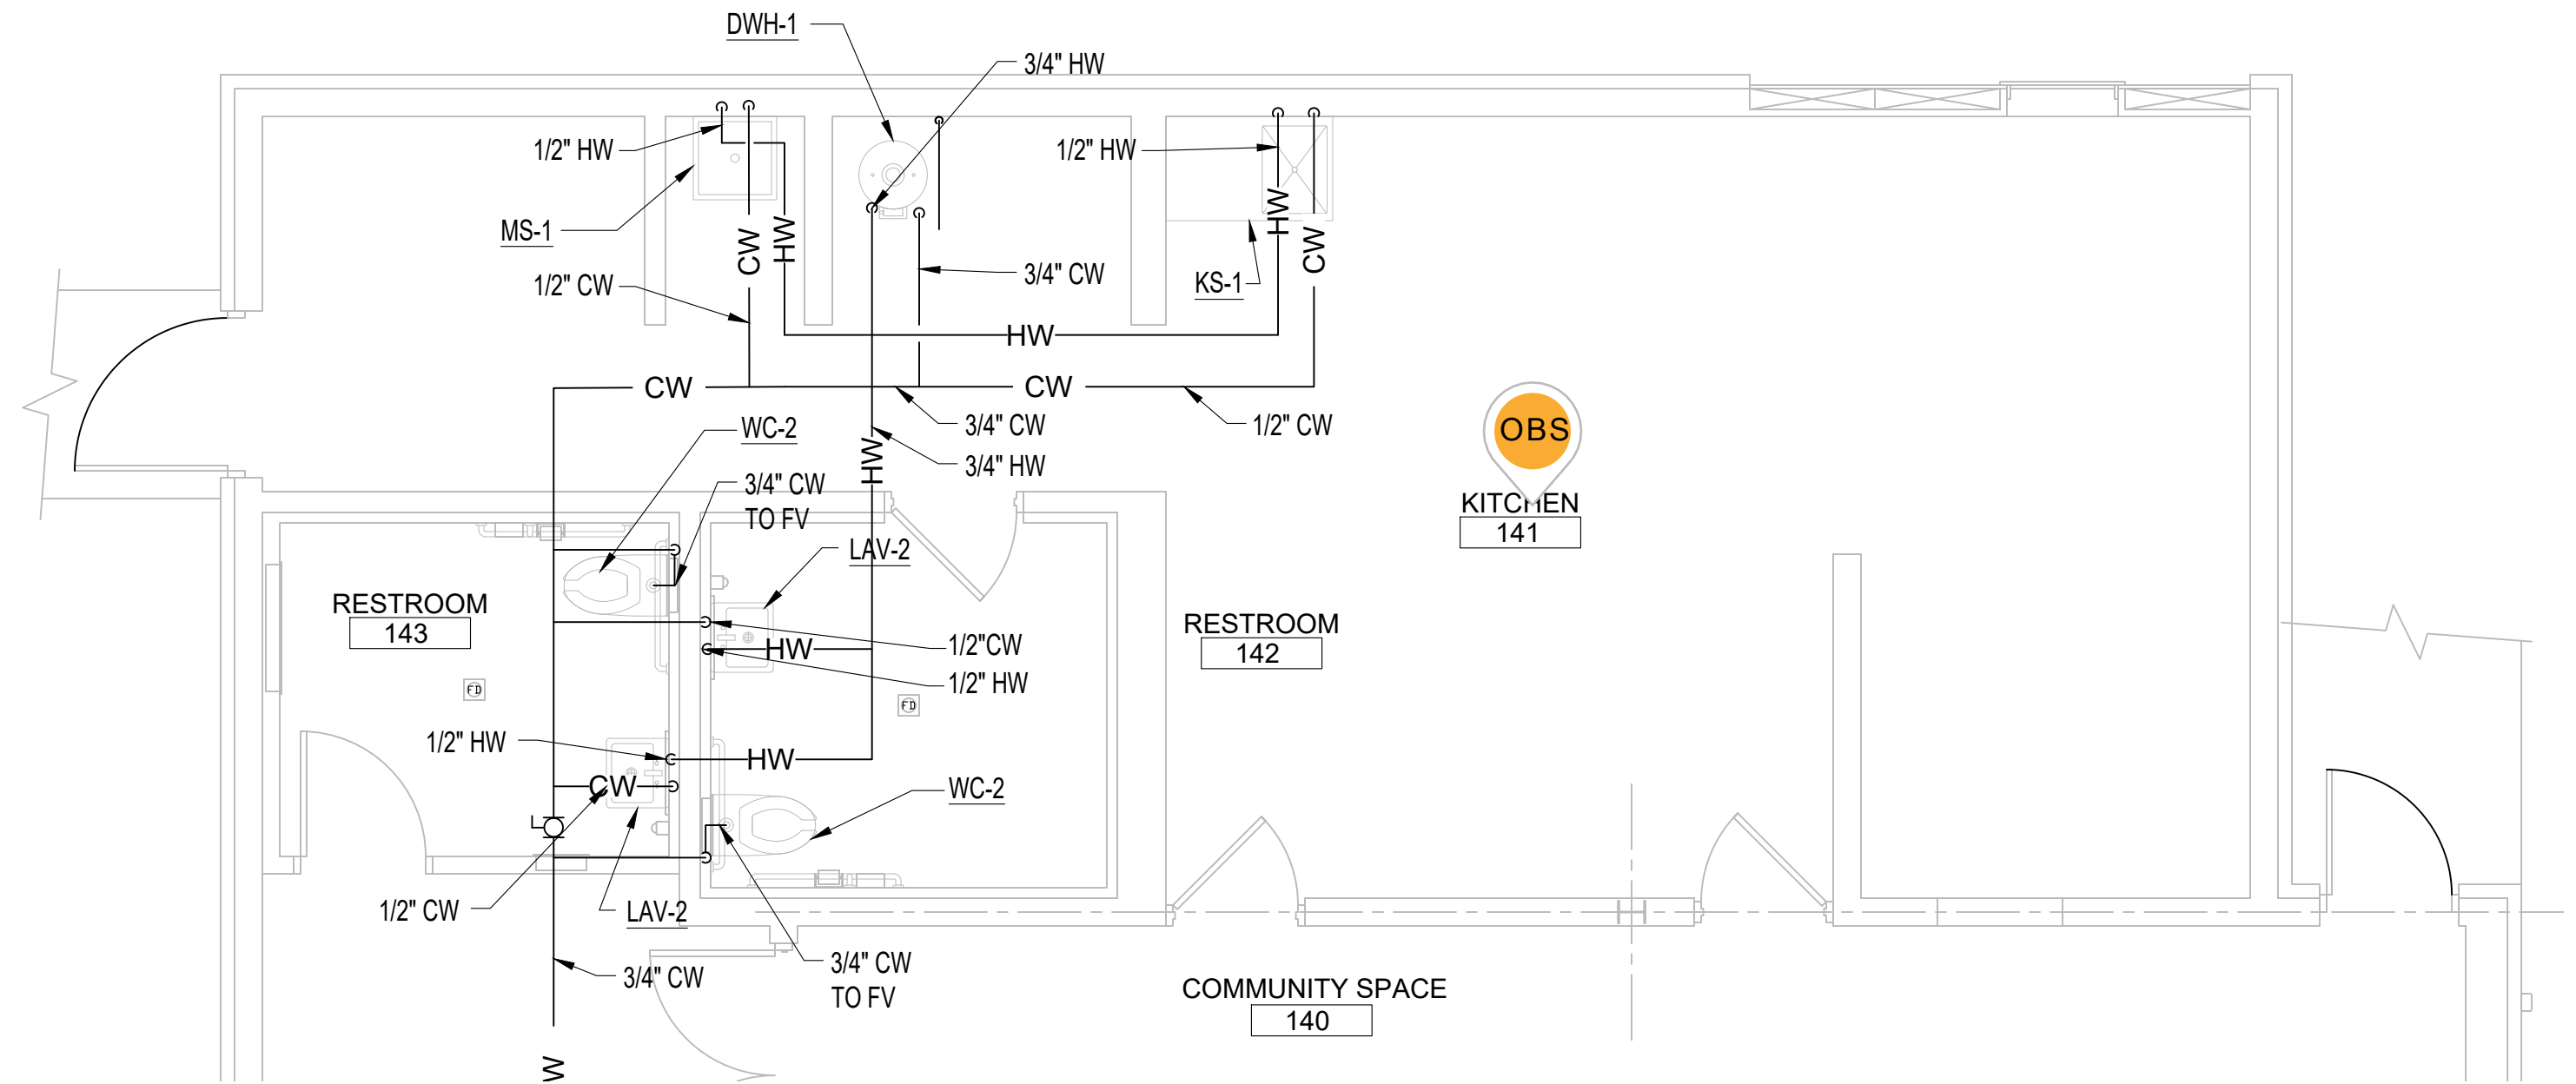

H8 ENLARGED PLUMBING PLANS

P-410
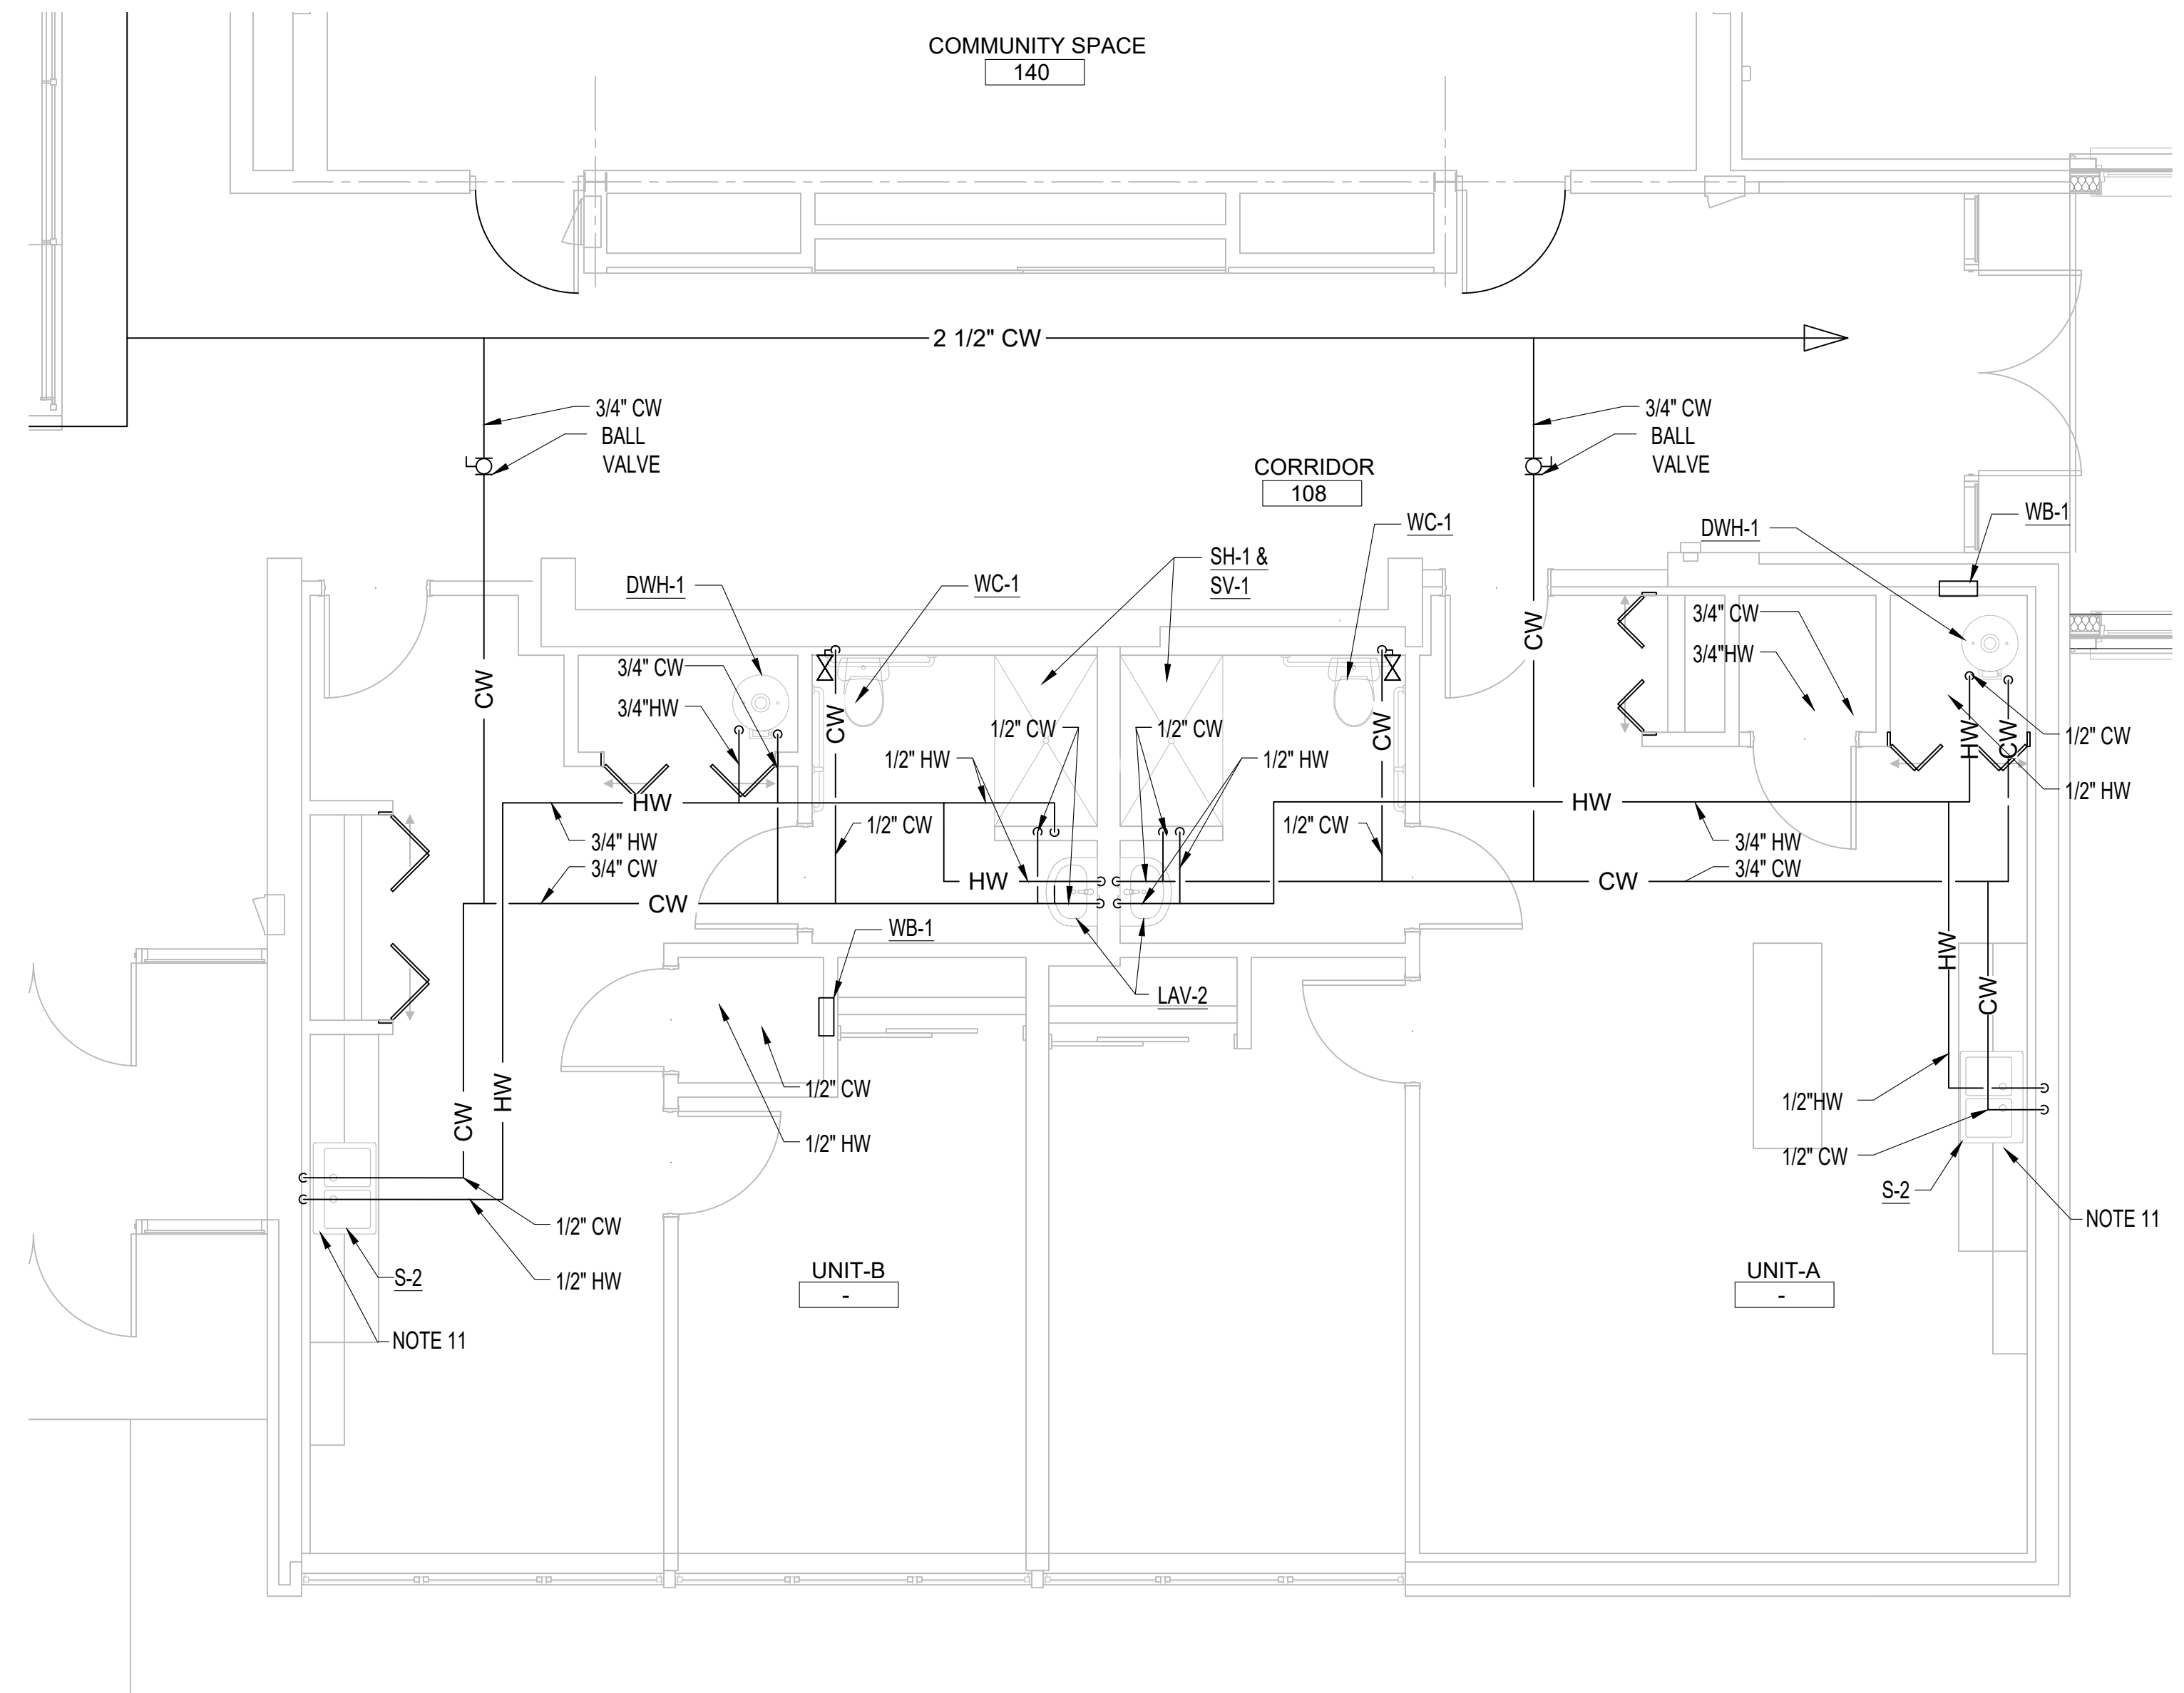
$$1/4" = 1'-0"$$


A5 ENLARGED PLUMBING PLANS

P-410

$$1/4" = 1'-0"$$

John Grace Arms
1030 Indian St, Southfield MI 48033
Developed by
John Grace Arms LDHA LLC

SDG
Architects + Planners
17 Shelby Street
Suite 704
Detroit, MI 48226
Tel: 313-961-9000
Fax: 313-964-3233



& A Engineering & Consulting
28862 Vista Way, South Lyon, MI 48178

REGISTRATION SEAL



KEY PLANS

ENLARGED PLUMBING PLANS

SCALE: AS NOTED

ISSUED FOR	DATE
PERMIT	10.20.24

OWN BY _____

CKED

PROVED

NO. _____

ET NO. _____

21026.00

P-410

John Grace Arms
21030 Indian St, Southfield MI 48033
Developed by
John Grace Arms LDHA LLC

SDG
Architects + Planners

607 Shelby Street
Suite 704
Detroit, MI 48226

Tel: 313-961-9000
Fax: 313-964-3233



A & A Engineering & Consulting
28862 Vista Way, South Lyon, MI 48178

REGISTRATION SEAL



KEY PLANS

SHEET TITLE

ENLARGED PLUMBING
PLANS

SCALE: AS NOTED

ISSUED FOR	DATE
PERMIT	10.20.24
<u>Δ BULLETIN 3</u>	5.19.25

DRAWN BY _____

CHECKED


APPROVED _____

21026.00

FILE NO. _____

P-411

SHEET NO. _____

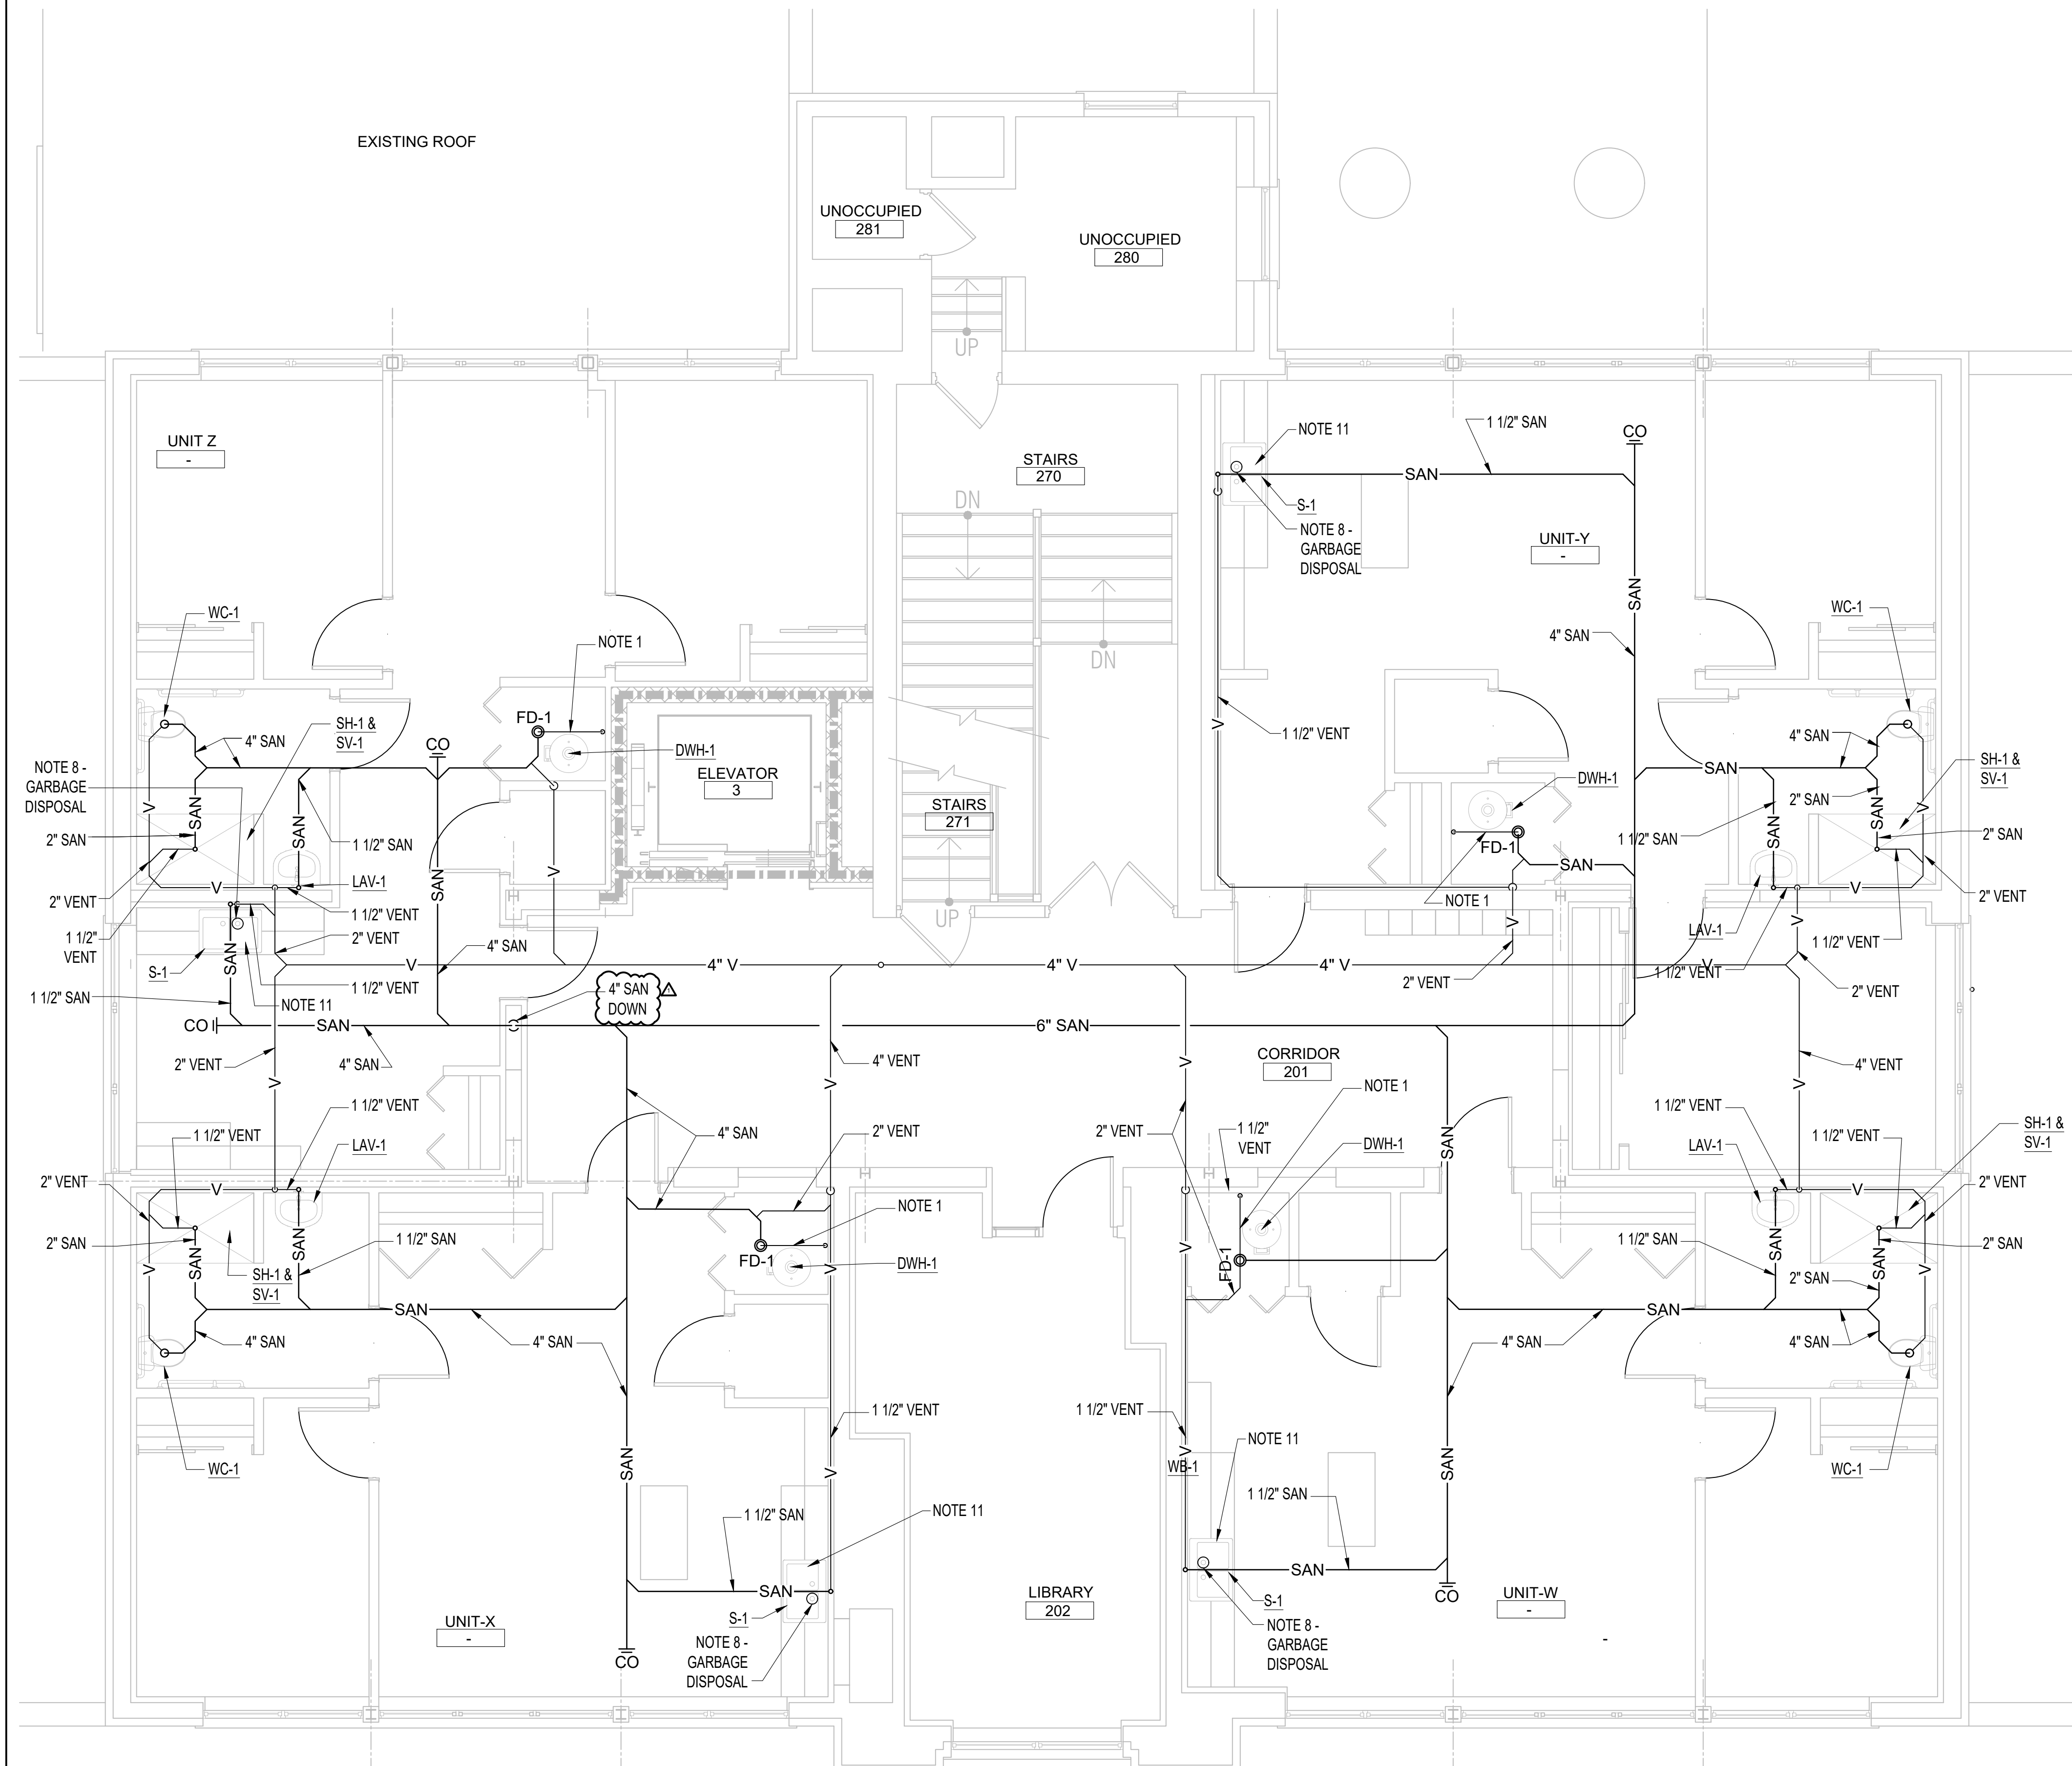


A5

SECOND FLOOR - SANITARY AND VENTING PLANS

P-411

$$1/4" = 1'-0"$$

1. EXTEND CONDENSATE DRAIN TO NEAREST FLOOR DRAIN IN WATER HEATER ROOM.
2. EXISTING NATURAL GAS METER AND REGULATOR BY UTILITY COMPANY. VENTILATOR REGULATOR PRESSURE AND COORDINATE TO ENSURE PROPER PRESSURE IS PROVIDE FOR SERVICE TO NATURAL GAS GENERATOR.
3. VENT UP AND DOWN
4. SANITARY UP AND DOWN AND PROVIDE VERTICAL CLEANOUT.
5. REFER TO TYPICAL APARTMENT WATER RISER DIAGRAM FOR PIPING ARRANGEMENT AND SIZES.
6. COORDINATOR TO CONTACT MISS DIG PRIOR TO START OF ANY UNDERGROUND WORK, COORDINATE WORK WITH CIVIL PLANS.
7. HEAT PUMP HOT WATER PIPING, REFER TO MANUFACTURER DRAWINGS FOR PROPER VENTILATION REQUIREMENTS FOR DOOR CLEARANCES AND SPACE REQUIREMENTS. REFER TO PLUMBING DETAILS FOR HEAT PUMP WATER HEATER PIPING AND EQUIPMENT REQUIRED.
8. GARBAGE DISPOSAL, SEE PLUMBING SCHEDULE FOR SPECIFICATIONS AND INSTALL FOR MANUFACTURER REQUIREMENTS. TO BE CONTROLLED BY SINK LOCATED ABOVE COUNTER SEE ELECTRICAL.
9. ALL SANITARY LINES ARE BELOW FLOOR ELEVATION TO ALLOW FOR PROPER PITCH AND NEEDED FLOW. EXACT LOCATION OF TUNNEL AND BASEMENT ARE UNKNOWN AND SANITARY COULD BE IN BASEMENT OR TUNNEL. ROUTE IN BASEMENT AND TUNNEL. COORDINATE ALL VENTING AND WATER DISTRIBUTION ABOVE FINISH CEILING AS HIGH AS POSSIBLE WITHOUT INTERFERING WITH OTHER TRADES.
10. IF UNIT IS CONSIDERED ADA SUBSTITUTE FIXTURES TO ADA TYPE. COORDINATE WITH ARCH DRAWINGS.
11. DISHWASHER - PROVIDE HOT WATER SHUT OFF AND SHUT OFF FROM SINK SUPPLY. PROVIDE SANITARY TO GARBAGE DISPOSAL. COORDINATE LOCATION WITH ARCHITECTURAL.

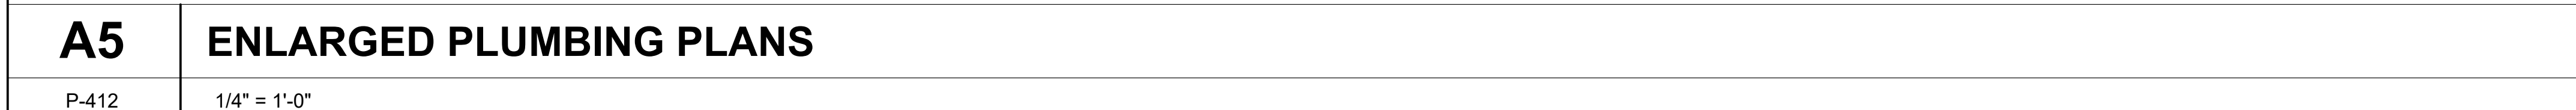

SHEET NO. _____

P-412	1/4" = 1'-0"
-------	--------------



SHEET TITLE

ROOF - PLUMBING
PLAN

SCALE: AS NOTED

ISSUED FOR	DATE
PERMIT	10.20.24
<u>△ BULLETIN 3</u>	<u>5.19.25</u>
<u>△ BULLETIN 5</u>	<u>10.13.25</u>

DRAWN BY

CHECKED

APPROVED

21026.00

FILE NO.

P-301


SHEET NO.

GENERAL







1. SEE SHEET P-001 FOR PLUMBING NOTES

PLUMBING SHEET KEYED NOTES:

3. EXTEND CONDENSATE DRAIN TO NEAREST FLOOR DRAIN IN WATER HEATER ROOM.
4. EXISTING NATURAL GAS METER AND REGULATOR BY UTILITY COMPANY. VERIFY EXISTING RATING OF PRESSURE AND COORDINATE TO ENSURE PROPER PRESSURE IS PROVIDE FOR SERVICE TO NATURAL GAS GENERATOR.
5. VENT UP AND DOWN
6. SANITARY UP AND DOWN AND PROVIDE PIPING CLEANOUT. IF RISER IS IN A FLOOR RATED WALL, CLEANOUT COVER MUST BE RATED FOR SAME RATED AS WALL ASSEMBLY
7. REFER TO TYPICAL APARTMENT WATER RISER DIAGRAM FOR PIPING ARRANGEMENT AND SIZES
8. CONTRACTOR TO CONTACT MISS DG PRIOR TO START OF ANY UP AND DOWN WORK. COORDINATE WORK WITH CIVIL PLANS.
9. HEAT PUMP HOT WATER, REFER TO MANUFACTURER DRAWINGS FOR PROPER VENTILATION REQUIREMENTS FOR DOOR CLEARANCES AND SPACE REQUIREMENTS. REFER TO PLUMBING SPECIFICATIONS FOR HEAT PUMP WATER HEATER PIPING AND EQUIPMENT REQUIRED.
10. GARBAGE DISPOSAL, SEE PLUMBING SCHEDULE FOR SPECIFICATIONS AND INSTALL FOR MANUFACTURER REQUIREMENTS. TO BE CONTROLLED BY STUD. LOCATED ABOVE COUNTER SEE ELECTRICAL
11. ALL SANITARY LINES ARE BELOW FLOOR ELEVATION TO ALLOW FOR PROPER PITCH AND NEEDED FLOW. EXACT LOCATION OF TUNNEL AND BASEMENT LOCATIONS OF AN SANITARY COULD BE IN BASEMENT OR TUNNEL. ROUTE IN A WAY TO MINIMIZE CORING. ALL VENTING AND WATER DISTRIBUTION ABOVE FINISH CEILING AS HIGH AS POSSIBLE WITHOUT INTERFERING WITH OTHERS.
12. IF UNIT IS CONSIDERED ADA SUBSTITUTE FIXTURES TO ADA TYPE. COORDINATE WITH ARCH DRAWINGS.
13. DISHWASHER - PROVIDE HOT WATER SUPPLY AND SHUT OFF FROM SINK SUPPLY. PROVIDE SANITARY TO GARBAGE DISPOSAL. COORDINATE WITH ARCH DRAWINGS.
14. ALL EXISTING ROOF CONDUCTORS ARE TO BE IDENTIFIED AND REPLACED. ROUTING OF THE ROOF CONDUCTORS IS INTENDED TO HAVE THE SAME PATHWAY AND SIZES AS EXISTING. COORDINATE WITH ARCH AND NATURAL FOR ROUTING OF ANY POTENTIAL INTERFERENCES OR ADDITIONAL DOME NEEDED TO COMPLETE REPLACEMENT. COORDINATE WITH CIVIL FOR LOCATIONS OF COMBINED ROOF DRAIN AND PIPING LEAVING THE BUILDING. EXISTING ROUTING OF ROOF CONDUCTORS WERE UNABLE TO BE IDENTIFIED DURING THE TIME OF DESIGN. RESPONSIBILITY OF THE GENERAL CONTRACTOR TO IDENTIFY LOCATIONS OF PIPING LEAVING THE BUILDING TO AVOID ANY OPEN ROOF CONDUCTORS THAT WOULD ALLOW WATER INTO THE BUILDING.

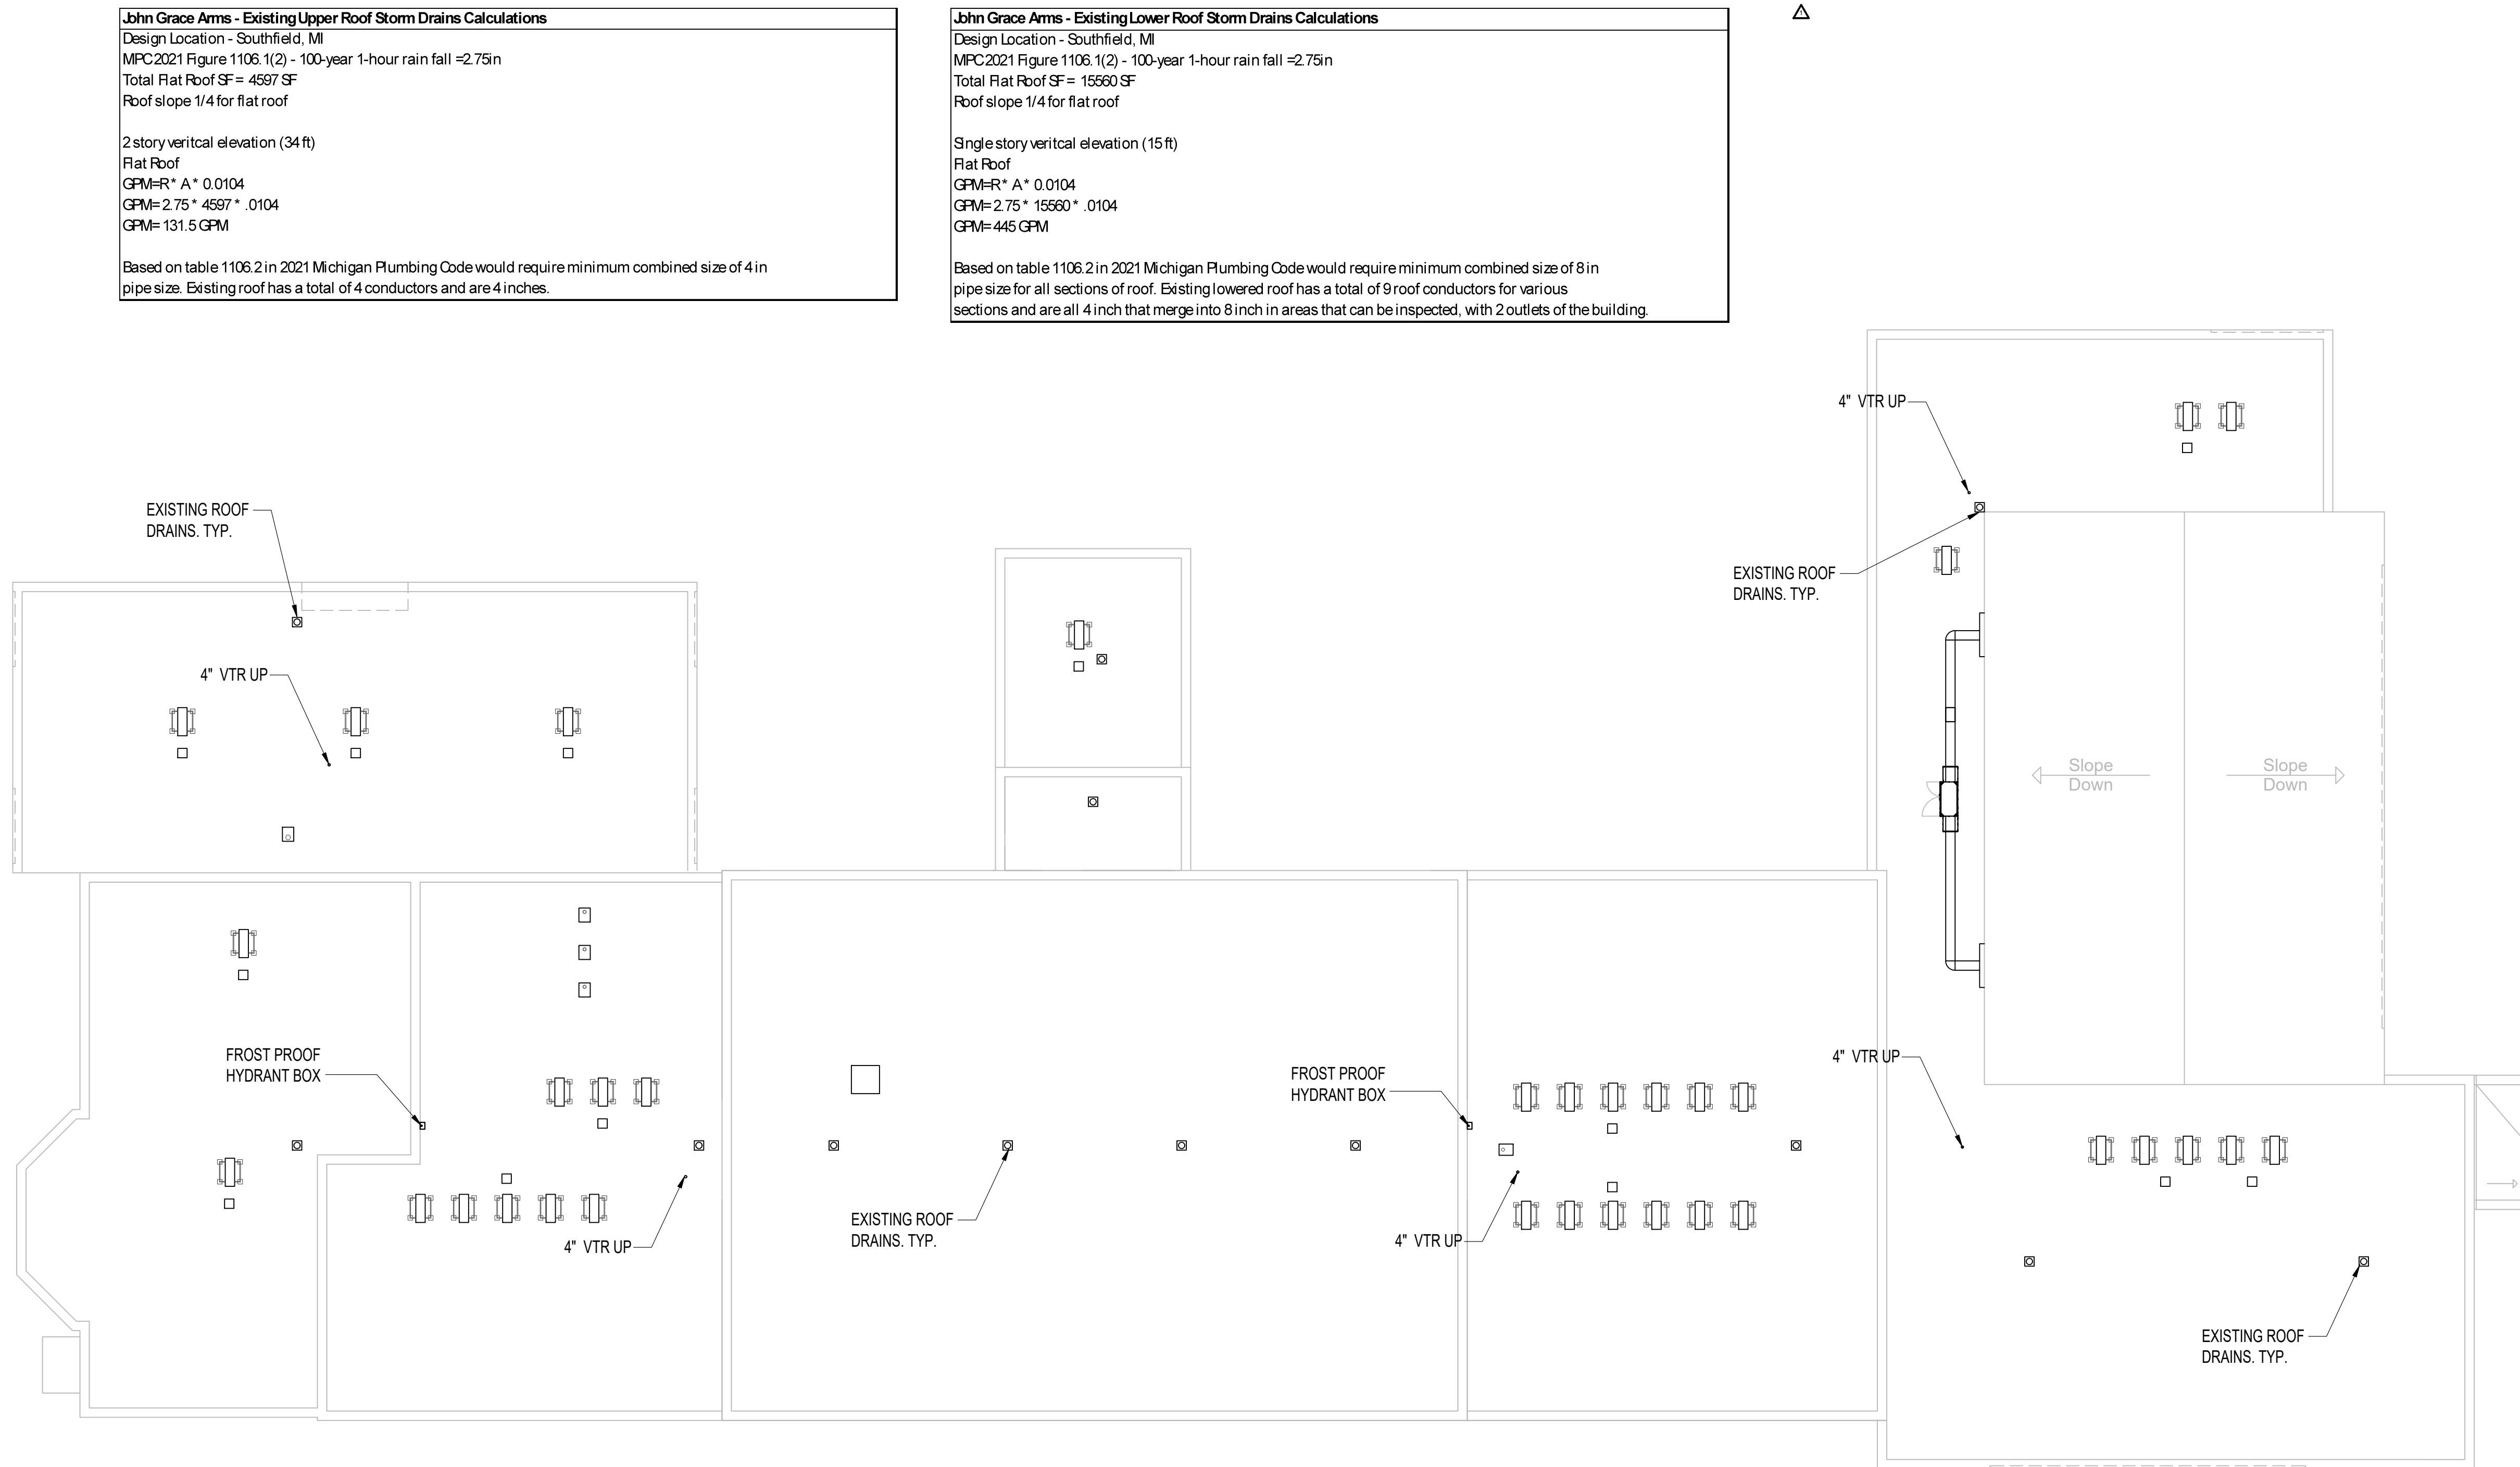

5/19/2025 6:04:00 PM

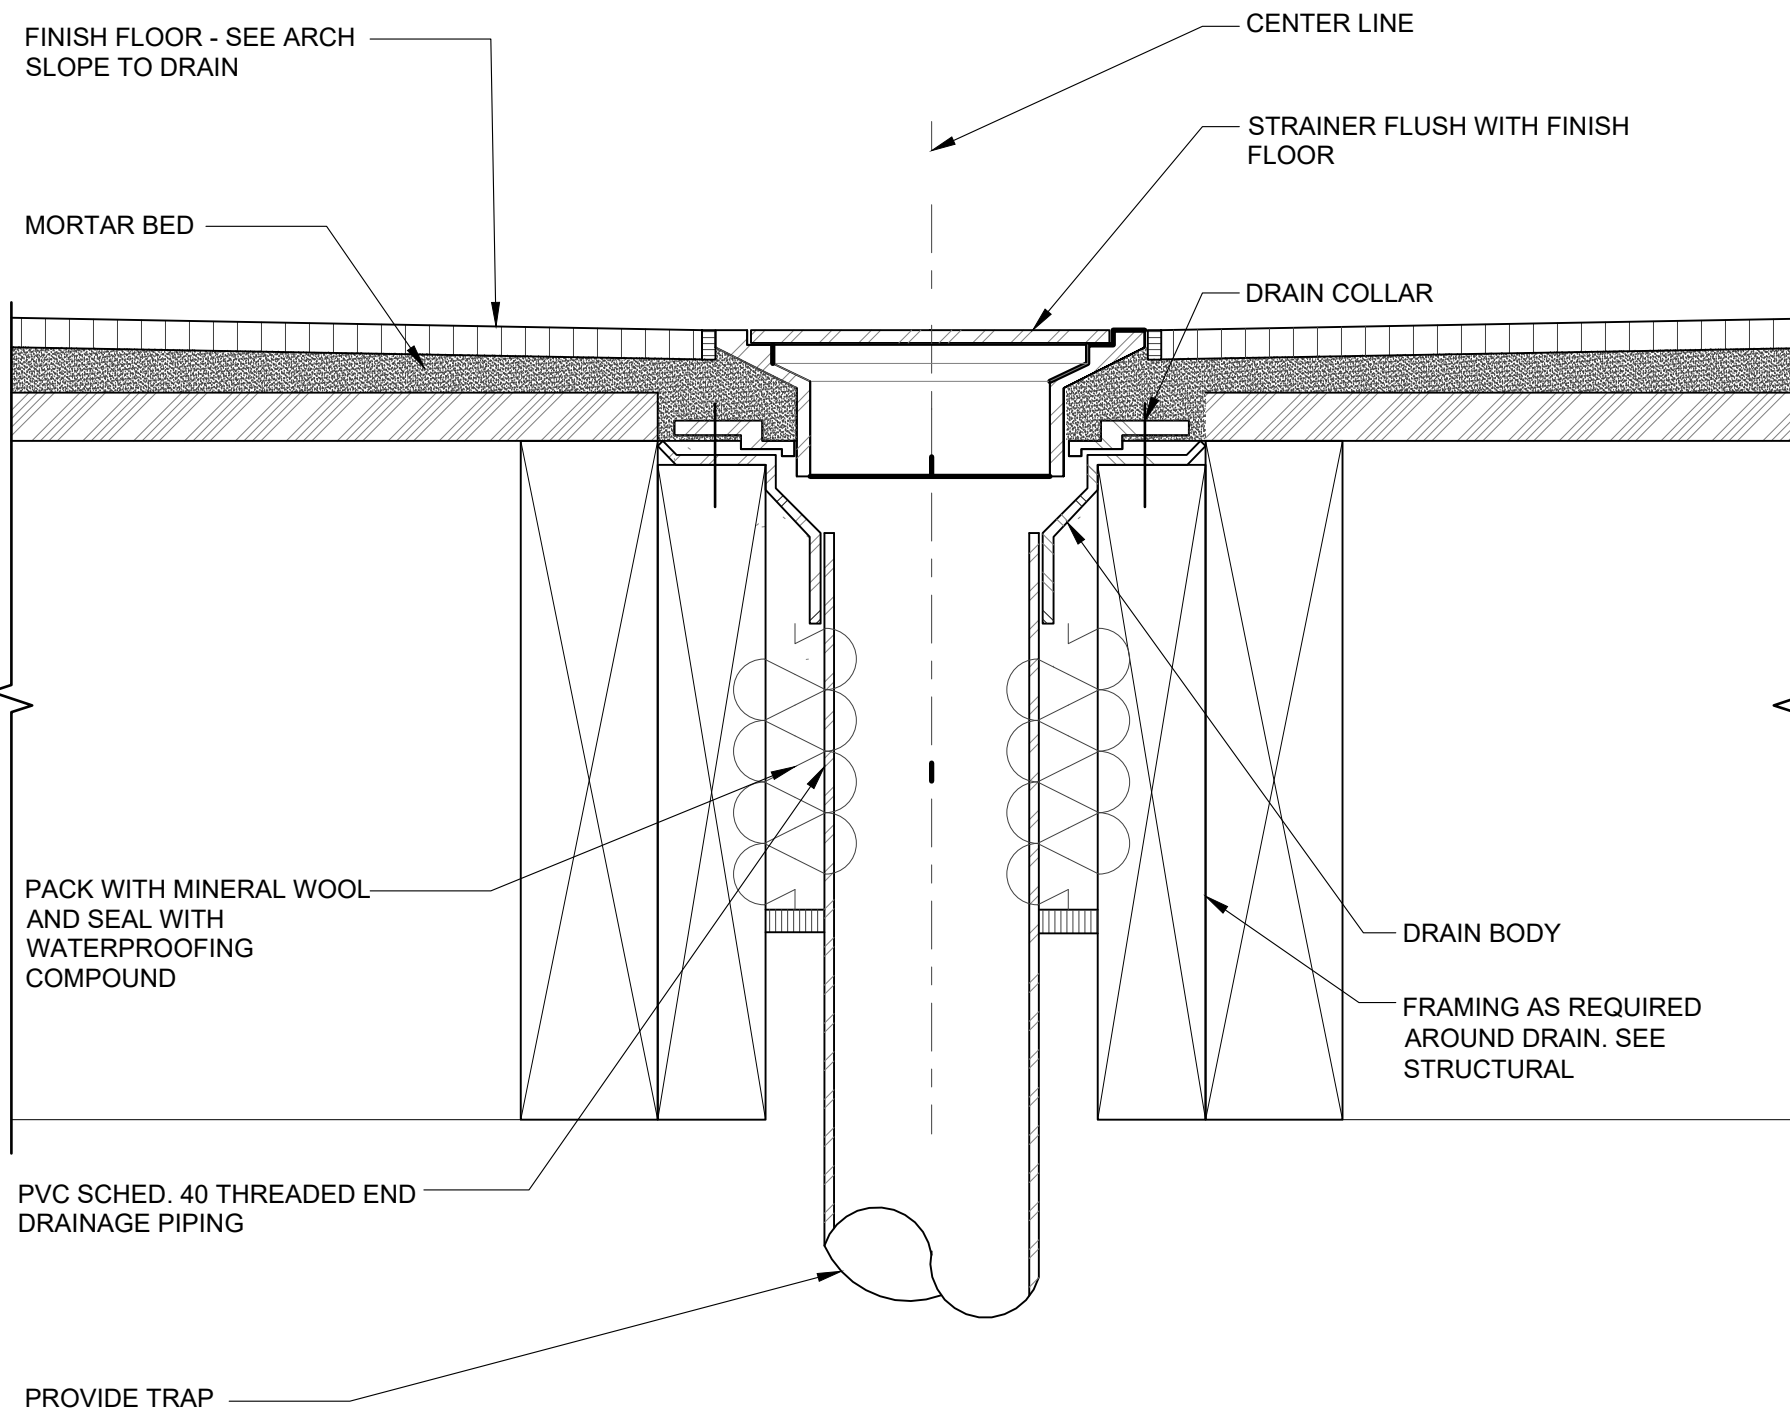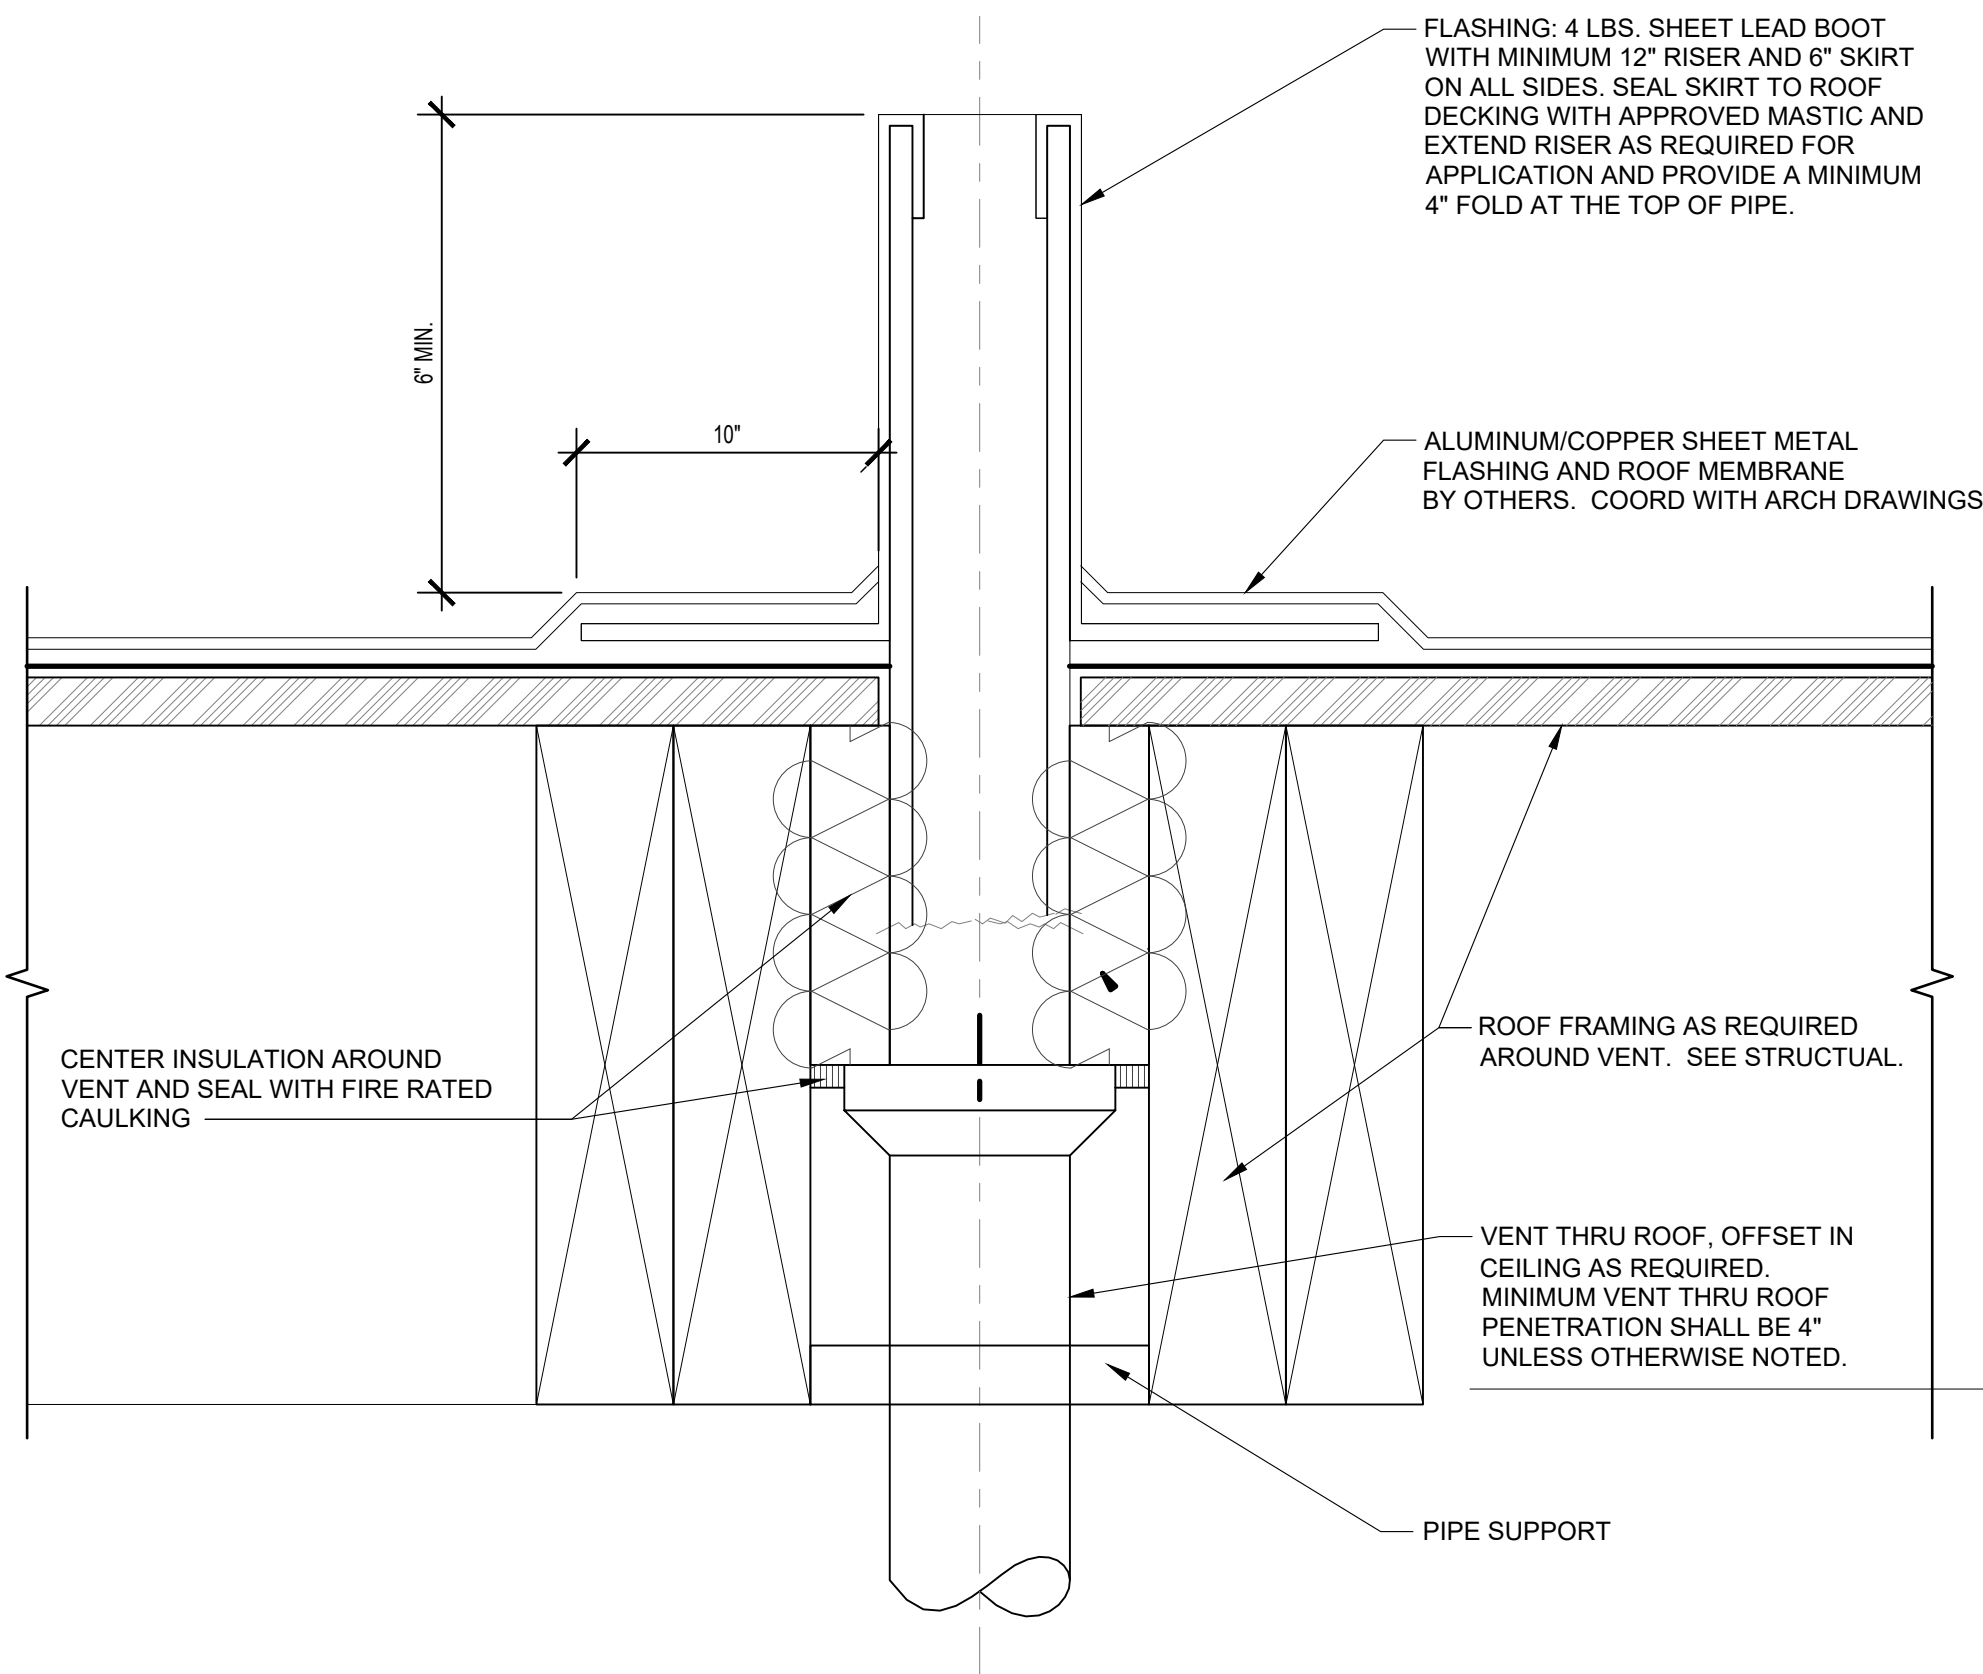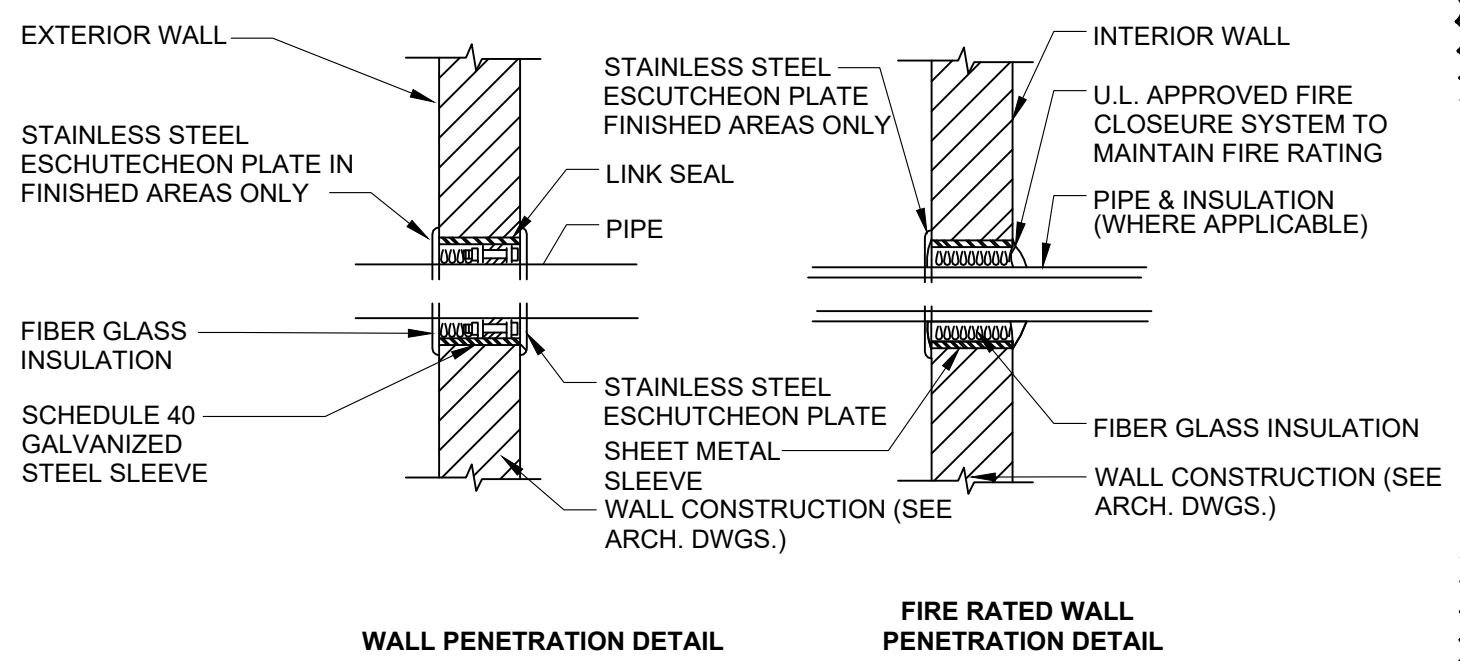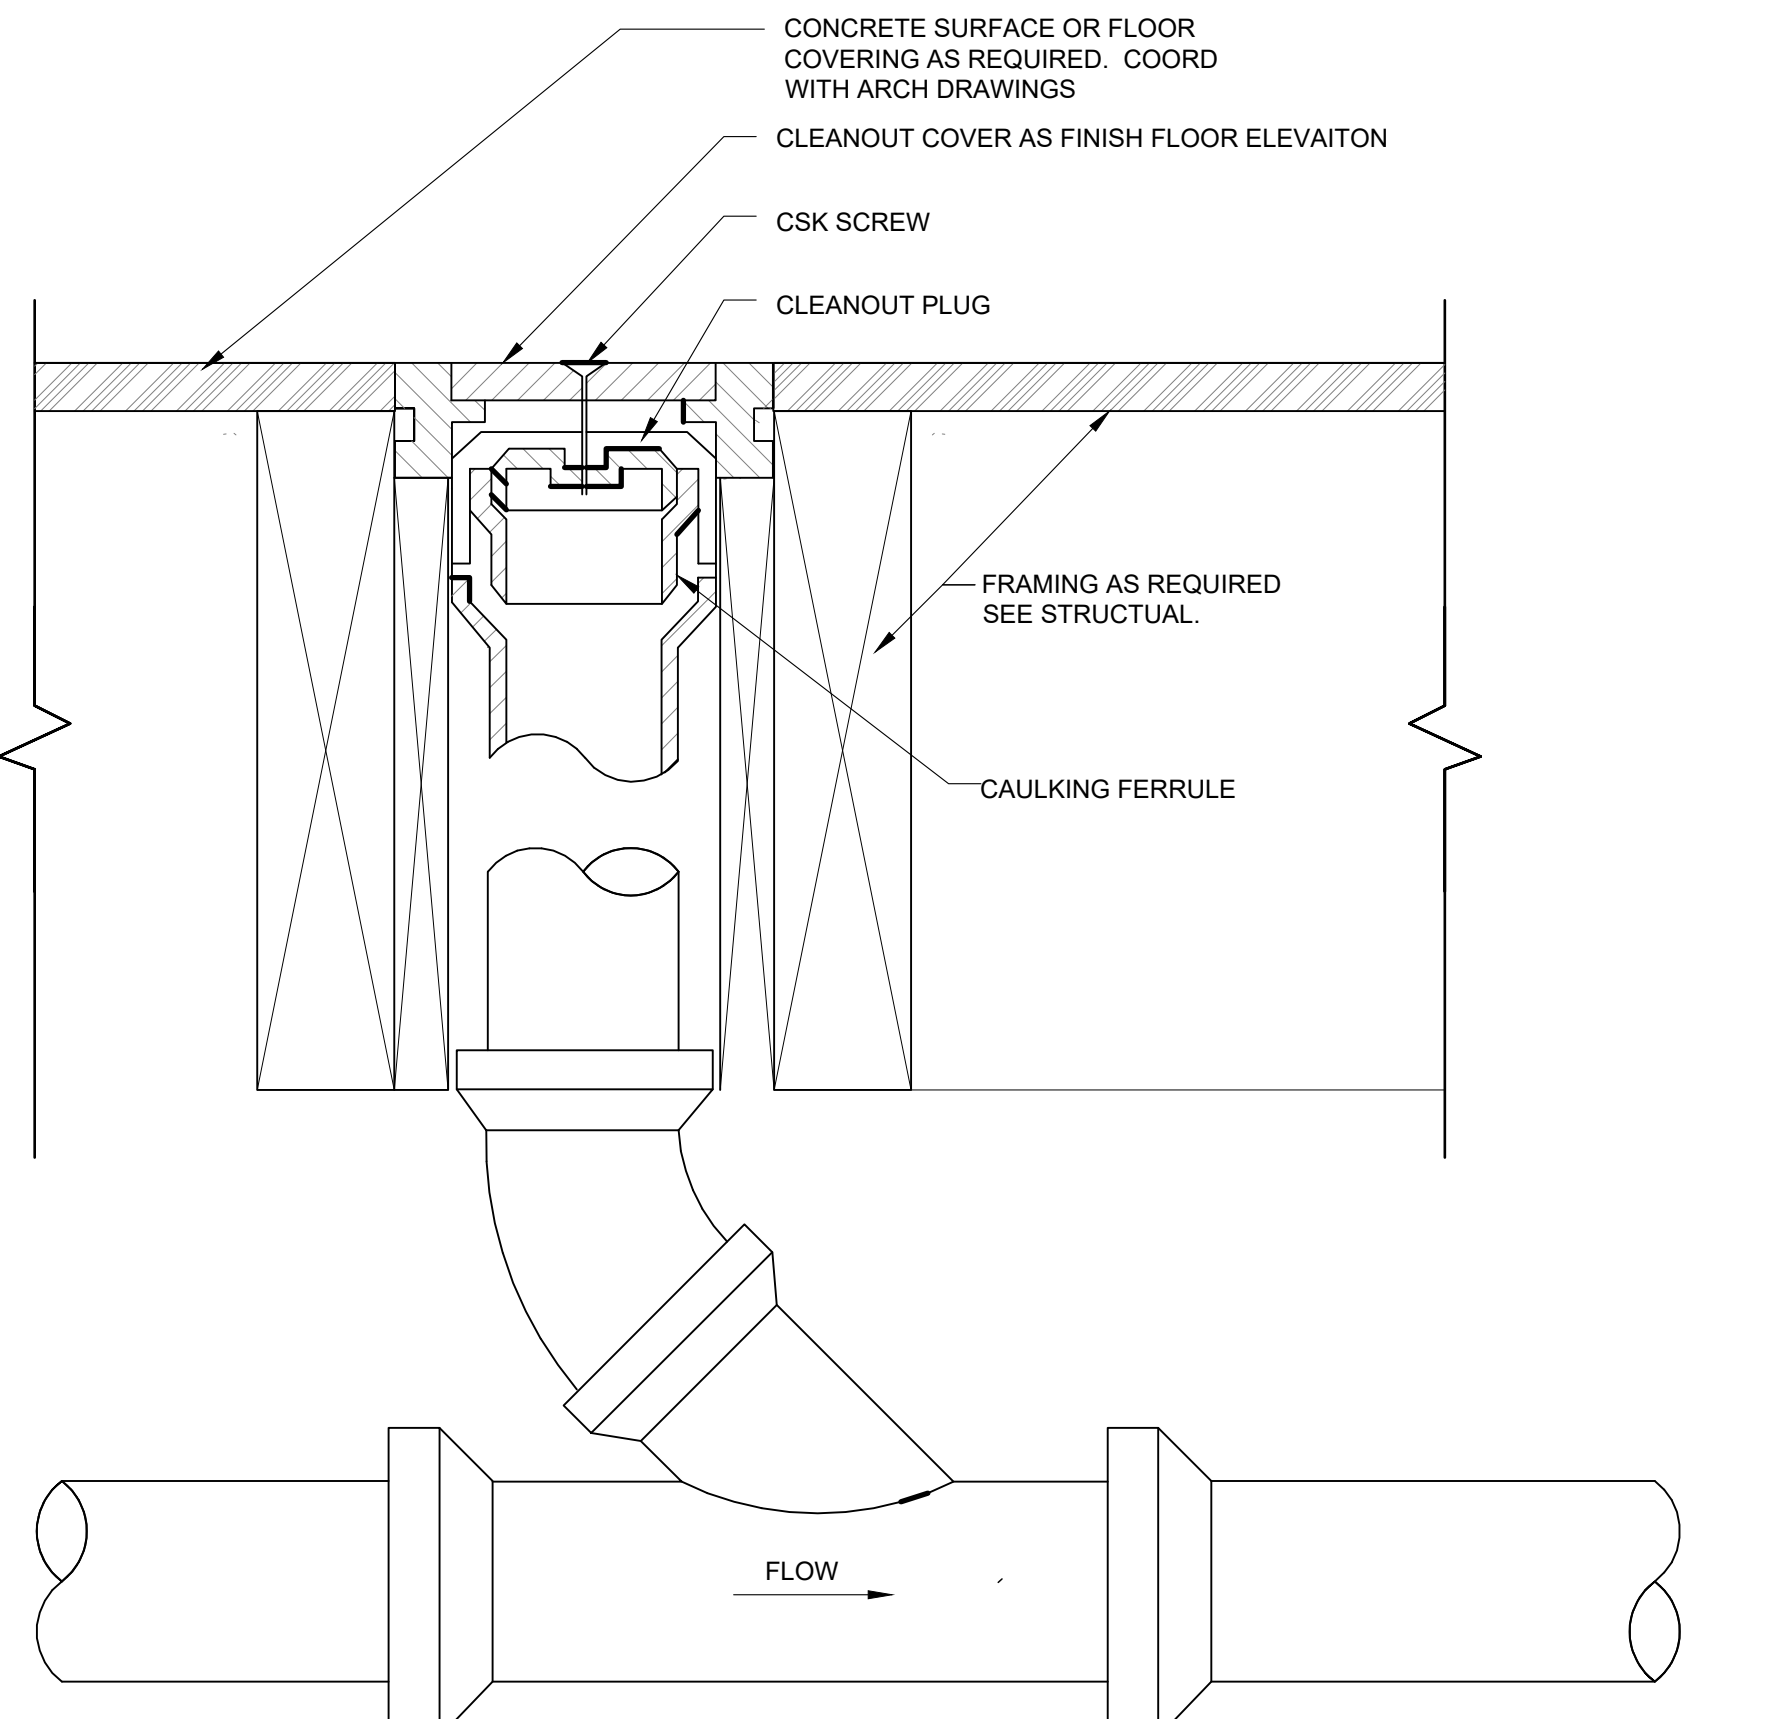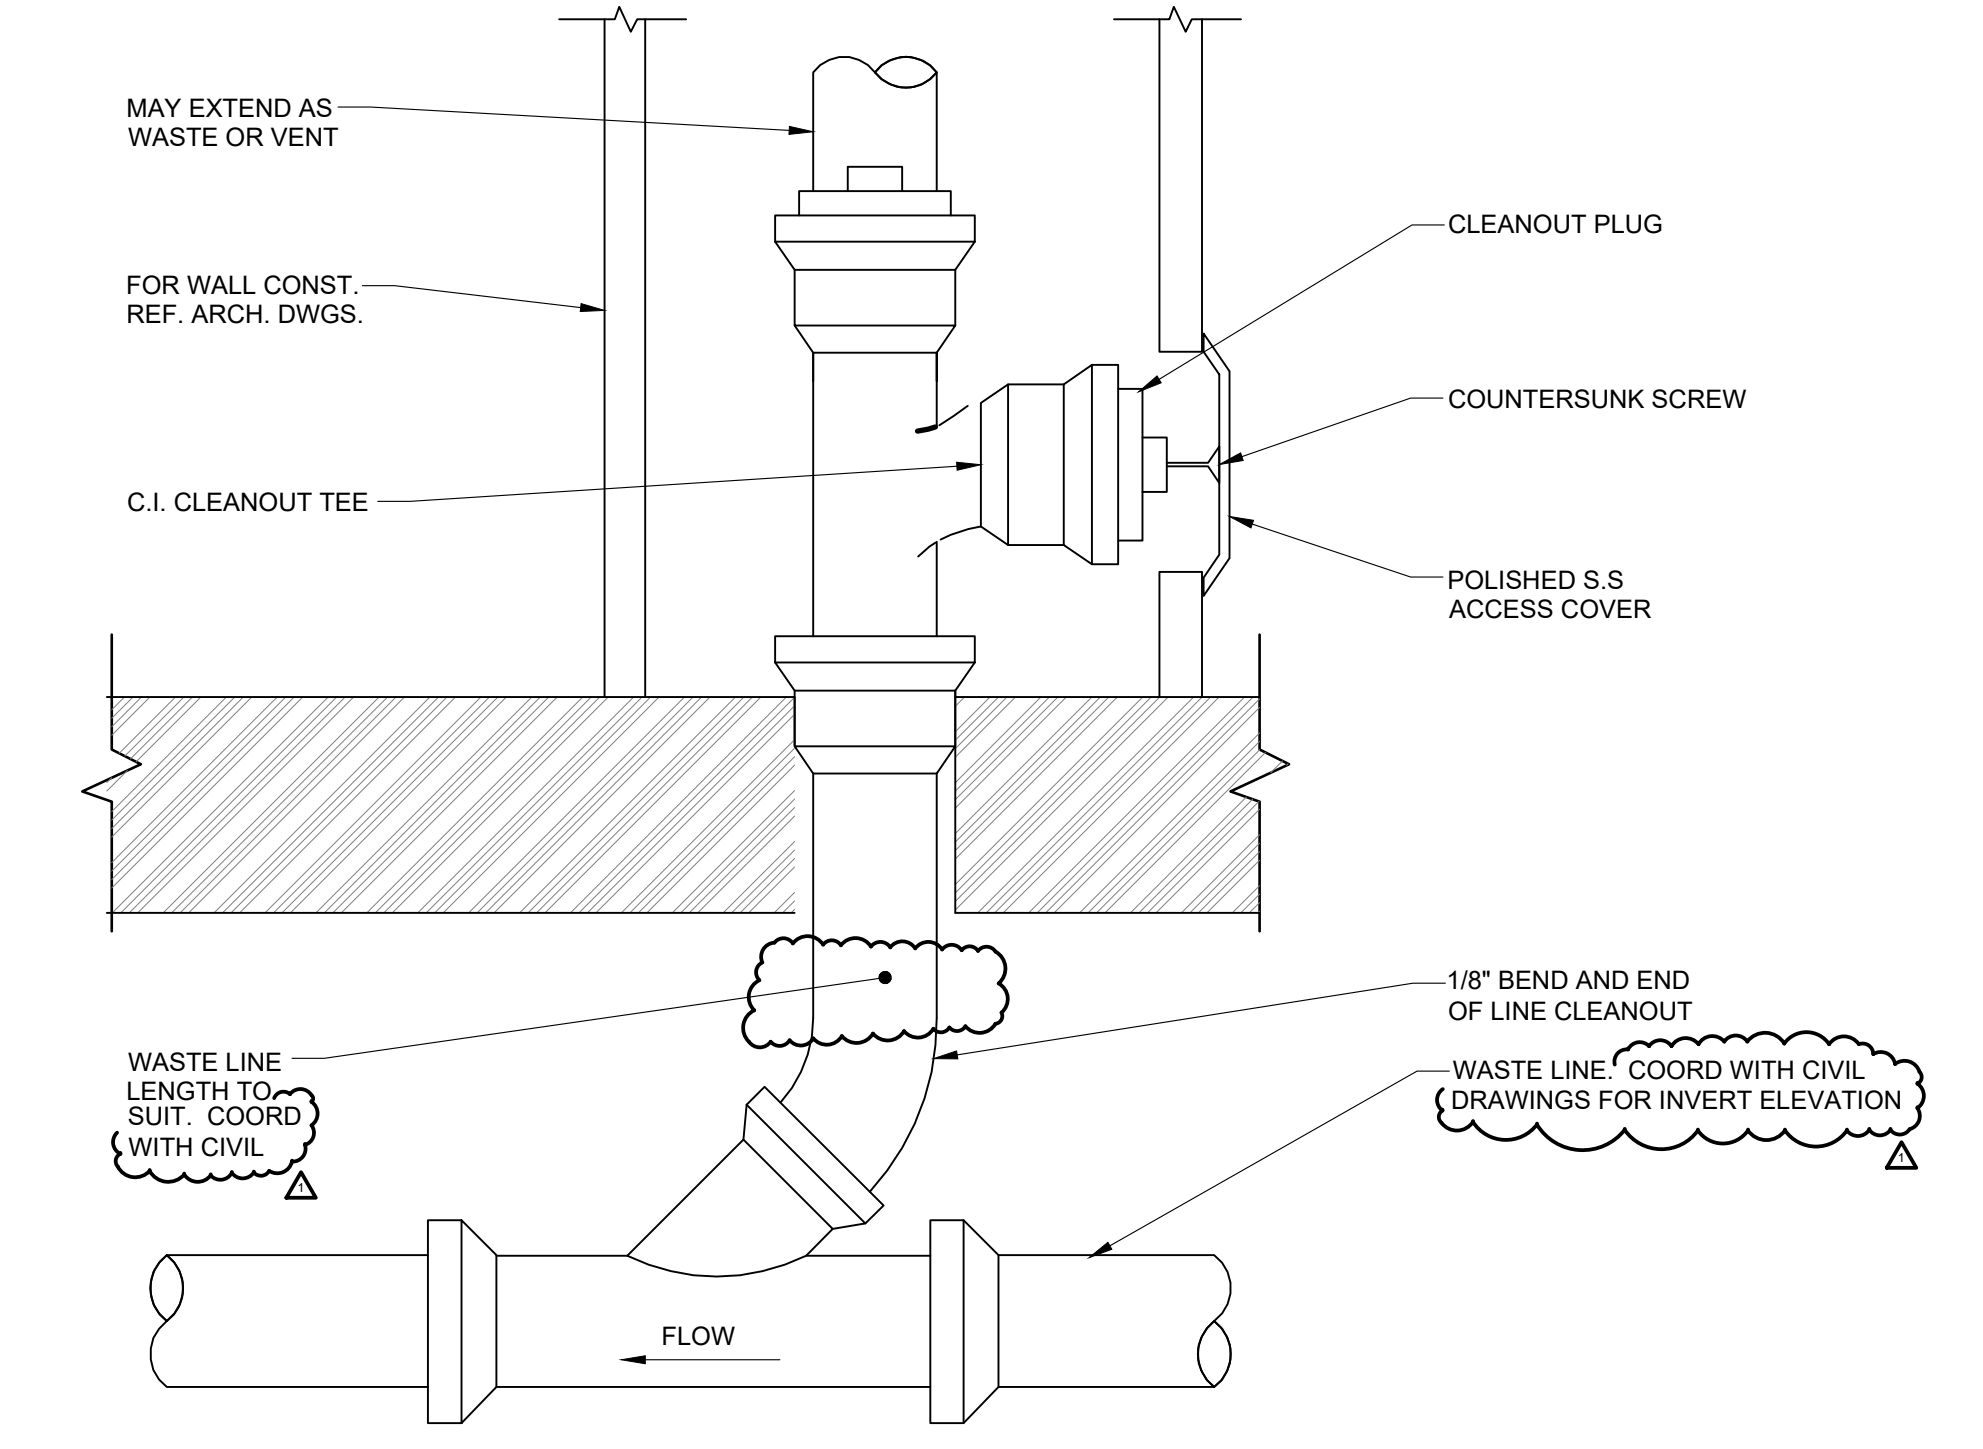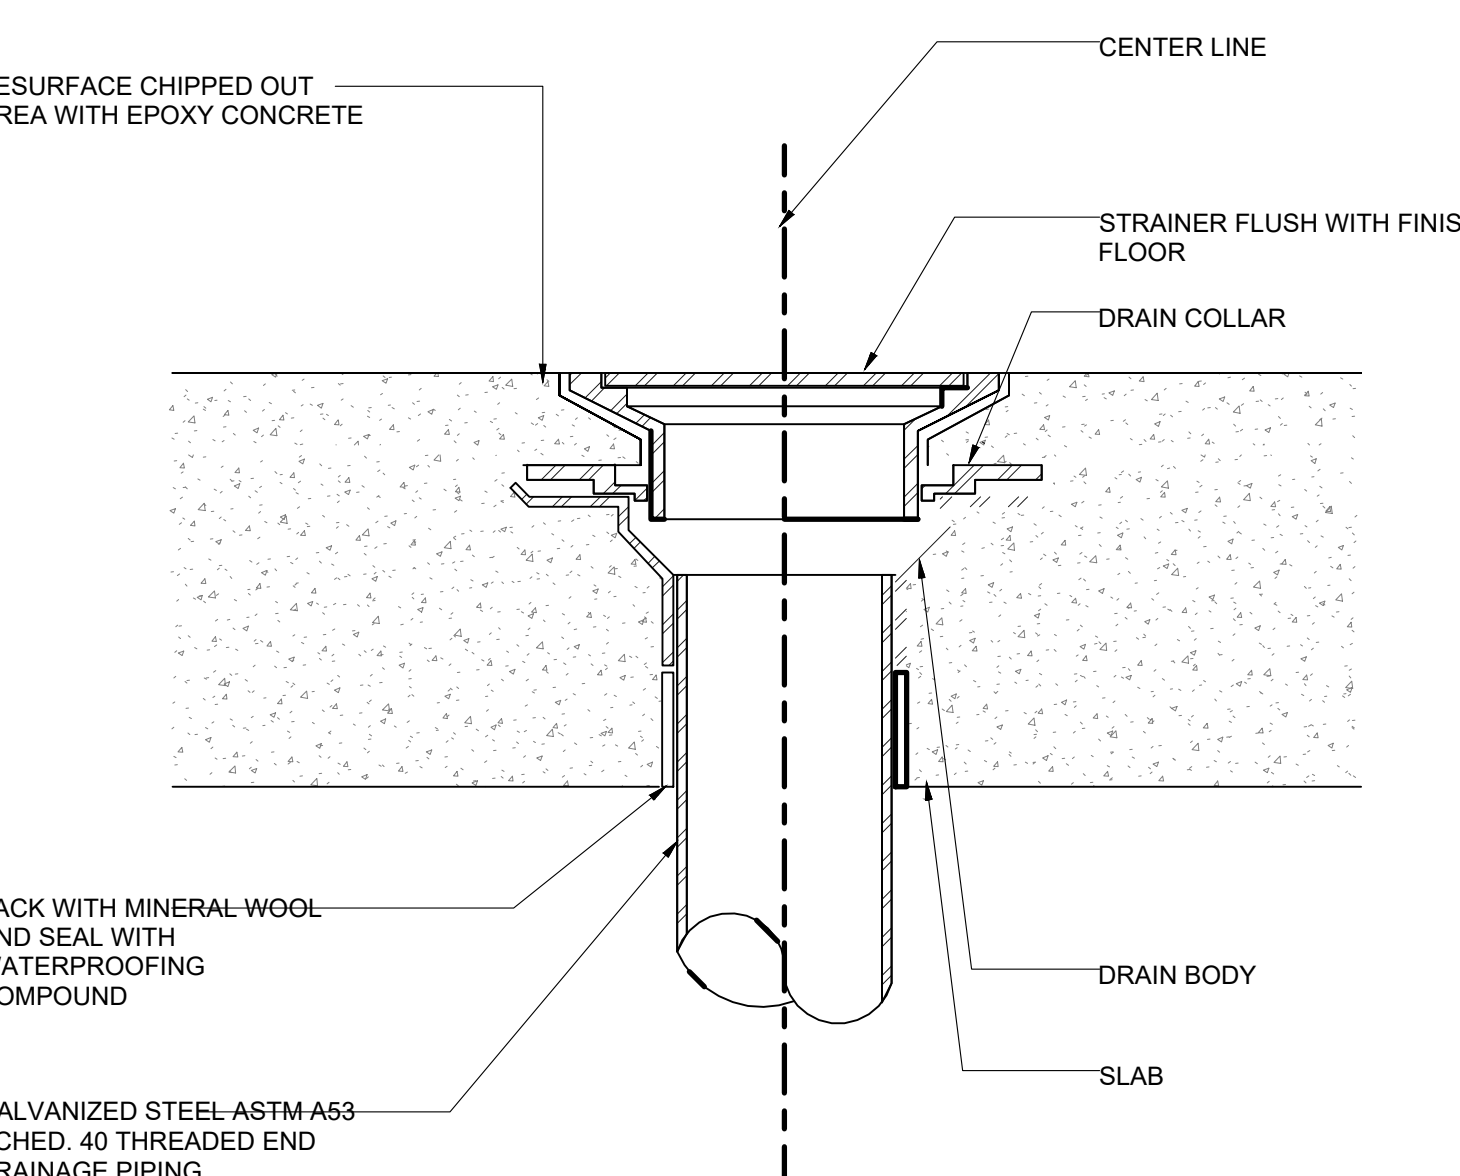 FINISH FLOOR - SEE ARCH SLOPE TO DRAIN CENTER LINE MORTAR BED STRAINER FLUSH WITH FINISH FLOOR DRAIN COLLAR PACK WITH MINERAL WOOL AND SEAL WITH WATERPROOFING COMPOUND DRAIN BODY FRAMING AS REQUIRED AROUND DRAIN. SEE STRUCTURAL PVC SCHED. 40 THREADED END DRAINAGE PIPING PROVIDE TRAP NOTES: 1. WATERPROOF EXISTING FLOOR OF ROOM WHERE FLOOR DRAIN IS TO BE LOCATED USING THOROSEAL SEALANT OR APPROVED EQUAL.		 FLASHING: 4 LBS. SHEET LEAD BOOT WITH MINIMUM 12" RISER AND 6" SKIRT ON ALL SIDES. SEAL SKIRT TO ROOF DECKING WITH APPROVED MASTIC AND EXTEND RISER AS REQUIRED FOR APPLICATION AND PROVIDE A MINIMUM 4" FOLD AT THE TOP OF PIPE. ALUMINUM/COPPER SHEET METAL FLASHING AND ROOF MEMBRANE BY OTHERS. COORD WITH ARCH DRAWINGS ROOF FRAMING AS REQUIRED AROUND VENT. SEE STRUCTUAL. VENT THRU ROOF. OFFSET IN CEILING AS REQUIRED. MINIMUM VENT THRU ROOF PENETRATION SHALL BE 4" UNLESS OTHERWISE NOTED. PIPE SUPPORT CENTER INSULATION AROUND VENT AND SEAL WITH FIRE RATED CAULKING NOTE: ALL VENT THRU ROOF PENETRATIONS SHALL BE LOCATED A MINIMUM OF 10'-0" IN ALL DIRECTIONS FROM ALL FRESH AIR INTAKES AND/OR OPERABLE DOORS AND WINDOWS.		 WALL PENETRATION DETAIL FIRE RATED WALL PENETRATION DETAIL EXTERIOR WALL STAINLESS STEEL ESCHUTECHON PLATE IN FINISHED AREAS ONLY LINK SEAL PIPE FIBER GLASS INSULATION SCHEDULE 40 GALVANIZED STEEL SLEEVE INTERIOR WALL U.L. APPROVED FIRE CLOSEURE SYSTEM TO MAINTAIN FIRE RATING PIPE & INSULATION (WHERE APPLICABLE) STAINLESS STEEL ESCHUTECHON PLATE SHEET METAL SLEEVE WALL CONSTRUCTION (SEE ARCH. DWGS.) FIBER GLASS INSULATION WALL CONSTRUCTION (SEE ARCH. DWGS.)		F1	TYPICAL FLOOR DRAIN INSTALLATION		F8	VENT THRU ROOF DETAIL		A8	WALL PENETRATIONS	
P-501	NTS		P-501	NTS		P-501	NTS		P-501	NTS				
 CONCRETE SURFACE OR FLOOR COVERING AS REQUIRED. COORD WITH ARCH DRAWINGS CLEANOUT COVER AS FINISH FLOOR ELEVATION CSK SCREW CLEANOUT PLUG FRAMING AS REQUIRED SEE STRUCTUAL. CAULKING FERRULE FLOW		 MAY EXTEND AS WASTE OR VENT FOR WALL CONST. REF. ARCH. DWGS. C.I. CLEANOUT TEE CLEANOUT PLUG COUNTERSUNK SCREW POLISHED S.S. ACCESS COVER 1/8" BEND AND END OF LINE CLEANOUT WASTE LINE LENGTH TO SUIT. COORD WITH CIVIL WASTE LINE COORD WITH CIVIL DRAWINGS FOR INVERT ELEVATION FLOW		 RESURFACE CHIPPED OUT AREA WITH EPOXY CONCRETE CENTER LINE STRAINER FLUSH WITH FINISH FLOOR DRAIN COLLAR PACK WITH MINERAL-WOOL AND SEAL WITH WATERPROOFING COMPOUND DRAIN BODY SLAB GALVANIZED STEEL-ASTM A53 SCHED. 40 THREADED END DRAINAGE PIPING NOTES: 1. WATERPROOF EXISTING FLOOR OF ROOM WHERE FLOOR DRAIN IS TO BE LOCATED USING THOROSEAL SEALANT OR APPROVED EQUAL. 2. FOR EXISTING FLOOR DRAINS INSTALL CORRECT SIZE WATER LESS SEAL PROTECTION SYSTEM. BASIS OF DESIGN: GREEN DRAIN MODEL GD125		A1	FLOOR CLEANOUT - FINISHED ROOMS		A8	WALL CLEANOUT - FINISHED ROOMS		A13	FLOOR DRAIN IN CONCRETE	
P-501	NTS		P-501	NTS		P-501	NTS		P-501	NTS				

John Grace Arms
21030 Indian St, Southfield MI 48033
Developed by
John Grace Arms LDHA LLC

SDG

Architects + Planners

607 Shelby Street
Suite 704
Detroit, MI 48226

Tel: 313-961-9000
Fax: 313-964-3233

A & A Engineering & Consulting

28863 Vista Way, South Lyon, MI 48178

REGISTRATION SEAL

STATE OF MICHIGAN

STEPHEN M. HENNARD

ENGINEER

NO. 6201059975

LICENSED PROFESSIONAL ENGINEER

KEY PLANS

SHEET TITLE

PLUMBING
TYPICAL DETAILS

SCALE: AS NOTED

ISSUED FOR

PERMIT

BULLETIN 3

DATE

10.20.24

5.19.25

DRAWN BY

CHECKED

APPROVED

21026.00

FILE NO.

P-501

SHEET NO.

John Grace Arms
21030 Indian St, Southfield MI 48033
Developed by
John Grace Arms LDHA LLC

SDG
Architects + Planners
607 Shelby Street
Suite 704
Detroit, MI 48226
Tel: 313-961-4000
Fax: 313-964-3233


A & A Engineering & Consulting
28862 Vista Way, South Lyon, MI 48178

REGISTRATION SEAL



KEY PLANS

SHEET TITLE

**PLUBMING
TYPICAL DETAILS**

SCALE: AS NOTED

ISSUED FOR	DATE
PERMIT	10.20.24
△ BULLETIN 3	5.19.25

DRAWN BY

CHECKED

APPROVED

21026.00

FILE NO.

P-501

SHEET NO.

5/19/2025 5:34:05 AM

DOMESTIC WATER HEATER SCHEDULE

Pipe Sizing							
Tag	Item	Make	Model Number	Description	Cold Water	Hot Water	Notes
DWH-1	Heat Pump Water Heater	Rheem	PROPH40 T2 RH375-30	40 gallon heat pump w ater heater. 3.83 UEF rating. 10 year limited parts and tank w arranty	3/4 "	3/4 "	1, 2, 3, 8, REFER TO DETAILS
DWH-2	Heat Pump Water Heater	Rheem	PROPH40 T2 RH375-15	40 gallon heat pump w ater heater. 3.88 UEF rating. 10 year limited parts and tank w arranty	3/4 "	3/4 "	1, 2, 3, 8, REFER TO DETAILS
DWH-3	Electric Water Heater	Eemax	SPEX4208T ML	Electric tankless w ater heater	3/8"	3/8"	1, 5, 8, 9, 10
DWH-4	Heat Pump Water Heater	Rheem	PROPH50 T2 RH375-30	50 gallon heat pump w ater heater. 3.88 UEF rating. 10 year limited parts and tank w arranty	1"	1"	1, 2, 3, 8, REFER TO DETAILS
CV-1	Check Valve	Zurn Wilkins	40XL2	Lead-free brass soft seated check valve with stainless steel spring. Rated for 210 degrees and 400 psi			Size and locate for incoming cold w ater line.
ET-1	Potable Expansion Tank	Calefactio	HGTE-1	Bladded type lead free thermal expansion tank w ith 100% exceptance factor. 1/2 FNPT stainless steel connection	1/2"		Total volume and acceptance .4 gallons. Precharged to 50 psi. 200 Degrees max temperature. 150 Maximum operating pressure.

- Notes
- 1

INTERNAL PRESSURE SENSOR, RELIEF PIPED TO NEAREST FLOOR DRAIN
- 2

SEE MANUFACTURER GUIDELINES FOR ROOM VENTILATION, COORDINATE WITH ARCHITECT AND GENERAL CONTRACTOR PROPER DOOR CLEARANCE OR DUCTED SYSTEM.
- 3

RECIRCULATION PUMP TO HAVE SMART CONTROL FEATURE THAT DOES NOT REQUIRE EXTERNAL AQUASTAT.
- 4

TOTAL VOLUME 21 GALLONS, PRE-CHARGED TO 12 PSI AND MAX TEMP OF 240 F.
- 5

WALL MOUNTED WITH BACKING BOARD.
- 6

INSTALL EXPANSION TANK BRACKET AND SUPPORT TO SOLID WALL- BRACKET200MM
- 7

TOTAL VOLUME 2.1 GALLONS, PRE-CHARGED TO 50 PSI AND MAX TEMP OF 200 F.
- 8

COORDINATE FINAL LOCATION WITH ELECTRICAL CONTRACTOR AND PROVIDE LOCAL DISCONNECT.
- 9

PROVIDE AND INSTALL SERVICE/ISOLATION VALVES AND PRESSURE RELIEF PART NUMBER RTG20326
- 10

LOW FLOW ACTIVATION, ADJUSTABLE THERMOSTAT, VOLTAGE 208V AND 4.1 KW

RECIRCULATION PUMP SCHEDULE

Motor										
Tag	Item	Make	Model Number	Number of Pumps	Capacity - GPM	H.P.	Amps	Voltage/Phase	Width	Notes
RC -1	Hot water return recirculation pump	Taco	006-IQBC4	1	11.5	1/40	0.52	115/1	3 3/4	1/2 Sweat connection, self learning function

- Notes
- 1

FLANGED CONNECTION, SMART MODEL WITH PROVIDED THERMOSTAT.
- 2

COORDINATE FINAL LOCATION WITH ELECTRICAL CONTRACTOR FOR ELECTRICAL OUTLET- 115V.

SUMP PUMP SCHEDULE

Tag	Item	Motor						Sump Basin			
		Make	Model Number	Number of Pumps	Capacity - GPM	H.P.	Amps	Voltage/Phase	Width	Depth	Notes
SP-1	Elevator Pit Drainage	Bell & Gossett	2WF0511	1	50	0.5	14.5	115 / 1	18 in	30 in	1,2,3
SP-2	Basement sump pump	Bell & Gossett	ST51AV	1	61	0.5	7.5	115 / 1			1,2,3

- Notes
- 1

Provide SJE pumpmaster plus pump switch. Plug and power cord connection to 120V receptacle. Provide severe durt oil & water resistant power and control cords
- 2

Provide a full flow check valve and gate valve on the discharge pipe from sump pump.
- 3

Sump cover to be open grate type.

PLUMBING FIXTURE SCHEDULE

TAG	FIXTURE	ROUGH-IN SERVICES				MANUFACTURER	MODEL	FAUCET MANUF	FAUCET MODEL	FLOW RATE	ACCESSORIES	REMARKS
		COLD WATER	HOT WATER	WASTE	VENT							
LAV -1	LAVATORY COUNTERTOP SINK	½	½	1 ½	1 ½	SLOAN	SS-3002 – DROP IN OVAL	-	-	-	1,2,4,5,7,8, 9, 10, 11	-
LAV -2	LAVATORY SINK -ADA WALL MOUNT	½	½	1 ½	1 ½	SLOAN	SS-3003	-	-	-	1, 2, 4, 5, 7, 8, 9, 10, 11	-
S-1	SINK – 2 COMP	½	½	1 ½	1 ½	ELKAY	LR-3322 – LUSTERTONE	-	-	-	1, 2, 4, 6, 10, 12, 13, 14	-
S-2	SINK – 2 COMP ADA	½	½	1 ½	1 ½	ELKAY	LRAD-332265 - LUSTERTONE	-	-	-	1, 2, 4, 6, 10, 12, 13, 14	-
SH-1	SHOWER INSERT – ONE PIECE			2	1 ½	CLARION	REB036NS-VH				1, 2, 15, 16	
SV -1	SHOWER MIXING VALVE	½	½			DELTA	T13290			2.0 GPM	1, 2,	LEVER HANDLE ONLY
SV –2	SHOWER MIXING VALVE ADA	½	½			DELTA	T13H152			2.0 GPM	1, 2,	HANDHELD ADA W/ 60" HOSE SLIDE BAR, LEVER HANDLE ONLY
WC -1	WATER CLOSET	½		4	2	PROFLO	PF1400T			1.28		1, 2, 3, 4
FD-1	FLOOR DRAIN			SEE PLANS		PROFLO	PF42873					1, 2, 18, 19
MS – 1	MOP SINK	½	½	3	1 ½	PROFLO	PFMB2424				1, 2, 20	
WB -1	WASHING MACHINE WALL BOX	½	½	2		GUY GRAY	B200				1, 2	
WH -1	WALL HYDRANT NON FREEZE	¾				WOODFORD	B67					WALL BOX, DOUBLE CHECK BACKFLOW
DN-1	DOWNSPOUT NOZZLE			SEE PLANS		MFAB	R1940				1, 2	STAINLESS STEEL SCREEN
LS-1	LAUNDRY ROOM SINK FAUCET	½	½	2	1 ½	TEHLA	LUXE 040US9000DRSS				1, 2, 4,5 6, 17	
KS-1	PREP SINK & TABLE COMBO	½	½	SEE PLANS		ULINE	H-9652L				1, 2	PROVIDE ALL NECESSARY TRAP & CONNECTIONS

1.

Verify color/finish with Architect.
2.

Provide all sleeve, templates as required for rough-in of fixtures. Coordinate with Architect and trades.
3.

Provide compatible seat, preferred PROFLO PFTSCOF2000WH with sta-tite fasteners.
4.

Provide Brasscraft commercial angle supply with riser.
5.

Provide wrap on supply and waste piping equal to Keeney trap wrap.
6.

Provide Brasscraft 1 -1/2" brass cast P trap
7.

Provide Brasscraft 1 -1/4" brass cast P trap
8.

Provide 1 – 1/4" offset drain with tailpiece
9.

Provide chair carrier with foot supports, mount per ADA requirements.
10.

Tempering valve: Powers LF6480, ASSE 1070
11.

Lavatory faucet: ProFlo PFVWSC4744CP
12.

Drain outlet with tailpiece: Jones Stephens Corp S14-014T
13.

Sink faucet: Kohler K-30615 single lever
14.

Garbage Disposer: In-sink erator Badger 5, with cord and plug, ½ hp, 120V, 1 phase, 6.9amps
15.


Show er drain: ProFlo PF42940 w/ deep seal trap fit to size.
16.

Install Clarion E-Z w all trim on perimeter, use mildew resistant silicone caulk to seal shower insert.

BACKFLOW SCHEDULE

TAG	SERVICE	TYPE	SIZE	LOCATION	MANUF	MODEL #	REMARKS
BF -1	DOMESTIC WATER	PRESSURE REGULATING	4 IN	MECHANICAL ROOM	ZURN	375AST	EXTEND DRAIN TO NEAREST FLOOR DRAIN
BF -2	FIRE PROTECTION	-	-	-	-	-	TO BE INCLUDED IN FIRE SUPPRESSION MODELING

John Grace Arms
21030 Indian St, Southfield MI 48033
Developed by
John Grace Arms LDHA LLC

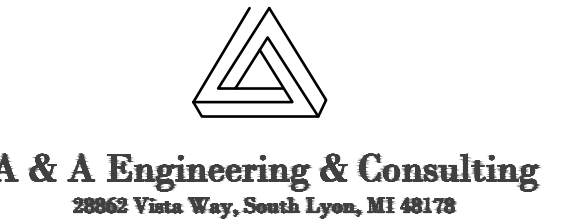

REGISTRATION SEAL



KEY PLANS

SHEET TITLE

PLUMBING SCHEDULES

SCALE: AS NOTED

ISSUED FOR: PERMIT
DATE: 10.20.24
BULLETIN 3
5.19.25

DRAWN BY

CHECKED

APPROVED


FILE NO.

SHEET NO.

21026.00

P-601

5/19/2025 5:34:04 AM

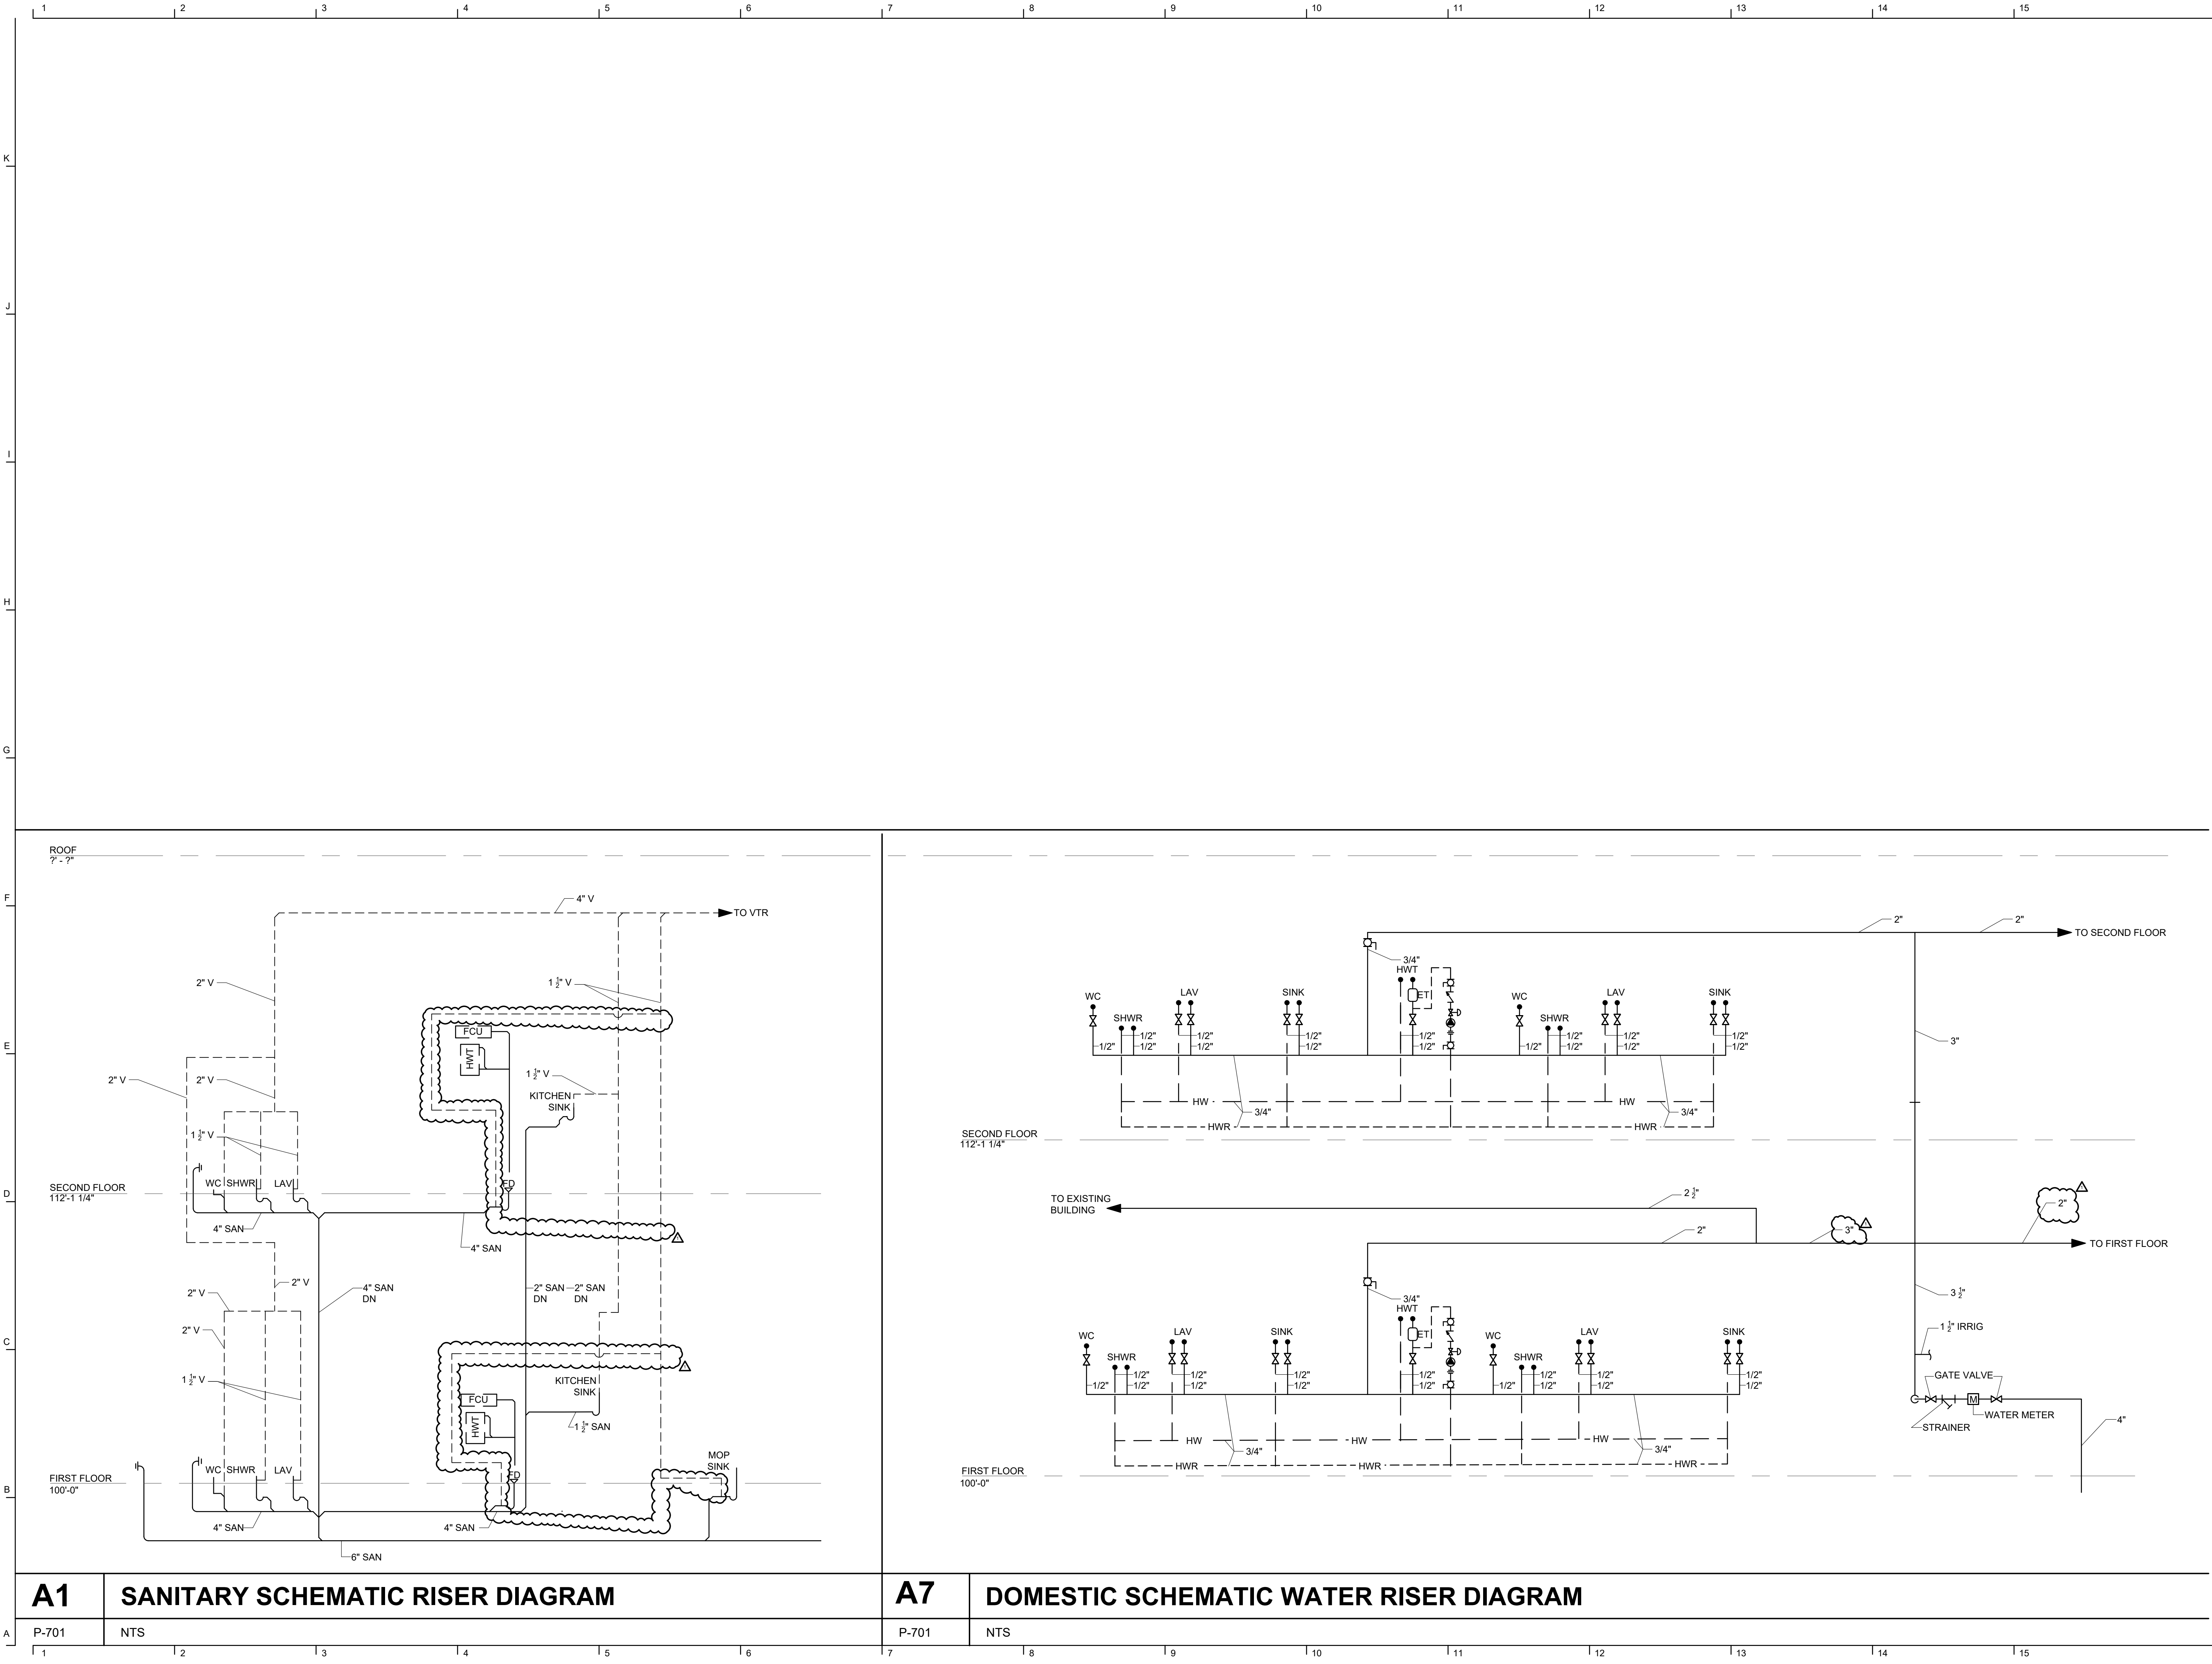

John Grace Arms
21030 Indian St, Southfield MI 48033
Developed by
John Grace Arms LDHA LLC

SDG
Architects + Planners

607 Shelby Street
Suite 704
Detroit, MI 48226

Tel: 313-961-4000
Fax: 313-964-3233

**A & A Engineering & Consulting**
28862 Vista Way, South Lyon, MI 48178

REGISTRATION SEAL



KEY PLANS

SHEET TITLE
**SCHEMATIC PLUMBING
RISER DIAGRAMS**

SCALE: AS NOTED

ISSUED FOR	DATE
PERMIT	10.20.24
Δ BULLETIN 3	5.19.25

DRAWN BY

CHECKED

APPROVED


21026.00

FILE NO.

P-701

SHEET NO.

8. ALL EXISTING ROOF CONDUCTORS ARE TO BE IDENTIFIED AND REPLACED. ROUTING OF THE ROOF CONDUCTORS IS INTENDED TO HAVE THE SAME PATHWAY AND SIZES AS EXISTING. COORDINATE WITH ARCHITECTURAL FOR ROUTING OF ANY POTENTIAL INTERFERENCES OR ADDITIONAL DEMO NEEDED TO COMPLETE REPLACEMENT. COORDINATE WITH CIVIL FOR LOCATIONS OF COMBINED ROOF DRAINAGE PIPING LEAVING THE BUILDING. EXISTING ROUTING OF ROOF CONDUCTORS WERE UNABLE TO BE IDENTIFIED DURING THE TIME OF DESIGN. RESPONSIBILITY OF THE GENERAL CONTRACTOR TO IDENTIFY, REPLACE AND PHASE IN A MANNER TO AVOID ANY OPEN ROOF CONDUCTORS THAT WOULD ALLOW WATER INTO THE BUILDING.

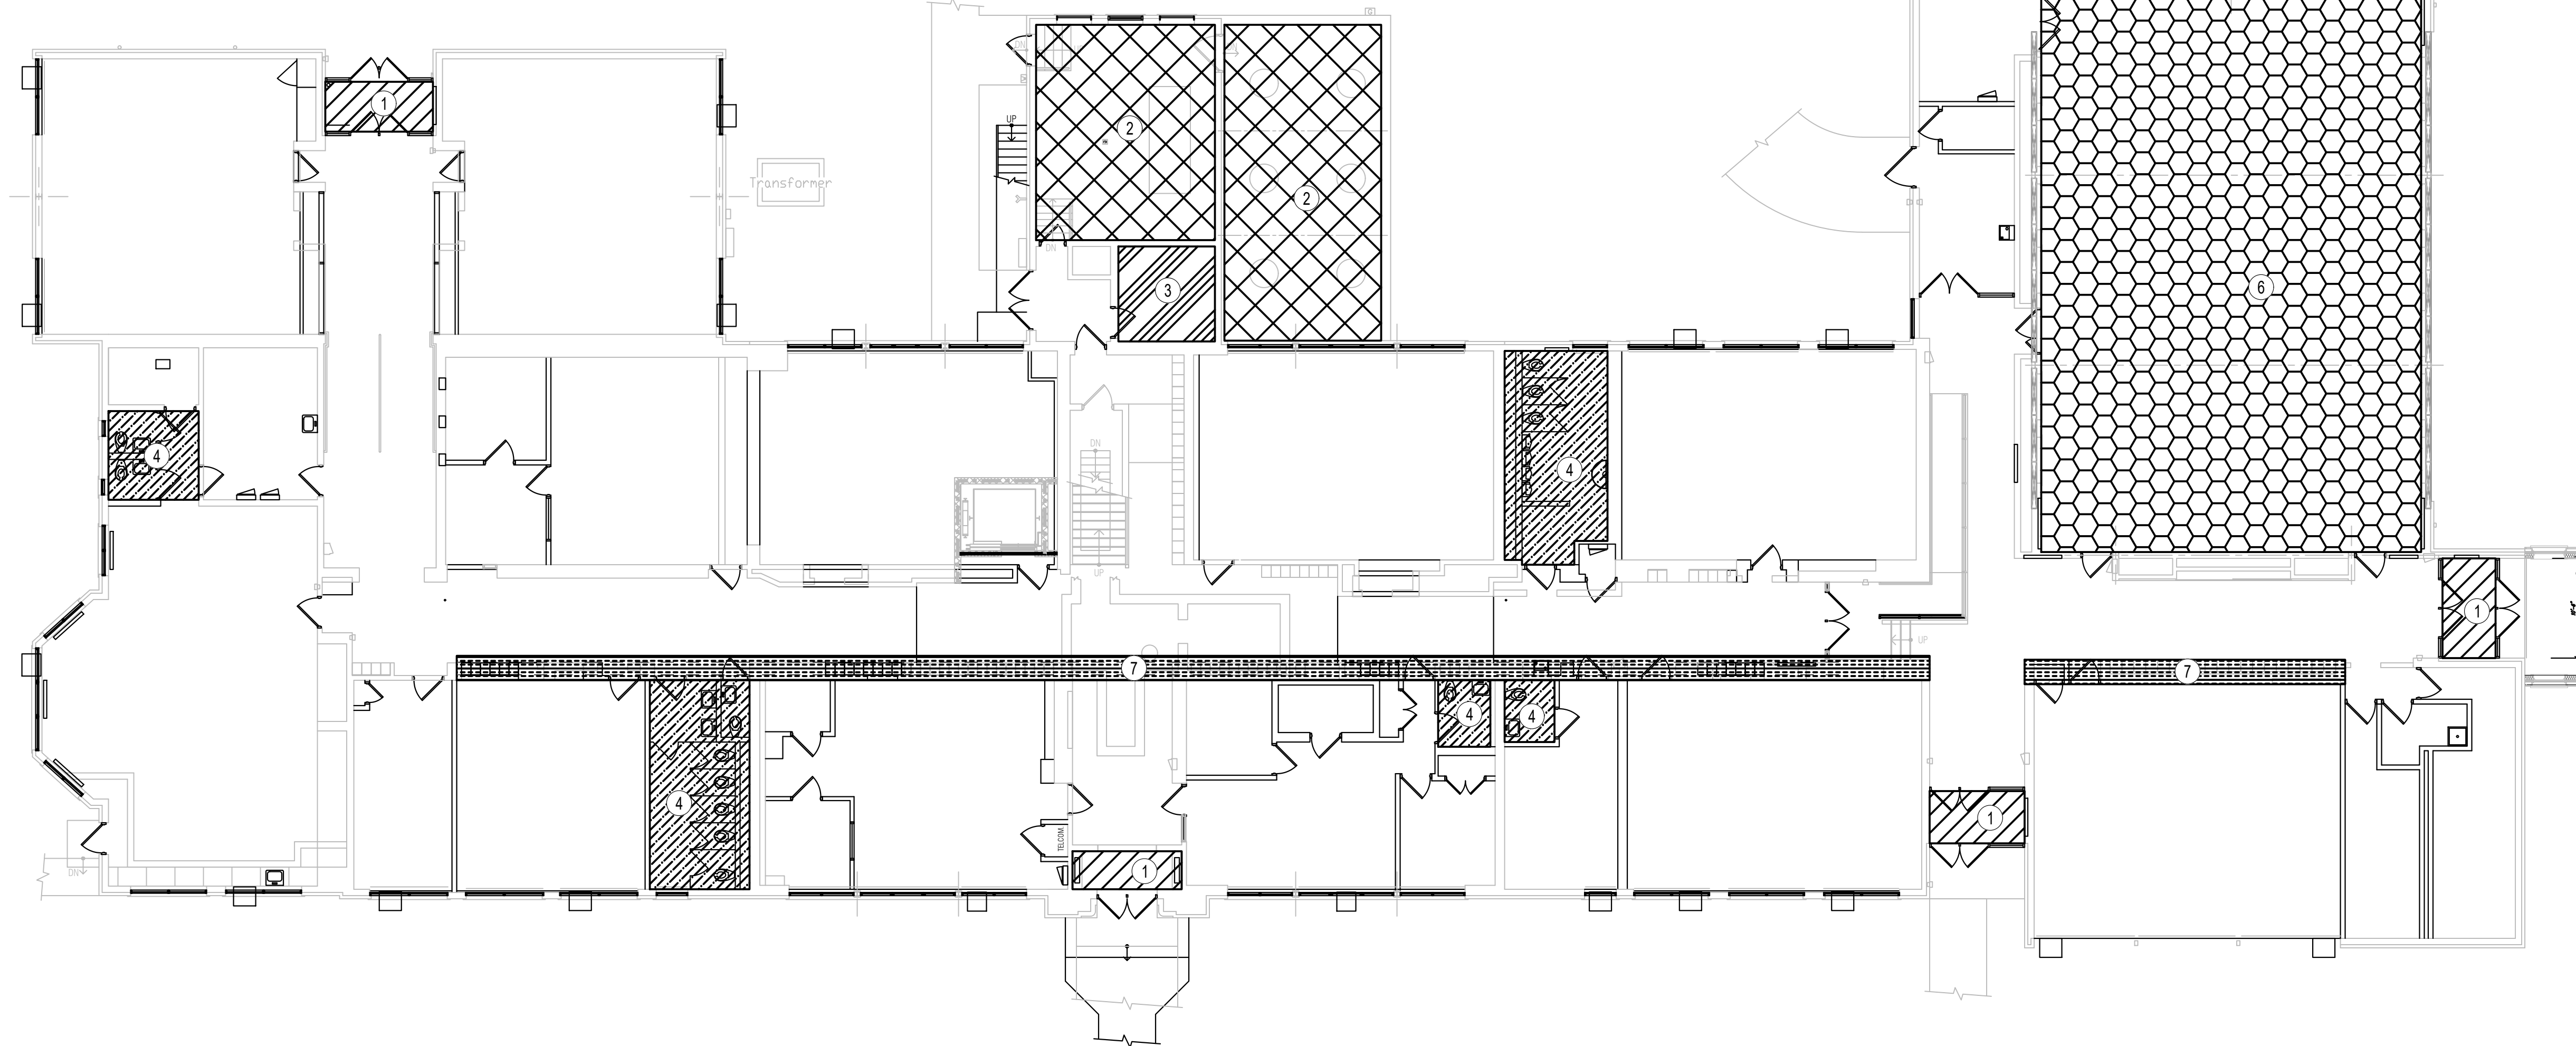

1. IN ALL EXISTING ROOMS AND CORRIDORS, COORDINATE WITH ARCHITECTURAL PLANS AND REMOVE ALL EXISTING STEAM RADIATORS, DRAINS, WATER DISTRIBUTION, DUCTWORK, PNEUMATICS, THERMOSTATS, REGISTERS THAT WILL NOT BE NECESSARY TO BE REUSED FOR HISTORIC PRESERVATION. IF ANY ITEMS ARE TO BE DEEMED HISTORIC FOR EXISTING MECHANICAL OR PLUMBING SYSTEMS CARE AND PROTECTION SHALL BE PROVIDED THROUGHOUT THE DEMO AND CONSTRUCTION PROCESS TO ENSURE ITEMS ARE NOT DAMAGED.
2. ALL EXISTING ROOF CONDUCTORS ARE TO BE IDENTIFIED AND REPLACED. ROUTING OF THE ROOF CONDUCTORS IS INTENDED TO HAVE THE SAME PATHWAY AND SIZES AS EXISTING. COORDINATE WITH ARCHITECTURAL FOR ROUTING OF ANY POTENTIAL INTERFERENCES OR ADDITIONAL DEMO NEEDED TO COMPLETE REPLACEMENT. COORDINATE WITH CIVIL FOR LOCATIONS OF COMBINED ROOF DRAINAGE PIPING LEAVING THE BUILDING. EXISTING ROUTING OF ROOF CONDUCTORS WERE UNABLE TO BE IDENTIFIED DURING THE TIME OF DESIGN.

SDG
Architects + Planners
607 Shelby Street
Suite 704
Detroit, MI 48226
Tel: 313-961-9000
Fax: 313-964-3233



A circular professional engineer seal for the State of Michigan. The outer ring contains the text "STATE OF MICHIGAN" at the top and "LICENSED PROFESSIONAL ENGINEER" at the bottom, separated by two stars. The center of the seal contains the name "STEPHEN M. HENNARD", the title "ENGINEER", the license number "No. 6201059975", and a signature.

SCALE: AS NOTED

DRAWN BY _____

CHECKED _____


APPROVED _____

FILE NO. 21026.00

PD-101

SHEET NO. _____

P-101	$3/32" = 1'-0"$
-------	-----------------

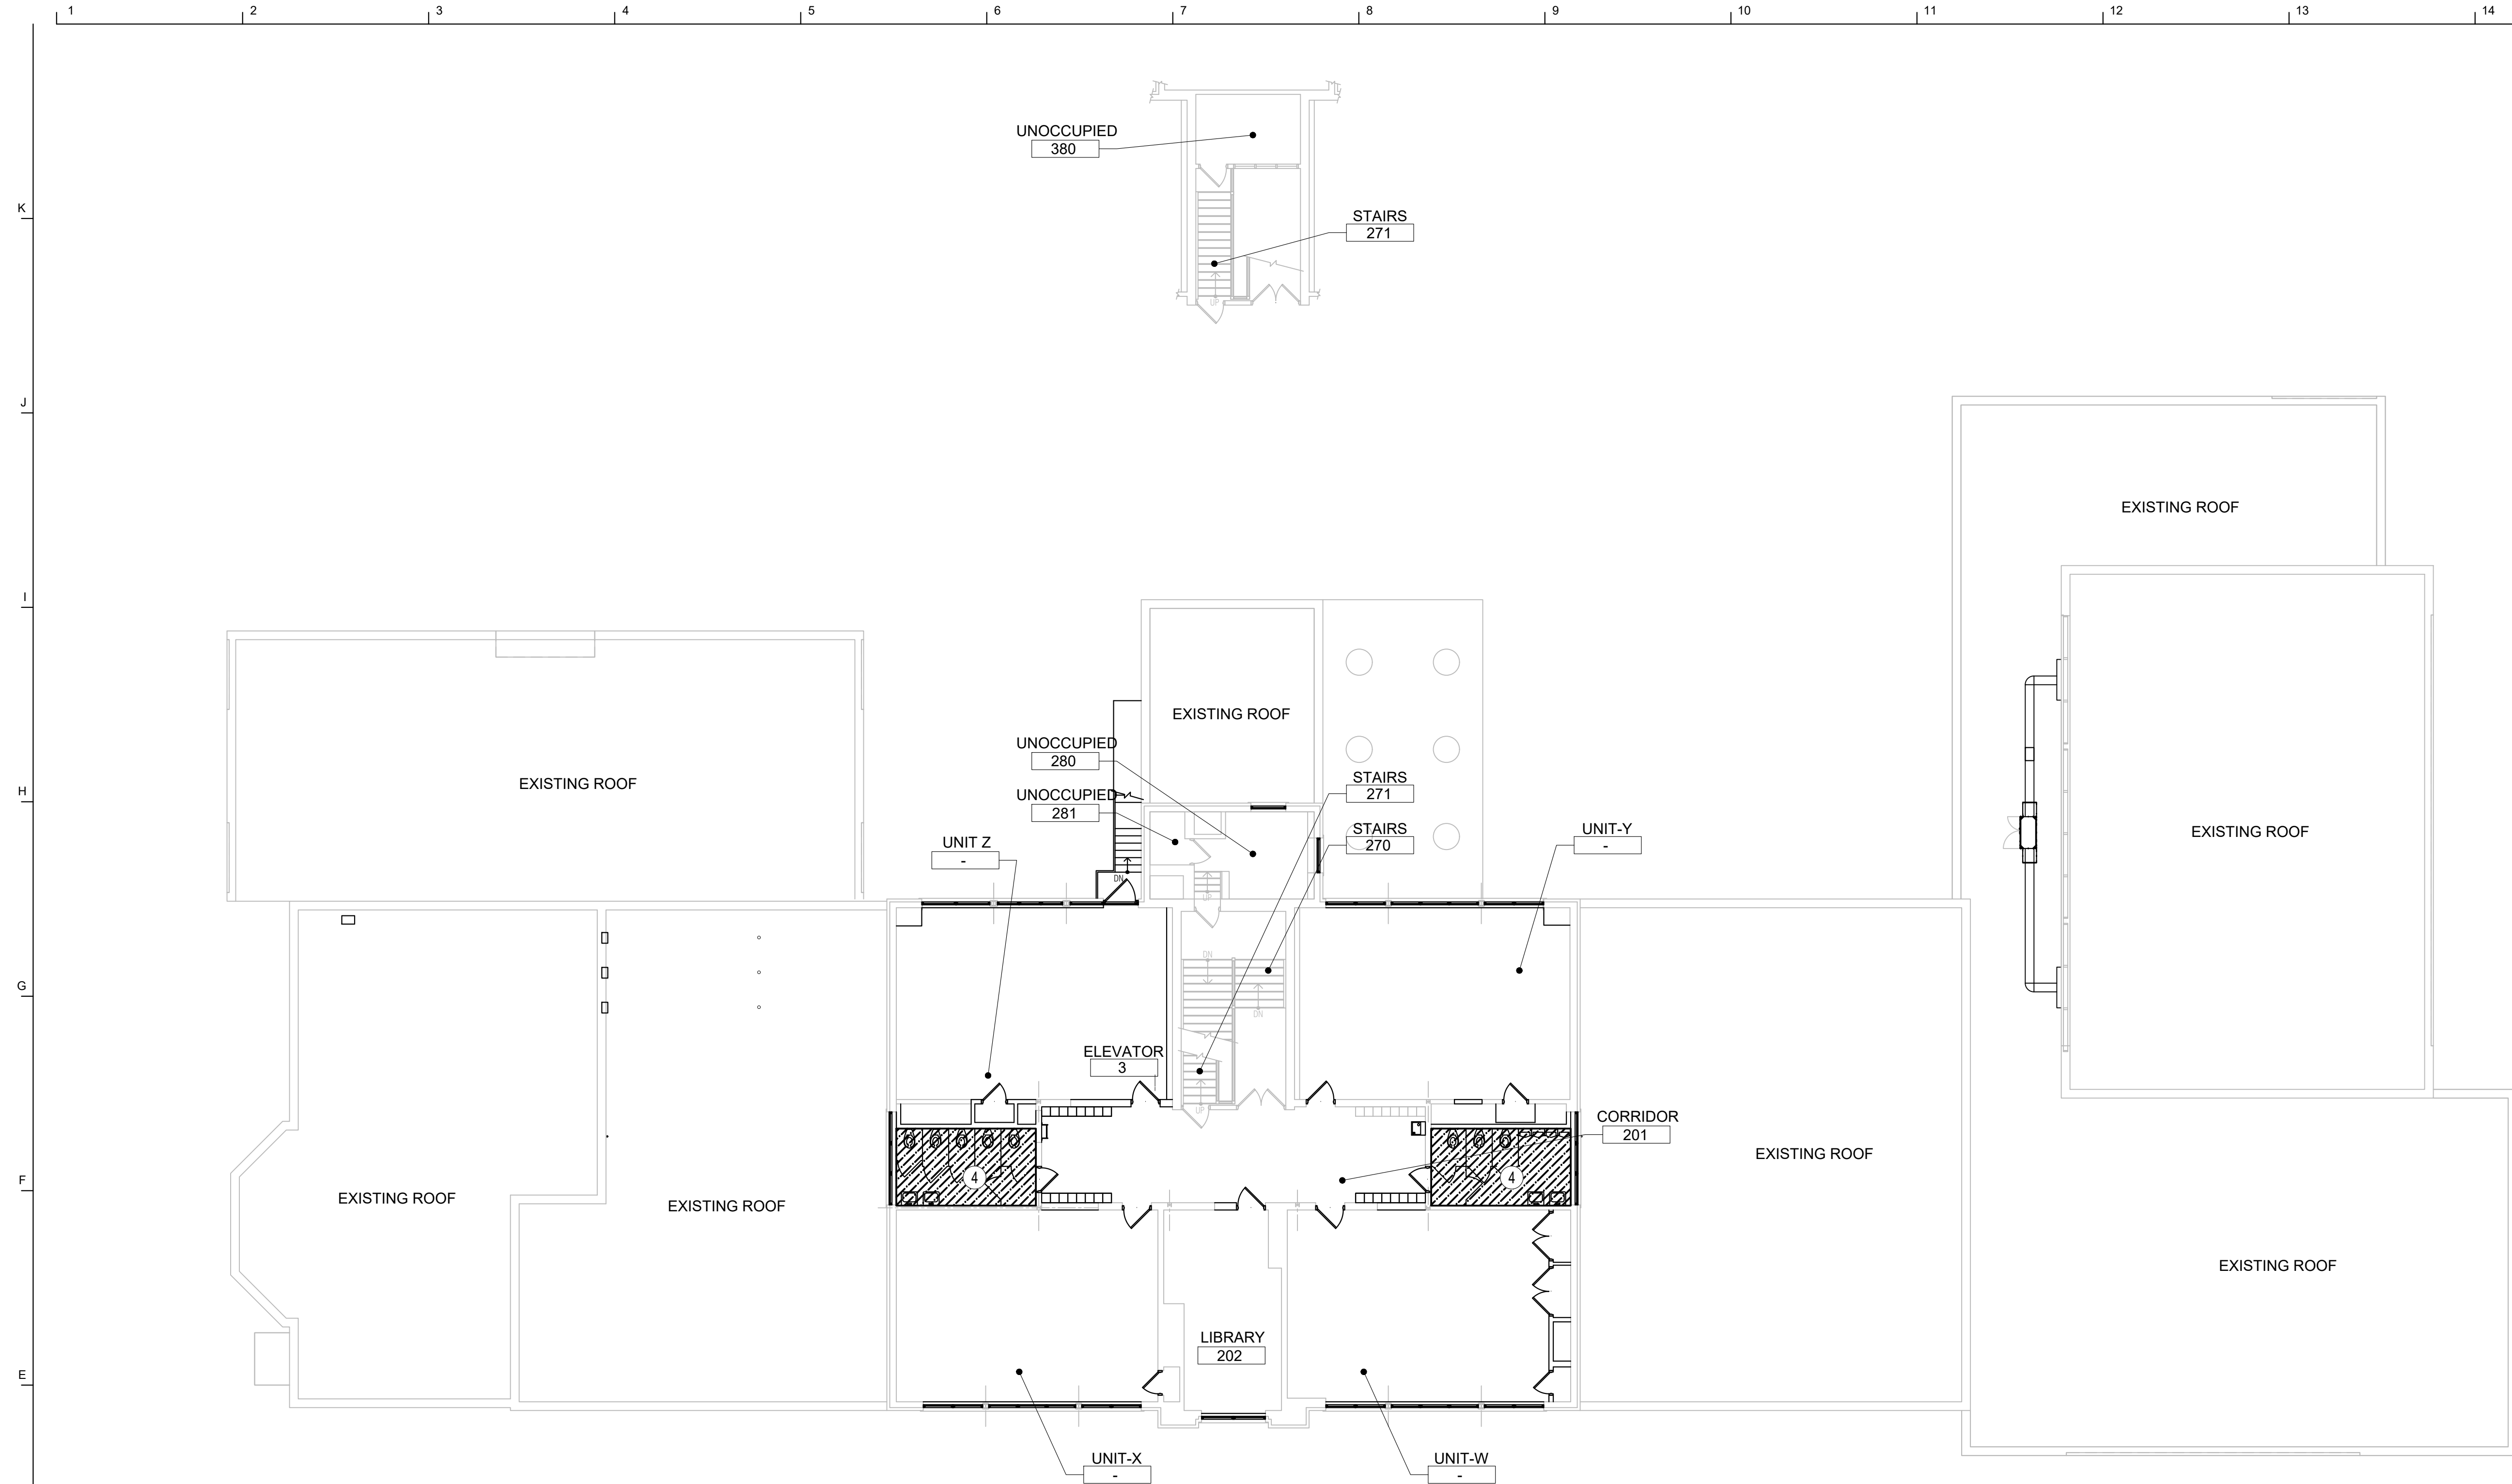

1. IN ALL EXISTING ROOMS AND CORRIDORS, COORDINATE WITH ARCHITECTURAL PLANS AND REMOVE ALL EXISTING STEAM RADIATORS, DRAINS, WATER DISTRIBUTION, DUCTWORK, PNEUMATICS, THERMOSTATS, REGISTERS THAT WILL NOT BE NECESSARY TO BE REUSED FOR HISTORIC PRESERVATION. IF ANY ITEMS ARE TO BE DEEMED HISTORIC FOR EXISTING MECHANICAL OR PLUMBING SYSTEMS CARE AND PROTECTION SHALL BE PROVIDED THROUGHOUT THE DEMO AND CONSTRUCTION PROCESS TO ENSURE ITEMS ARE NOT DAMAGED.

SDG
Architects + Planners
607 Shelby Street
Suite 704
Detroit, MI 48226
Tel: 313-961-9000
Fax: 313-964-3233



STATE OF MICHIGAN
STEPHEN M. HENNARD
ENGINEER
No. 6201059975
LICENSED PROFESSIONAL ENGINEER

SHEET TITLE

SCALE: AS NOTED

APPROVED

FILE NO.

SHEET NO.

1. IN ALL VESTIBULES, DEMO EXISTING RADIATORS. REMOVE ALL ASSOCIATED STEAM AND DRAIN LINES BACK TO SOURCE.
2. DEMO ALL MECHANICAL AND ELECTRICAL EQUIPMENT. IF EQUIPMENT HAS VENTING THROUGH ROOF MATCH NEW ROOF DETAIL TO PATCH. SEE ROOF PLAN. ABANDON ALL FIRE SUPPRESSION AND WATER SERVICES. EXISTING FLOOR DRAIN TO REMAIN, SCOPE TO FIND ROUTING AND CONNECT WITH NEW SANITARY SYSTEM. EXISTING PATHWAY IS NOT KNOWN AT TIME OF DRAWINGS.
3. THIS ROOM COULD NOT BE ACCESSED AT TIME OF DRAWINGS, DEMO ANY AND ALL ELECTRICAL, MECHANICAL AND PLUMBING IN THIS ROOM. IF EXISTING FLOOR DRAIN IN THE ROOM KEEP IN PLACE AND TIE INTO NEW SANITARY LEAD ON THE NEW PLUMBING DRAWINGS
4. DEMO PLUMBING AND MECHANICAL EQUIPMENT, INCLUDING ANY DISTRIBUTION BACK TO SOURCE. DEMO EXISTING FUME HOOD SYSTEM PATCH ROOF AS REQUIRED PER ROOF PLAN.
5. DEMO PLUMBING AND MECHANICAL EQUIPMENT, INCLUDING ANY DISTRIBUTION BACK TO SOURCE. DEMO EXISTING FUME HOOD SYSTEM PATCH ROOF AS REQUIRED PER ROOF PLAN.
6. DEMO ALL SUPPLY DUCT WORK IN EXISTING GYM.

9. ALL EXISTING ROOF CONDUCTORS ARE TO BE IDENTIFIED AND REPLACED. ROUTING OF THE ROOF CONDUCTORS IS INTENDED TO HAVE THE SAME PATHWAY AND SIZES AS EXISTING. COORDINATE WITH ARCHITECTURAL FOR ROUTING OF ANY POTENTIAL INTERFERENCES OR ADDITIONAL DEMO NEEDED TO COMPLETE REPLACEMENT. COORDINATE WITH CIVIL FOR LOCATIONS OF COMBINED ROOF DRAINAGE PIPING LEAVING THE BUILDING. EXISTING ROUTING OF ROOF CONDUCTORS WERE UNABLE TO BE IDENTIFIED DURING THE TIME OF DESIGN. RESPONSIBILITY OF THE GENERAL CONTRACTOR TO IDENTIFY, REPLACE AND PHASE IN A MANNER TO AVOID ANY OPEN ROOF CONDUCTORS THAT WOULD ALLOW WATER INTO THE BUILDING.

SCALE: 3/32" = 1'-0"